



KEY MAP

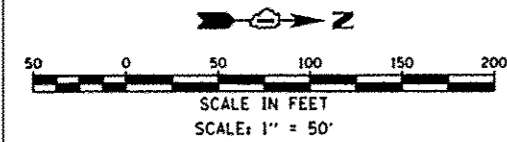

NOTES:

1. THE EXISTING LIGHT POLE, METAL FOUNDATION AND BREAKAWAY TRANSFORMER BASE SHALL BE REMOVED. THE METAL FOUNDATION SHALL BE REMOVED AND DISPOSED OF OFF THE PROJECT SITE. REMOVED LIGHT POLE AND BREAKAWAY TRANSFORMER BASE SHALL BE REINSTALLED AS SHOWN ON PROPOSED LIGHTING PLANS. THE REMOVAL, STORAGE DURING CONSTRUCTION AND REINSTALLATION OF REMOVED LIGHT POLE AND BREAKAWAY TRANSFORMER BASE SHALL BE PART OF THE PAY ITEM "RELOCATE EXISTING LIGHTING UNIT"
2. THE EXISTING LIGHT POLE SHALL BE REMOVED, METAL FOUNDATION AND BREAKAWAY TRANSFORMER BASE SHALL REMAIN IN PLACE. THE REMOVAL, STORAGE DURING CONSTRUCTION AND REINSTALLATION OF REMOVED LIGHT POLE SHALL BE PART OF THE PAY ITEM "RELOCATE EXISTING LIGHTING UNIT"
3. THE EXISTING 310W HPS LUMINAIRE SHALL BE REMOVED AND TEMPORARY 400W HPS TYPE III LUMINAIRE SHALL BE INSTALLED ON EXISTING LIGHTING UNIT. THE CONTRACTOR SHALL STORE THE EXISTING 310W HPS LUMINAIRE AND REINSTALL WITH NEW LAMP AFTER COMPLETION OF STAGE 2 CONSTRUCTION.
4. THE EXISTING LIGHTING SYSTEM SHALL BE REMOVED AFTER TEMPORARY LIGHTING SYSTEM IS INSTALLED AND MADE OPERATIONAL.
5. THE EXPOSED EXISTING UNIT DUCTS SHALL BE PROTECTED DURING CONSTRUCTION. THE SUGGESTED ALTERNATIVE IS TO INSTALL ANOTHER TRANSFORMER BASE ON TOP OF EXISTING TRANSFORMER BASE AND COVER IT WITH METAL PLATE. ANY DAMAGED AND MISSING EXISTING UNIT DUCTS AND TRANSFORMER BASE DURING CONSTRUCTION AFTER REMOVAL OF EXISTING LIGHT POLE SHALL BE REPLACED IN KIND BY THE CONTRACTOR AT NO ADDITIONAL COST. THE MATERIALS AND LABOR NEEDED FOR PROTECTION OF EXPOSED UNIT DUCTS SHALL BE INCLUDED AS PART OF THE PAY ITEM "MAINTENANCE OF LIGHTING SYSTEM"

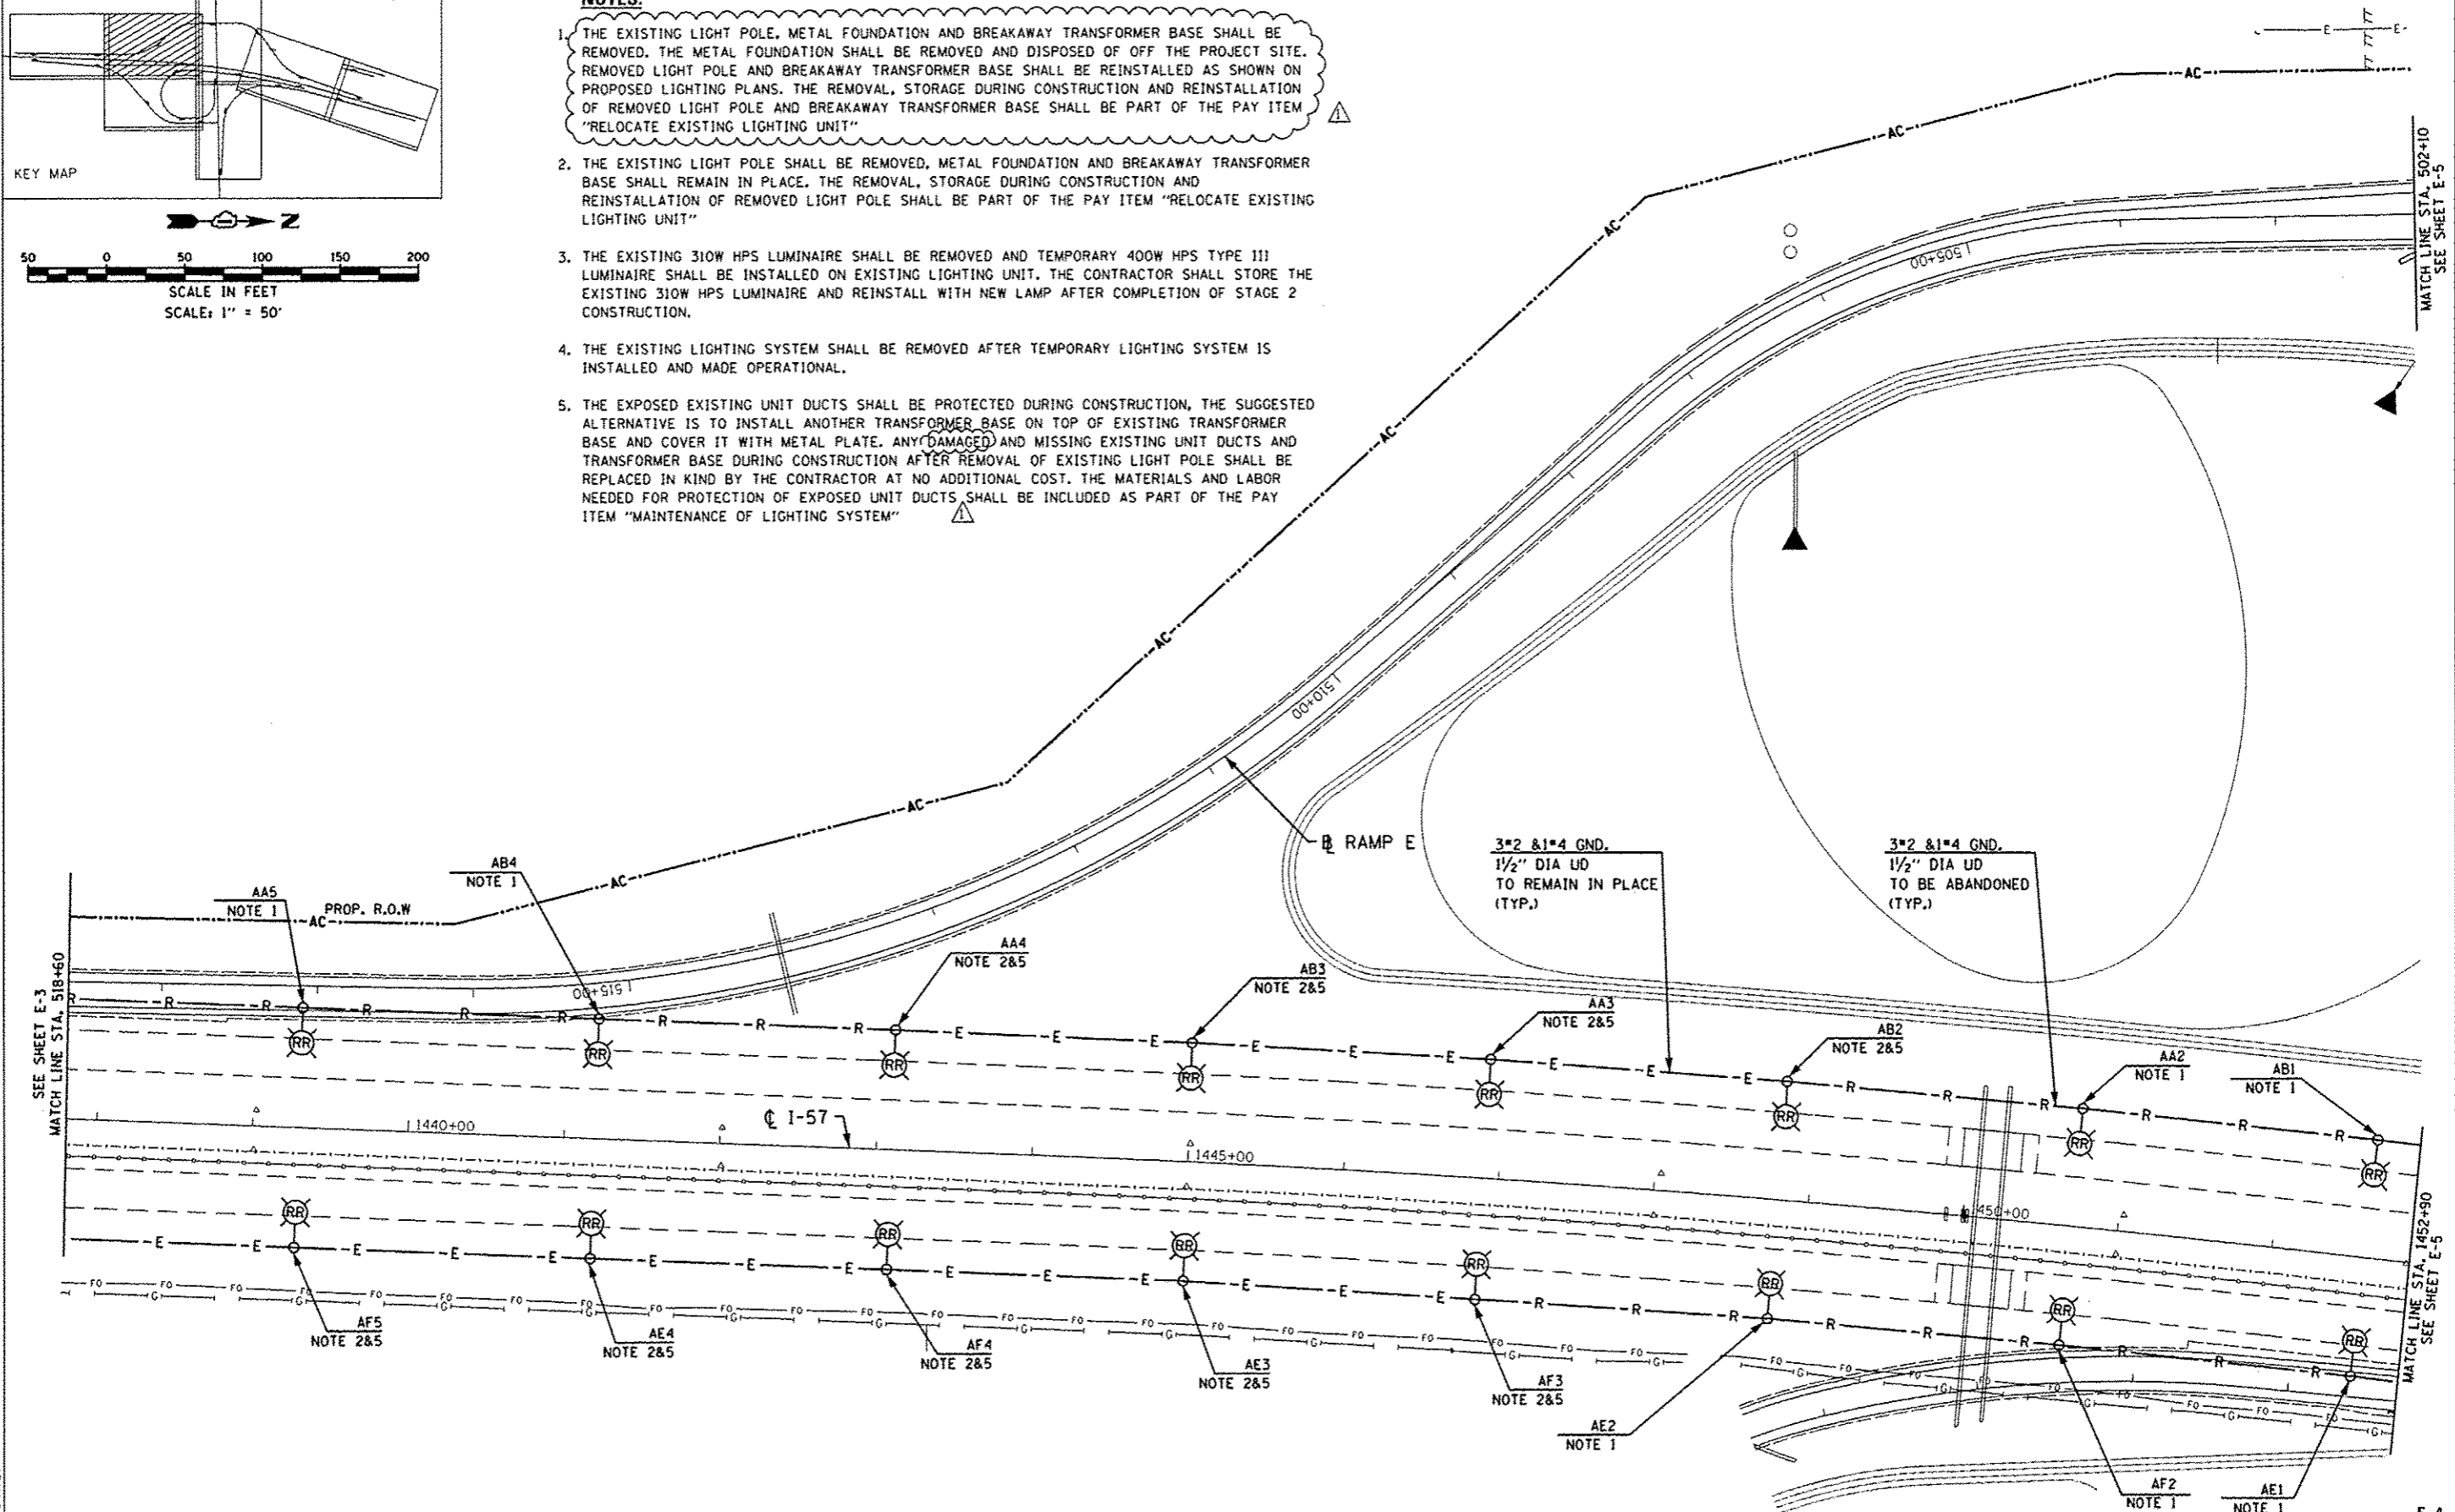

J:\327\DMN\CAD Sheets\DISOLE69-sh1-light-04.dgn 26-DEC-2013 15:08 TIME\$



USER NAME = kprajapati
 PLOT SCALE = 100.000000000000
 PLOT DATE = 26-DEC-2013 15:00

DESIGNED - RDP
 DRAWN - MC/WC
 CHECKED - KGP
 DATE - 8/22/2013

REVISED 6/18/2013
 REVISED 8/22/2013
 REVISED 10/18/2013
 REVISED 12/04/2013

**STATE OF ILLINOIS
 DEPARTMENT OF TRANSPORTATION**

**STUENKEL ROAD OVER I-57
 EXISTING LIGHTING REMOVAL PLANS**

SCALE: AS NOTED | SHEET NO. 4 OF 24 SHEETS | STA. ----- TO STA. -----

F.A.J. RTE.	SECTION	COUNTY	TOTAL SHEETS	SHEET NO.
57	99-1NB-R	WILL	679	327
CONTRACT NO. 60L69			ILLINOIS FED. AID PROJECT	

ADDENDUM 1 1/03/14