


NOTE:
 1. THE EXISTING 310W HPS LUMINAIRE SHALL BE REMOVED AND TEMPORARY 400W HPS TYPE III LUMINAIRE SHALL BE INSTALLED ON EXISTING LIGHTING UNIT. THE CONTRACTOR SHALL REMOVE TEMPORARY 400W LUMINAIRE LUMINAIRE AND REINSTALL 310W EXISTING LUMINAIRE AFTER COMPLETION OF STAGE 2.

NOTES FOR LIGHTING DURING CONSTRUCTION
 A. COMPLETE TEMPORARY LIGHTING SYSTEM INCLUDING, RELOCATION OF EXISTING CONTROLLER, TEMPORARY LIGHTING UNITS, AERIAL CABLES, AND OTHER TEMPORARY LIGHTING ITEMS SHOWN ON THE TEMPORARY LIGHTING PLANS SHALL BE INSTALLED IN APPROVED OPERATION DURING PRE-STAGE 1 CONSTRUCTION PRIOR TO REMOVAL OF EXISTING LIGHTING SYSTEM UNLESS NOTED OTHERWISE.
 B. TEMPORARY LIGHTING SYSTEM SHALL BE REMOVED AFTER PROPOSED LIGHTING SYSTEM IS INSTALLED IN APPROVED OPERATION.

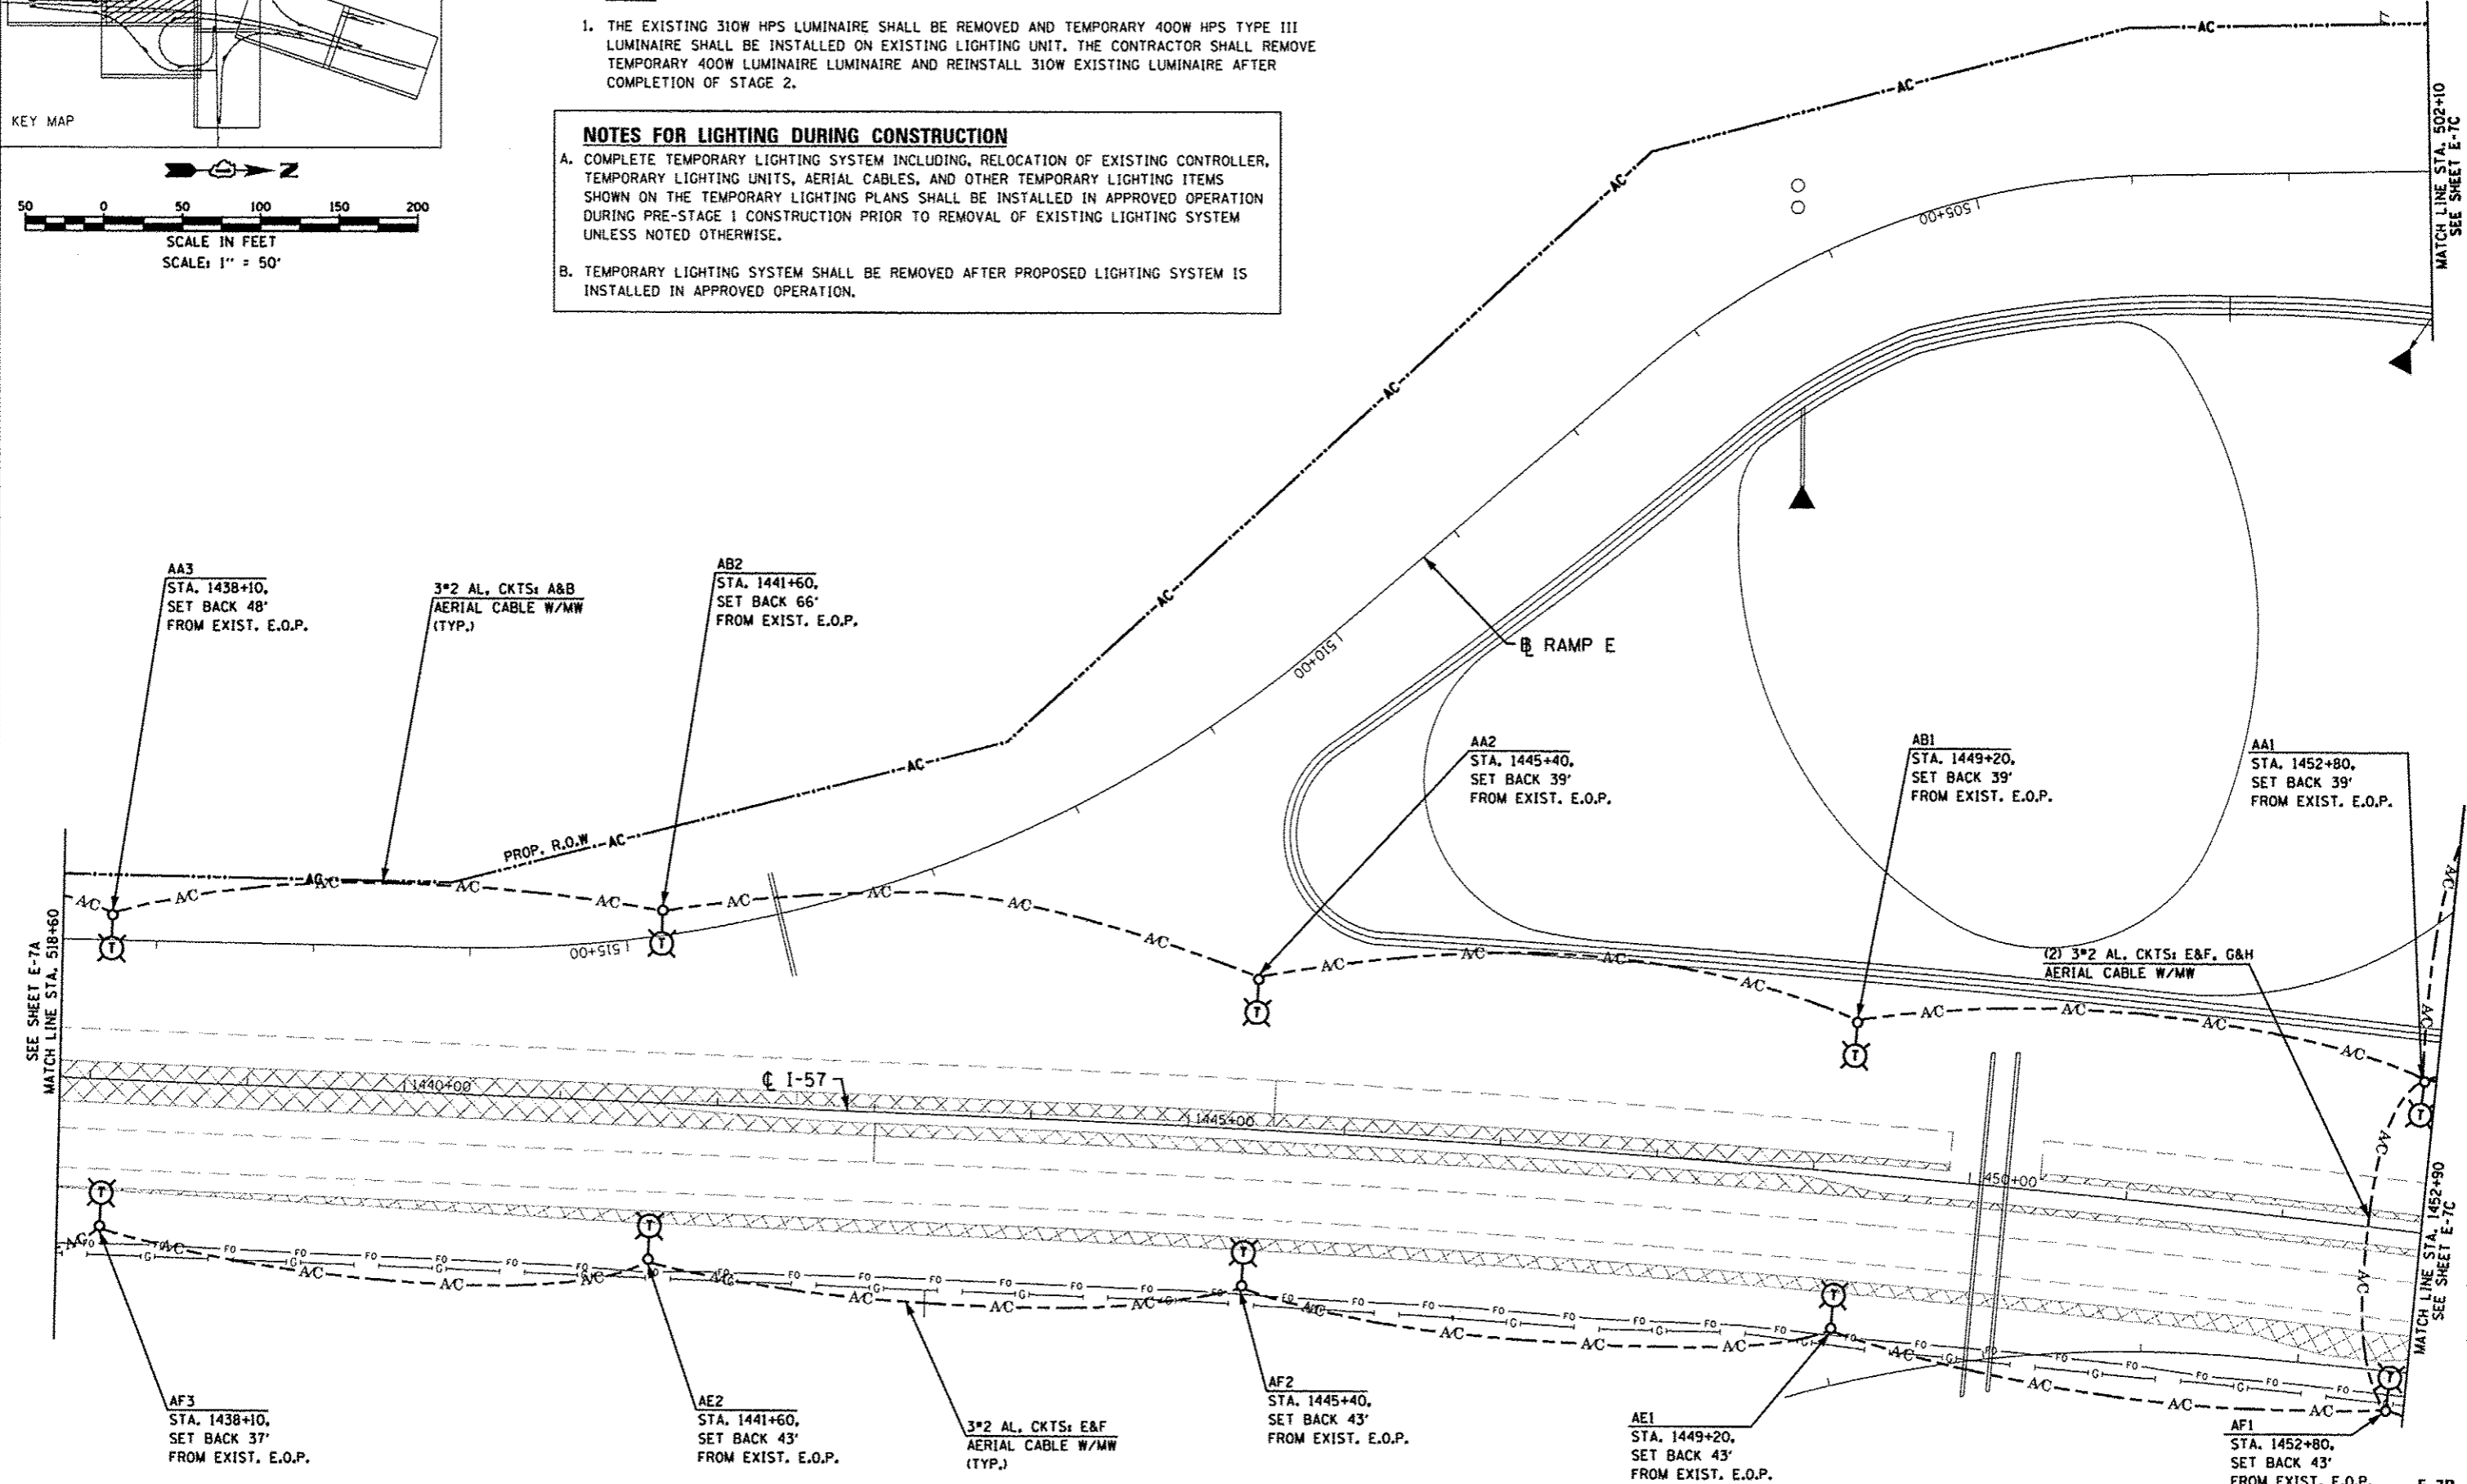

I:\327\ADGEN\CADD_Sheets\016\60L69-sht-light-07b.dgn
 05-DEC-2013 13:18:53 TIME \$

SINGH
 SINGH & ASSOCIATES INC.
 CONSULTING ENGINEERS

USER NAME * mgr-v166	DESIGNED - RDP	REVISED 6/18/2013
PLOT SCALE * 100.000000x1.000000	DRAWN - MG/WC	REVISED 8/22/2013
PLOT DATE * 05-DEC-2013 13:18	CHECKED - KGP	REVISED 10/18/2013
	DATE - 8/22/2013	REVISED - 12/04/2013

STATE OF ILLINOIS
 DEPARTMENT OF TRANSPORTATION

STUENKEL ROAD OVER I-57
 TEMPORARY LIGHTING PLANS - STAGE 1&2

SCALE: AS NOTED SHEET NO. 9 OF 24 SHEETS STA. ----- TO STA. -----

F.A.I. RTE.	SECTION	COUNTY	TOTAL SHEETS	SHEET NO.
57	99-1H8-R	WILL	679	330B
CONTRACT NO. 60L69				
ILLINOIS FED. AID PROJECT				

E-7B