


NOTES FOR LIGHTING DURING CONSTRUCTION

A. COMPLETE TEMPORARY LIGHTING SYSTEM INCLUDING, RELOCATION OF EXISTING CONTROLLER, TEMPORARY LIGHTING UNITS, AERIAL CABLES, AND OTHER TEMPORARY LIGHTING ITEMS SHOWN ON THE TEMPORARY LIGHTING PLANS SHALL BE INSTALLED IN APPROVED OPERATION DURING PRE-STAGE 1 CONSTRUCTION PRIOR TO REMOVAL OF EXISTING LIGHTING SYSTEM UNLESS NOTED OTHERWISE.

B. TEMPORARY LIGHTING SYSTEM SHALL BE REMOVED AFTER PROPOSED LIGHTING SYSTEM IS INSTALLED IN APPROVED OPERATION.

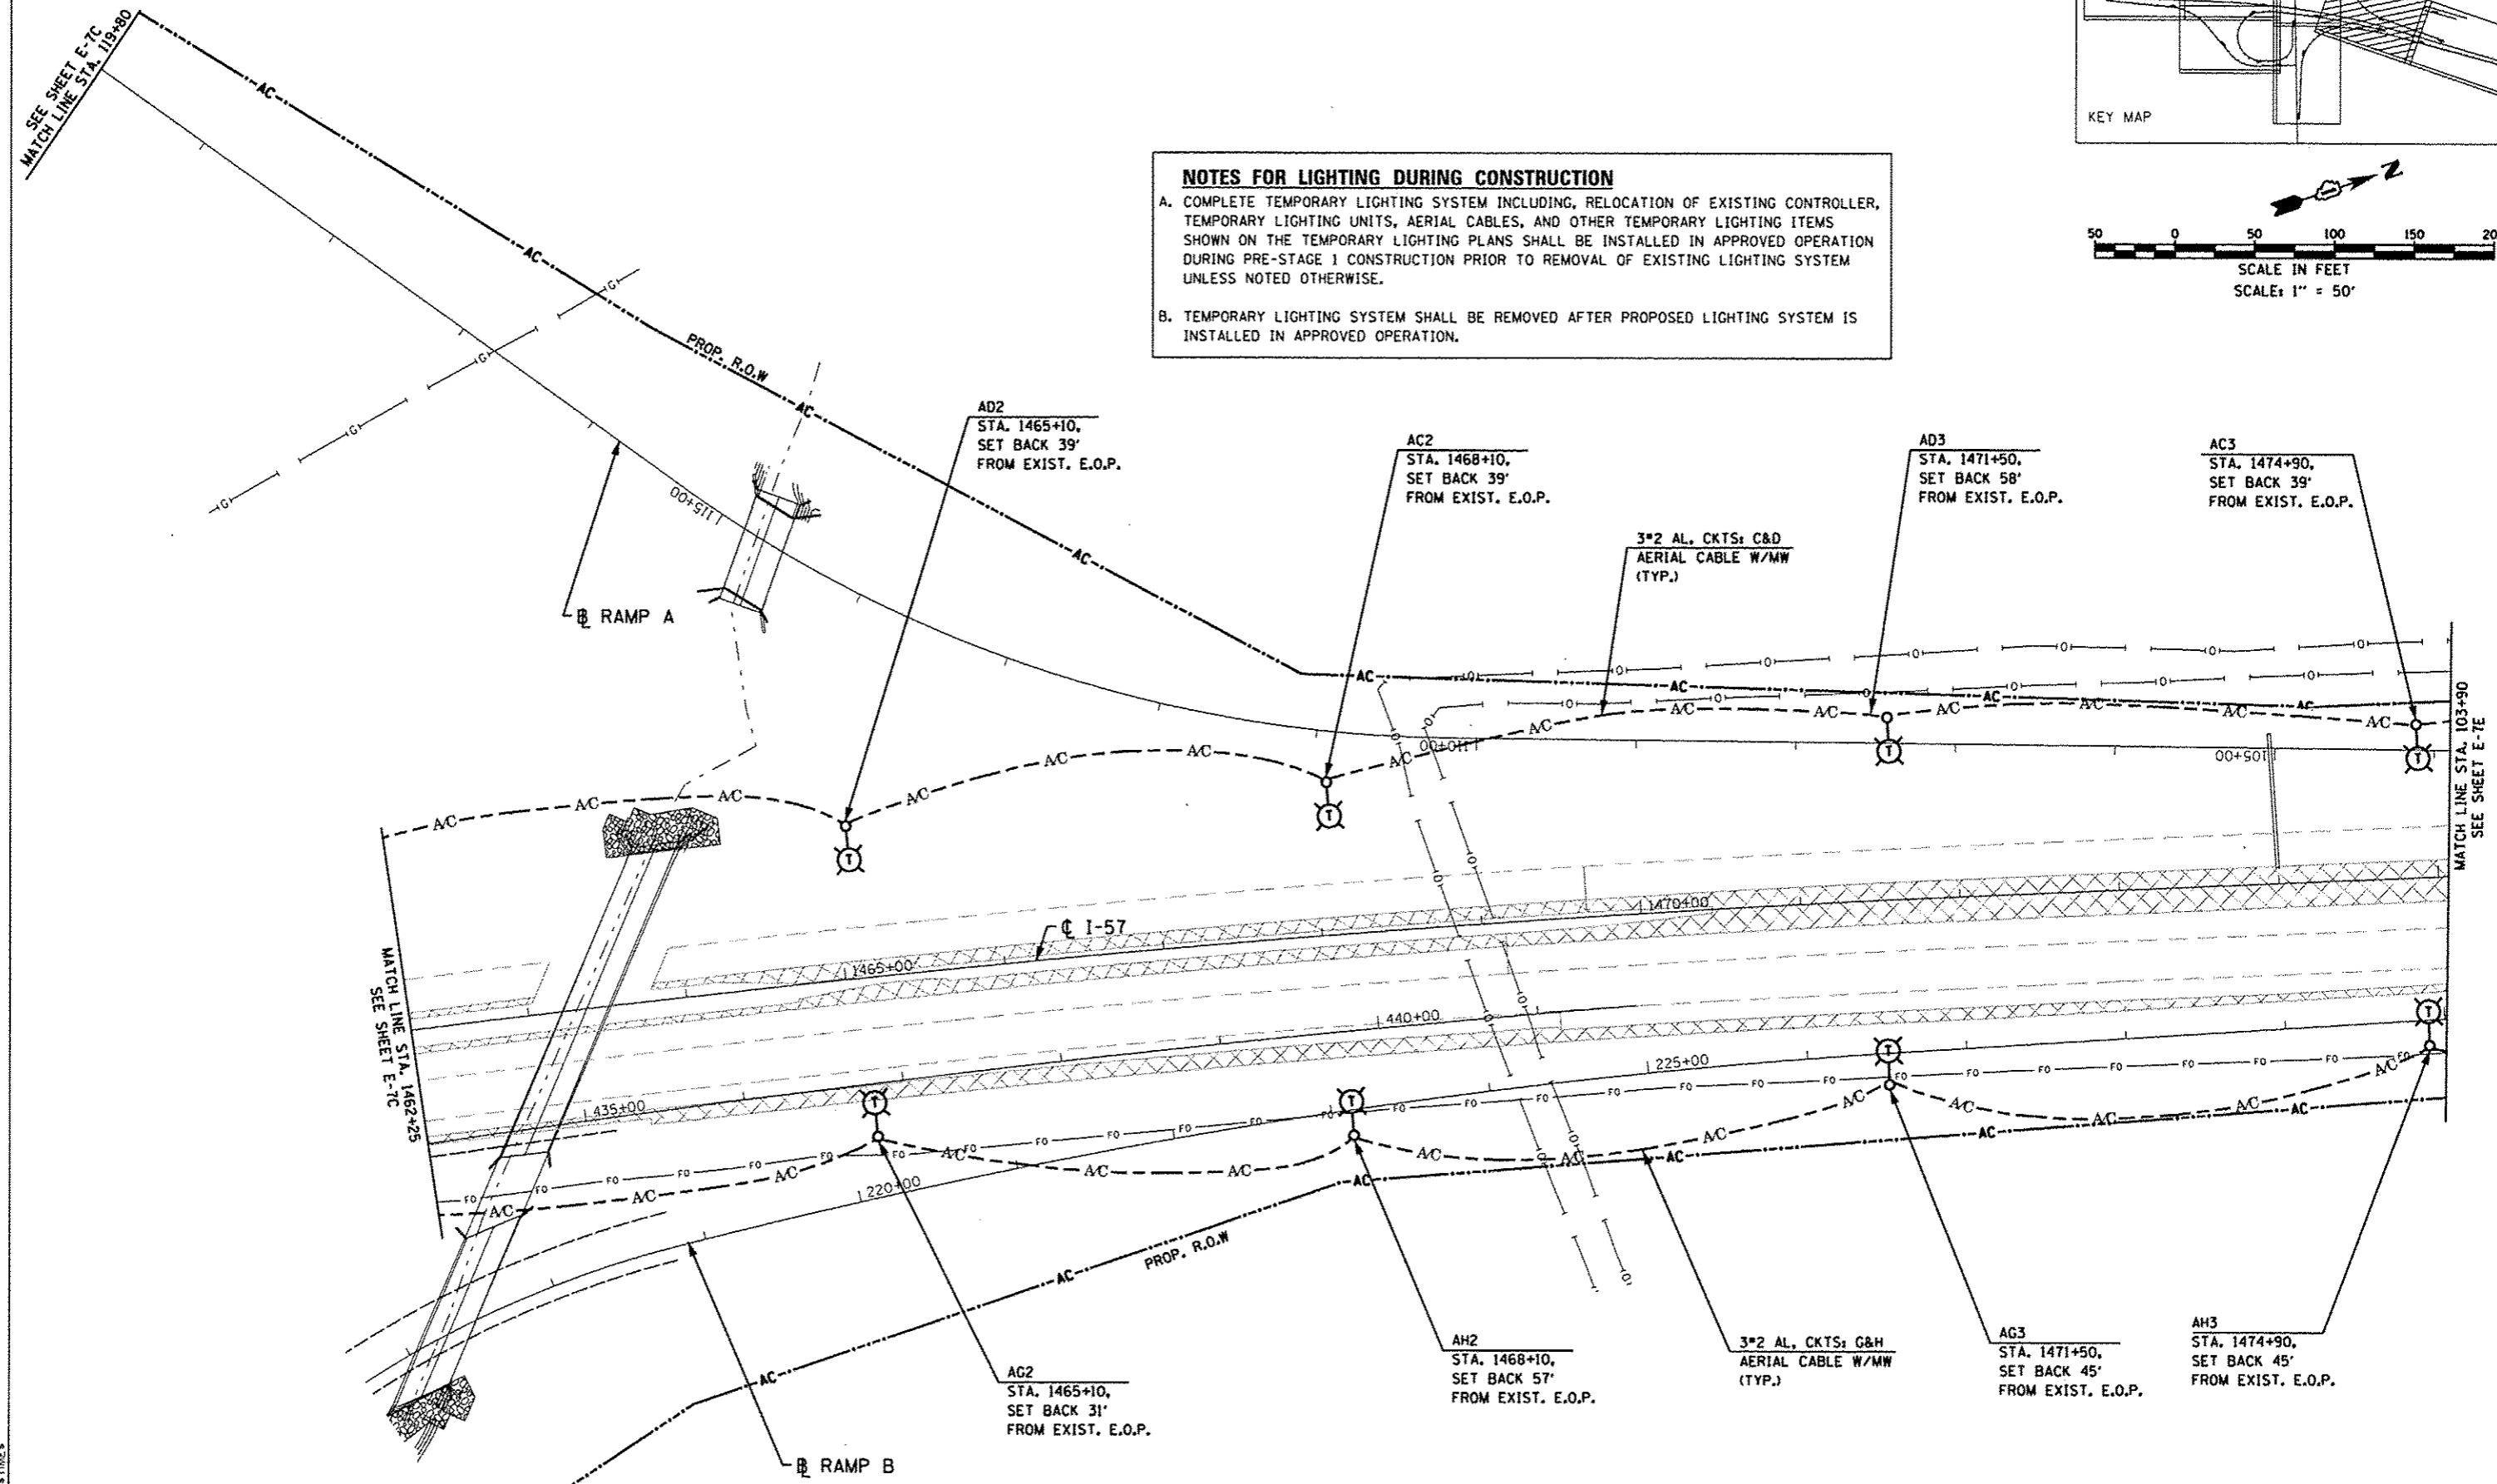

U:\327\ADGNY\CADD_Sheets\01601.E9-sht-light-07.dwg
05-DEC-2013 13:18 TIME\$

SINGH SINGH & ASSOCIATES, INC. CONSULTING ENGINEERS	USER NAME * mgrvsido	DESIGNED - RDP	REVISED 6/18/2013
	PLOT SCALE * 100.000000/1.000000	DRAWN - MG/WC	REVISED 8/22/2013
	PLOT DATE * 05-DEC-2013 13:18	CHECKED - KGP	REVISED 10/18/2013
		DATE - 8/22/2013	REVISED - 12/04/2013

STATE OF ILLINOIS
DEPARTMENT OF TRANSPORTATION

STUENKEL ROAD OVER I-57
TEMPORARY LIGHTING PLANS - STAGE 1&2

SCALE: AS NOTED SHEET NO. 11 OF 24 SHEETS STA. ----- TO STA. -----

F.A.I. RTE. 57	SECTION 99-1HB-R	COUNTY WILL	TOTAL SHEETS 679	SHEET NO. 330D
			CONTRACT NO. 60L69	
ILLINOIS FED. AID PROJECT				

E-7D