 




 
 

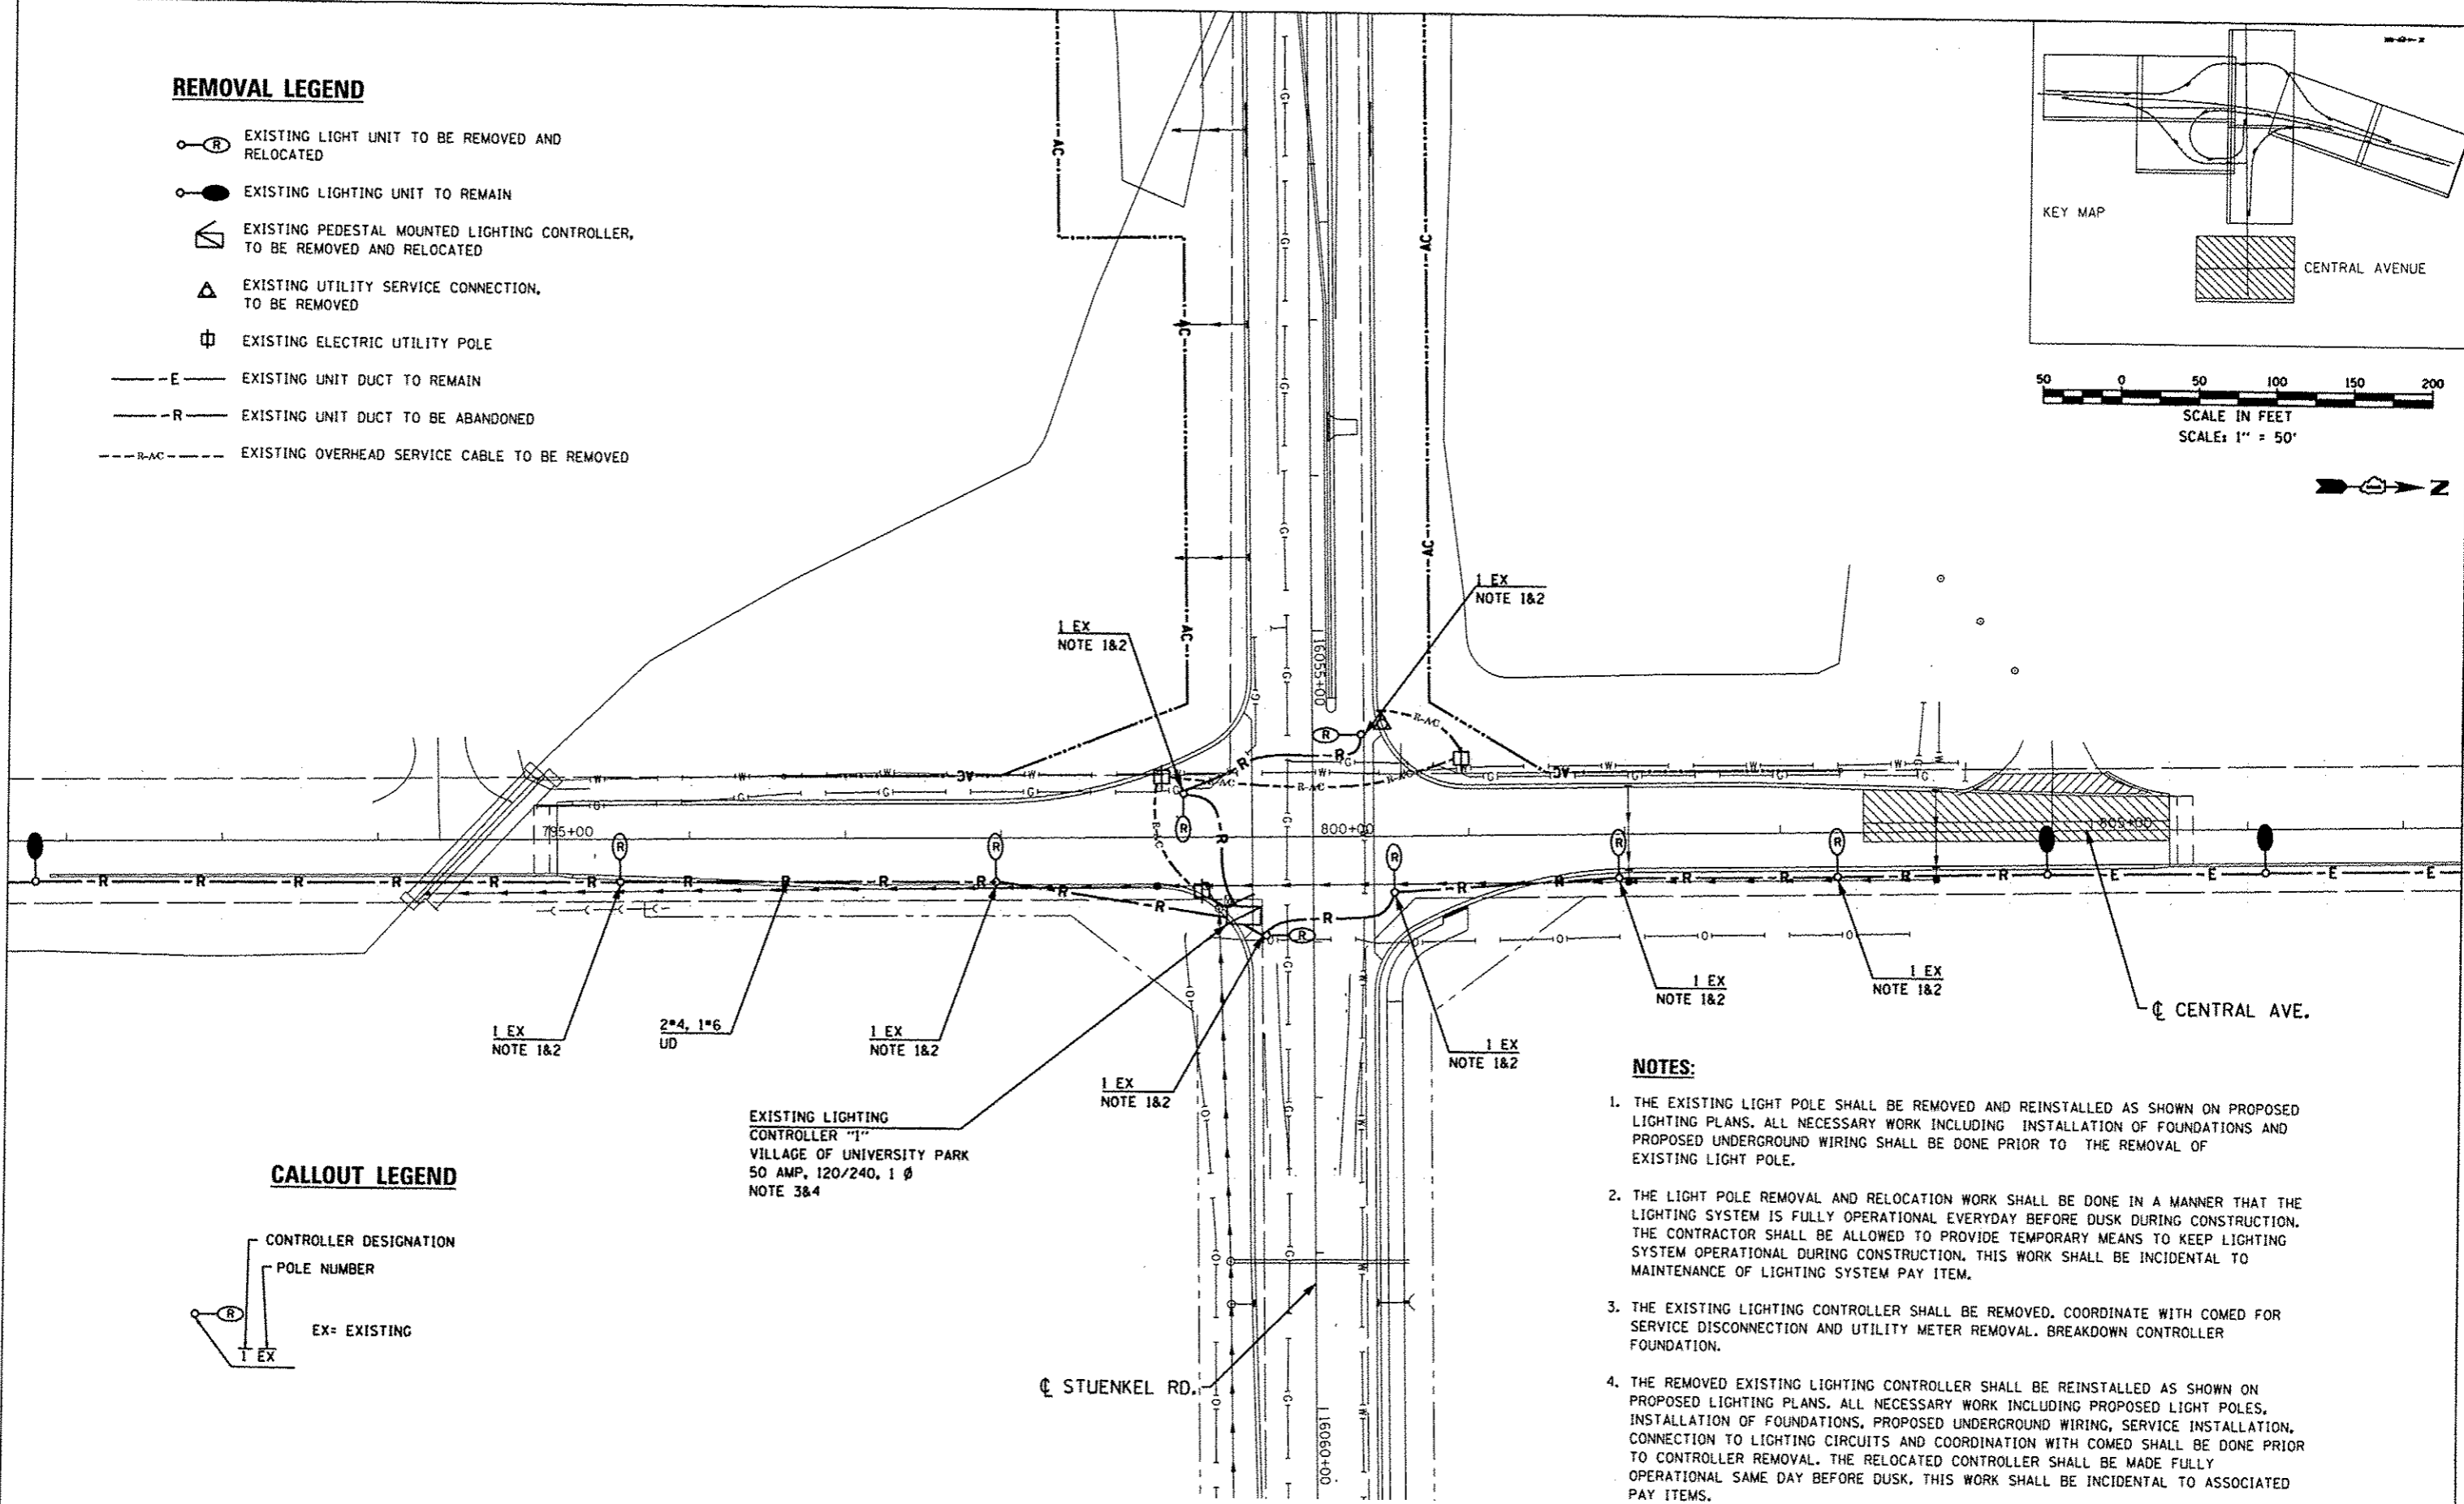
 
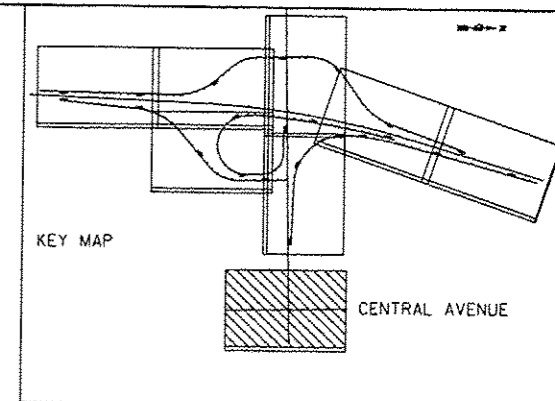
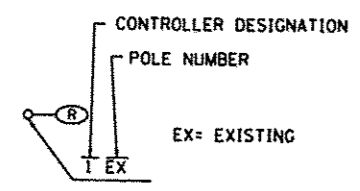


REMOVAL LEGEND

-  EXISTING LIGHT UNIT TO BE REMOVED AND RELOCATED
-  EXISTING LIGHTING UNIT TO REMAIN
-  EXISTING PEDESTAL MOUNTED LIGHTING CONTROLLER, TO BE REMOVED AND RELOCATED
-  EXISTING UTILITY SERVICE CONNECTION, TO BE REMOVED
-  EXISTING ELECTRIC UTILITY POLE
-  -E- EXISTING UNIT DUCT TO REMAIN
-  -R- EXISTING UNIT DUCT TO BE ABANDONED
-  -R-AC- EXISTING OVERHEAD SERVICE CABLE TO BE REMOVED



CALLOUT LEGEND



EXISTING LIGHTING CONTROLLER "I"
VILLAGE OF UNIVERSITY PARK
50 AMP, 120/240, 1 Ø
NOTE 3&4

NOTES:

1. THE EXISTING LIGHT POLE SHALL BE REMOVED AND REINSTALLED AS SHOWN ON PROPOSED LIGHTING PLANS. ALL NECESSARY WORK INCLUDING INSTALLATION OF FOUNDATIONS AND PROPOSED UNDERGROUND WIRING SHALL BE DONE PRIOR TO THE REMOVAL OF EXISTING LIGHT POLE.
2. THE LIGHT POLE REMOVAL AND RELOCATION WORK SHALL BE DONE IN A MANNER THAT THE LIGHTING SYSTEM IS FULLY OPERATIONAL EVERYDAY BEFORE DUSK DURING CONSTRUCTION. THE CONTRACTOR SHALL BE ALLOWED TO PROVIDE TEMPORARY MEANS TO KEEP LIGHTING SYSTEM OPERATIONAL DURING CONSTRUCTION. THIS WORK SHALL BE INCIDENTAL TO MAINTENANCE OF LIGHTING SYSTEM PAY ITEM.
3. THE EXISTING LIGHTING CONTROLLER SHALL BE REMOVED. COORDINATE WITH COMED FOR SERVICE DISCONNECTION AND UTILITY METER REMOVAL. BREAKDOWN CONTROLLER FOUNDATION.
4. THE REMOVED EXISTING LIGHTING CONTROLLER SHALL BE REINSTALLED AS SHOWN ON PROPOSED LIGHTING PLANS. ALL NECESSARY WORK INCLUDING PROPOSED LIGHT POLES, INSTALLATION OF FOUNDATIONS, PROPOSED UNDERGROUND WIRING, SERVICE INSTALLATION, CONNECTION TO LIGHTING CIRCUITS AND COORDINATION WITH COMED SHALL BE DONE PRIOR TO CONTROLLER REMOVAL. THE RELOCATED CONTROLLER SHALL BE MADE FULLY OPERATIONAL SAME DAY BEFORE DUSK. THIS WORK SHALL BE INCIDENTAL TO ASSOCIATED PAY ITEMS.

I:\271\DCIN\6400_Sheets\DI60L69-shr-light-17.dgn
 05-DEC-2013 13:28:14



USER NAME - mgarvide	DESIGNED - RDP	REVISED - 6/18/2013
PLOT SCALE - 1/8"=1'-0"	DRAWN - MG/WC	REVISED - 8/22/2013
PLOT DATE - 05-DEC-2013 13:21	CHECKED - KGP	REVISED - 10/18/2013
	DATE - 8/22/2013	REVISED - 12/04/2013

STATE OF ILLINOIS
DEPARTMENT OF TRANSPORTATION

STUENKEL ROAD OVER I-57
REMOVAL LIGHTING PLANS STUENKEL RD AT CENTRAL AVE.

SCALE: AS NOTED SHEET NO. 22 OF 24 SHEETS STA. ----- TO STA. -----

F.A.I. RTE. 57	SECTION 99-1HB-R	COUNTY WILL	TOTAL SHEETS 679	SHEET NO. 340
			CONTRACT NO. 60L69	
ILLINOIS FED. AID PROJECT				