


PLAN	SURVEYED	BY	DATE
	PLOTTED		
	GRADES CHECKED		
	STRUCTURE NOTATIONS CHECKED		
	NOTE BOOK NO.		
	CADD FILE NAME		



PROFILE	SURVEYED	BY	DATE
	PLOTTED		
	GRADES CHECKED		
	STRUCTURE NOTATIONS CHECKED		
	NOTE BOOK NO.		
	CADD FILE NAME		

MATCH LINE STA. 297+40
SEE SHEET NO. 58

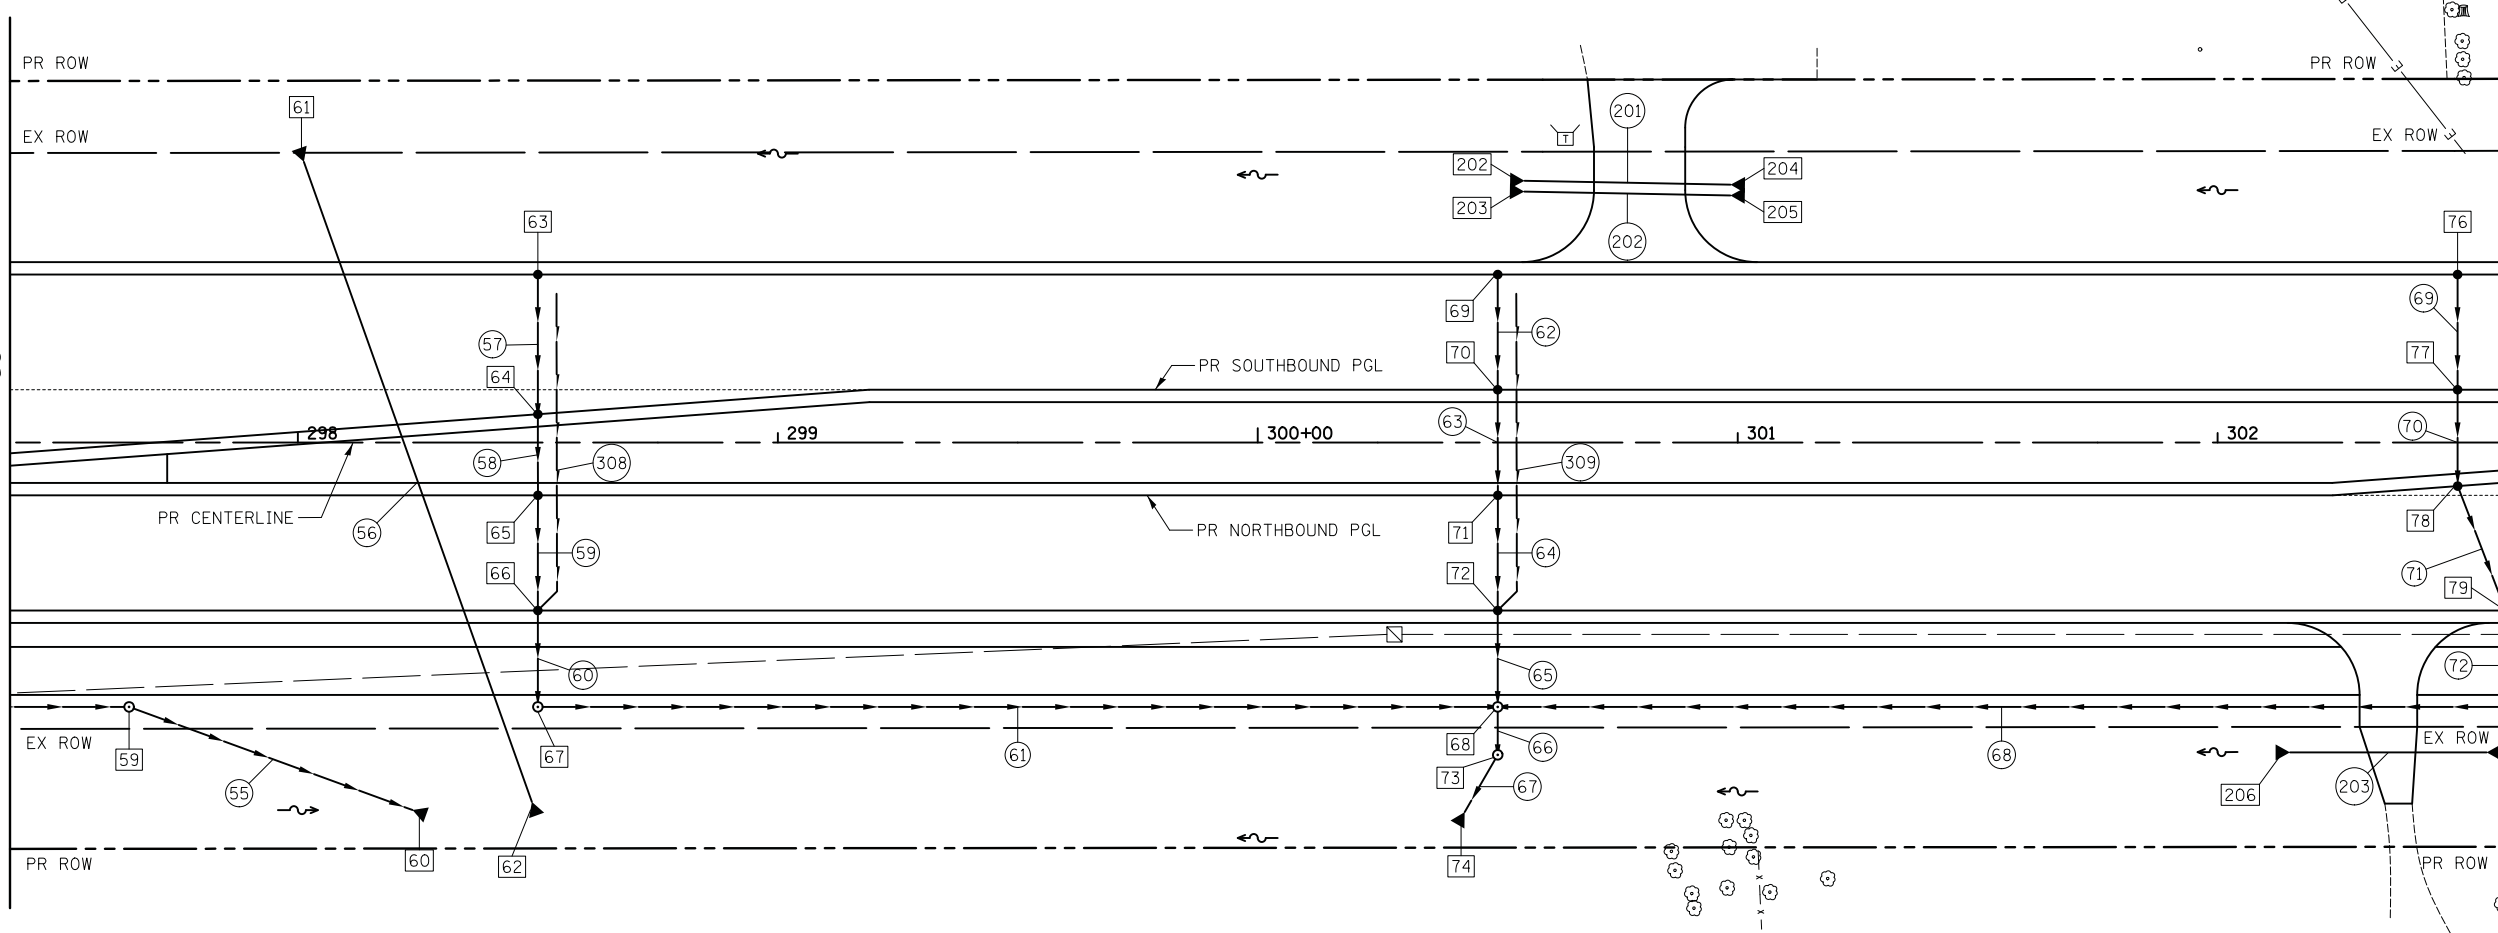

MATCH LINE STA. 302+60
SEE SHEET NO. 60

 ILLINOIS ROUTE 31

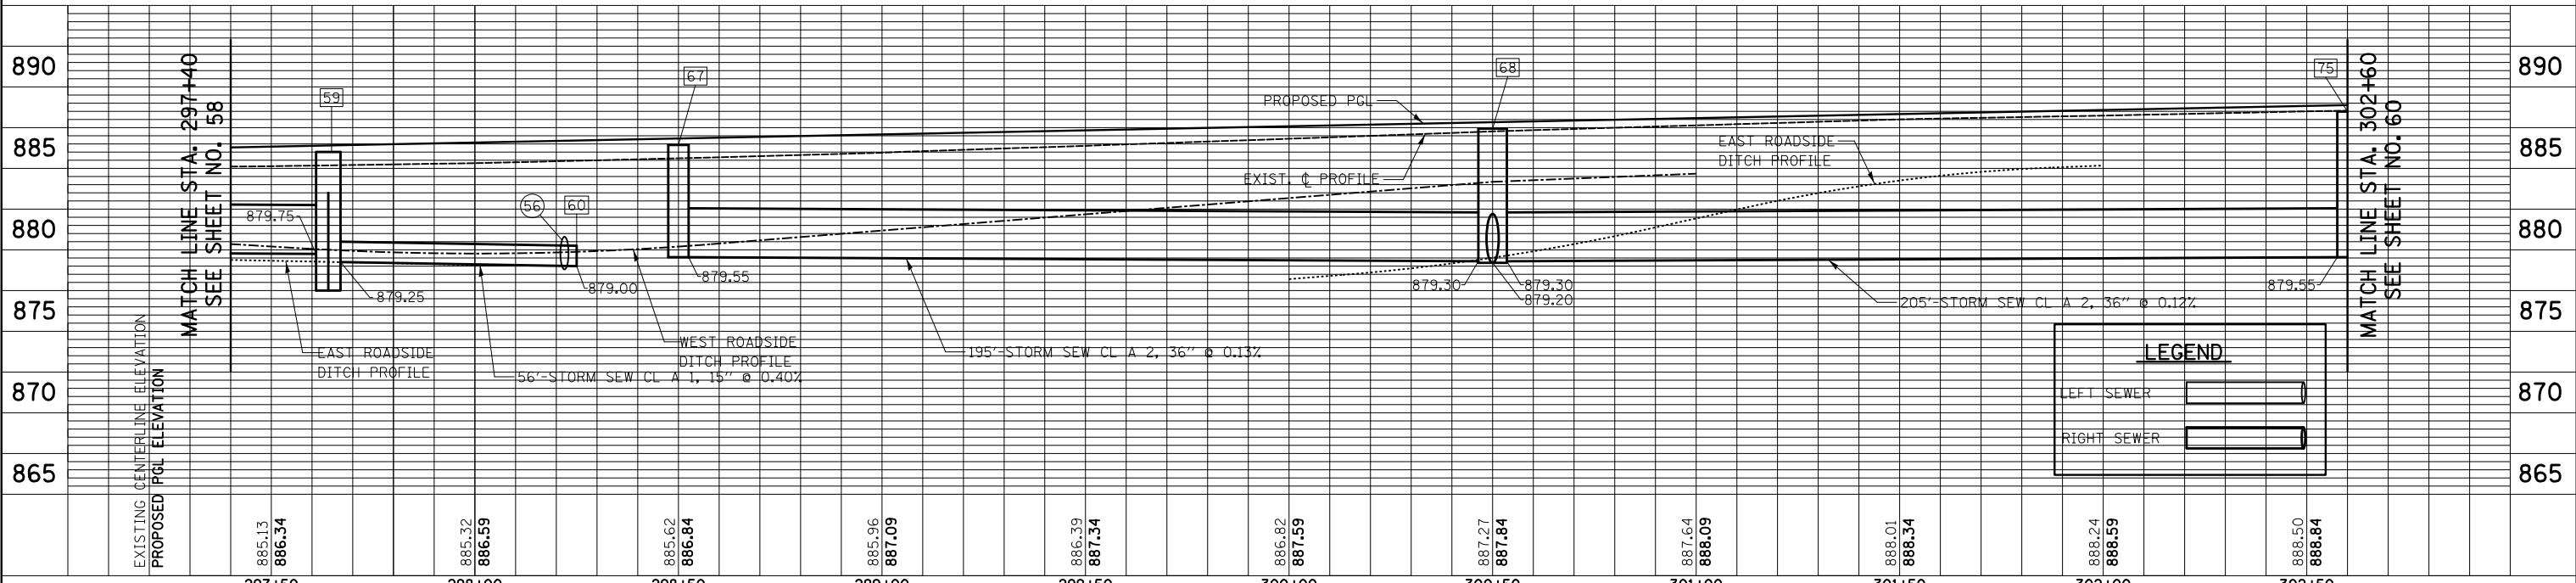

LEGEND	
LEFT SEWER	[Symbol]
RIGHT SEWER	[Symbol]

FILE NAME = ...\\2278NG_D&U_06.dgn	USER NAME = kwh	DESIGNED - KWH	REVISED -	STATE OF ILLINOIS DEPARTMENT OF TRANSPORTATION	DRAINAGE AND UTILITY PLAN	F.A.U. RTE. 3887	SECTION 18W&RS-5 (12)	COUNTY McHENRY	TOTAL SHEETS 151	SHEET NO. 59
PLOT SCALE = 20.0000' / in.	CHECKED - GAB	REVISOR -	REVISOR -			SCALE: 1" = 20'	SHEET NO. 6 OF 13 SHEETS	STA. 271+40 TO STA. 276+60	CONTRACT NO. 60V72	
PLOT DATE = 8/5/2013	DATE - 06/24/2013	REVISOR -	REVISOR -			FED. ROAD DIST. NO. 1 ILLINOIS FED. AID PROJECT				