

SHEET INDEX

GENERAL

G-001 SHEET INDEX
G-002 CODE MATRIX

STRUCTURAL

S-001 GENERAL NOTES
S-002 GENERAL NOTES, ABBREVIATIONS AND SYMBOLS
S-003 DRILLED SHAFT AND PILE CAP DETAILS
S-004 PARTIAL FOUNDATION AND PLATFORM DEMO PLANS
S-005 PLATFORM CANOPY DEMO PLAN
S-006 PLATFORM SHORING SECTIONS
S-007 STATION SHORING PLAN
S-008 STATION SHORING BUILDING SECTION
S-009 SHORING DETAILS
S-100 PARTIAL PLATFORM FOUNDATION PLAN
S-110 PARTIAL PLATFORM FRAMING PLAN
S-120 PARTIAL PLATFORM CANOPY FRAMING PLAN
S-130 STATION FRAMING PLAN
S-140 STATION ROOF FRAMING PLAN
S-200 ELEVATOR SHAFT SECTIONS
S-300 FOUNDATION SECTIONS AND DETAILS
S-301 FOUNDATION SECTIONS AND DETAILS
S-302 FOUNDATION SECTIONS AND DETAILS
S-500 STATION FLOOR SECTIONS AND DETAILS
S-501 STATION FLOOR SECTIONS AND DETAILS
S-502 STATION ROOF SECTIONS AND DETAILS
S-600 SCHEDULES AND DETAILS

ARCHITECTURAL

AD-001 DEMOLITION GENERAL NOTES
AD-100 DEMOLITION OVERALL PLATFORM FLOOR PLAN
AD-101 DEMOLITION PLATFORM FLOOR PLAN
AD-120 DEMOLITION STATION FLOOR PLAN
AD-121 DEMOLITION STATION REFLECTED CEILING PLAN
AD-130 DEMOLITION STATION ROOF PLAN
AD-200 DEMOLITION STATION ELEVATION
AD-201 DEMOLITION STATION ELEVATION
AD-202 DEMOLITION STATION ELEVATIONS
AD-300 DEMOLITION STATION SECTION
AD-301 DEMOLITION STATION SECTION
AD-302 DEMOLITION STATION SECTIONS
AD-700 INTENTIONALLY LEFT BLANK
A-001 GENERAL NOTES & PARTITION TYPES
A-002 ARCHITECTURAL SITE PLAN
A-100 OVERALL PLATFORM FLOOR PLAN
A-101 PARTIAL PLATFORM FLOOR PLAN
A-120 STATION FLOOR PLAN
A-121 STATION REFLECTED CEILING PLAN
A-130 STATION ROOF PLAN
A-200 STATION ELEVATION
A-201 STATION ELEVATION
A-202 STATION ELEVATIONS
A-300 STATION SECTION
A-301 STATION SECTION
A-302 STATION SECTIONS
A-400 ENLARGED RESTROOM AND AGENT KIOSK PLANS AND DETAILS
A-401 STATION INTERIOR ELEVATIONS
A-500 WEST STAIR DETAILS
A-501 ENLARGED ELEVATOR AND MACHINE ROOM PLANS
A-502 ENLARGED ELEVATOR AND MACHINE ROOM PLANS
A-503 EXTERIOR ELEVATOR ELEVATIONS
A-504 EXTERIOR ELEVATOR ELEVATIONS
A-505 ELEVATOR AND MACHINE ROOM SECTIONS
A-506 ELEVATOR AND MACHINE ROOM SECTIONS
A-510 ELEVATOR AND MACHINE ROOM SECTIONS
A-511 INTENTIONALLY LEFT BLANK
A-600 STATION DETAILS
A-601 STATION DETAILS
A-602 STATION DETAILS
A-603 STATION DETAILS
A-604 STATION DETAILS
A-605 STATION DETAILS
A-606 STATION DETAILS
A-607 STATION DETAILS
A-608 STATION DETAILS
A-609 STATION DETAILS

SHEET INDEX CONT.

ARCHITECTURAL

A-610 STATION DETAILS
A-611 STATION DETAILS
A-612 WINDOW, DOORS, LOUVER SCHEDULE
A-620 TACTILE PANEL PLAN, SECTION AND DETAILS
A-700 STATION SIGNAGE FLOOR PLAN
A-701 INTENTIONALLY LEFT BLANK
A-702 STATION SIGNAGE SCHEDULE
A-703 STATION SIGNAGE MOUNTING DETAILS
A-704 ELEVATOR CONTROL DETAILS
A-705 INTENTIONALLY LEFT BLANK
A-706 INTENTIONALLY LEFT BLANK

MECHANICAL

M-001 MECHANICAL STATION HOUSE & PARTIAL PLATFORM PLAN
M-002 DETAILS, NOTES AND SYMBOL LIST
M-003 MECHANICAL ELEVATOR ELEVATION

PLUMBING

P-001 PLUMBING STATION HOUSE & PARTIAL PLATFORM PLANS
P-002 PLUMBING NOTES, DIAGRAMS AND SYMBOL LIST
P-003 PLUMBING ELEVATOR ELEVATION
P-004 PLUMBING DETAILS

ELECTRICAL

E-001 ELECTRICAL SYMBOLS, ABBREVIATIONS AND NOTES
E-101 ELECTRICAL PLATFORM LEVEL POWER PLAN
E-102 ELECTRICAL PLATFORM LEVEL POWER PLAN
E-120 ELECTRICAL STATION HOUSE POWER PLAN
E-121 ELECTRICAL STATION HOUSE LIGHTING PLAN
E-122 ELECTRICAL REMOTE KIOSK PANEL
E-130 ELECTRICAL BRIDGE PLAN
E-200 ELECTRICAL SINGLE LINE DIAGRAM
E-201 ELECTRICAL PANEL SCHEDULES
E-202 ELECTRICAL LIGHTING FIXTURE SCHEDULES
E-203 ELECTRICAL CABLE/CONDUIT SCHEDULE PART 1
E-204 ELECTRICAL CABLE/CONDUIT SCHEDULE PART 2
E-205 ELECTRICAL INTERFACE TERMINAL CABINET & ALARM RELAY PANEL RCP
E-206 CONTROL DIAGRAMS ITC AND RCP PANELS
E-207 ELECTRICAL HEAT TRACE FREEZE PROTECTION PANEL (HTC-1)
E-208 ELECTRICAL CONTROL DIAGRAM HEAT TRACING PART 1
E-209 ELECTRICAL CONTROL DIAGRAM HEAT TRACING PART 2
E-210 ELECTRICAL CONTROL DIAGRAMS PART 1
E-211 ELECTRICAL CONTROL DIAGRAMS PART 2
E-212 ELECTRICAL CONTROL DIAGRAMS PART 3
E-213 ELECTRICAL BLOCK DIAGRAMS
E-214 ELECTRICAL DETAILS
E-300 CITY LOAD CALCS AND EXIT LTG CATALOG CUT
E-301 COMMUNICATION SYMBOLS, CONDUIT AND CABLE LEGENDS AND ABBREVIATIONS


COMMUNICATION

T-001 COMMUNICATION SYMBOLS, CONDUIT AND CABLE LEGENDS AND ABBREVIATIONS
T-002 COMMUNICATION GENERAL NOTES
T-110 COMMUNICATION PLATFORM LEVEL PLAN
T-111 COMMUNICATION PLATFORM LEVEL CENTER EQUIPMENT PLAN
T-112 COMMUNICATION PLATFORM LEVEL CENTER TO EAST EQUIPMENT PLAN
T-113 COMMUNICATION PLATFORM LEVEL EAST EQUIPMENT PLAN
T-120 COMMUNICATION STATION LEVEL EQUIPMENT PLAN
T-200 COMMUNICATIONS TELEPHONE SYSTEM BLOCK DIAGRAM
T-201 COMMUNICATION EXISTING EQUIPMENT WIRING DIAGRAM
T-300 COMMUNICATION EXISTING HUB DETAILS PART 1
T-301 COMMUNICATION EXISTING HUB DETAILS PART 2
T-302 COMMUNICATION EXISTING HUB DETAILS PART 3
T-303 COMMUNICATION STANDARD DETAILS COMMUNICATION HUB
T-304 COMMUNICATION CCTV CAMERA DETAILS
T-400 COMMUNICATION EQUIPMENT WIRING REQUIREMENT SCHEDULE
T-401 COMMUNICATION EQUIPMENT SCHEDULE PART 1
T-402 COMMUNICATION EQUIPMENT SCHEDULE PART 2

ABBREVIATIONS

#	POUND OR NUMBER	PLUMB	PLUMBING
&	AND	PLYD	PLYWOOD
@	AT	PT	PAINT OR PAINTED
ACT	ACOUSTIC CEILING TILE	PVC	POLYVINYL CHLORIDE
AFF	ABOVE FINISHED FLOOR	RBR	RUBBER
ALUM	ALUMINUM	RCP	REFLECTED CEILING PLAN
ANOD	ANODIZED	RD	ROOF DRAIN
BYND	BEYOND	REQD	REQUIRED
BOT	BOTTOM	RM	ROOM
CHNL	CHANNEL	SIM	SIMILAR
CJ	CONTROL JOINT	SPEC	SPECIFIED OR SPECIFICATION
CLG	CEILING	SSTL	STAINLESS STEEL
CLR	CLEAR	STL	STEEL
CMU	CONCRETE MASONRY UNIT	STRUCT	STRUCTURE OR STRUCTURAL
COL	COLUMN	TELE	TELEPHONE
COM	PRCOMPRESSIBLE	TLT	TOILET
CON	CONCRETE	TO	TOP OF
CONT	CONTINUOUS	TOC	TOP OF CONCRETE
CT	CERAMIC TILE	TOS	TOP OF STEEL
CTYD	COURTYARD	TYP	TYPICAL
DBL	DOUBLE	UNO	UNLESS NOTED OTHERWISE
DEMO	DEMOLISH OR DEMOLITION	VIF	VERIFY IN FIELD
DIA	DIAMETER	W/	WITH
DIM	DIMENSION		
DIMS	DIMENSIONS		
DN	DOWN		
DR	DOOR		
DWG	DRAWING		
EA	EACH		
EJ	EXPANSION JOINT		
EL	ELEVATION		
ELEC	ELECTRICAL		
EL	ELEVATOR OR ELEVATION		
EPDM	ETHYLENE PROPYLENE DIENE M-CLASS (ROOFING)		
EQ	EQUAL		
EXIST	EXISTING		
EXP JT	EXPANSION JOINT		
EXT	EXTERIOR		
FD	FLOOR DRAIN OR FIRE DEPARTMENT		
FIXT	FIXTURE		
FLR	FLOOR		
FO	FACE OF		
FND	FOUNDATION		
GA	GAUGE		
GALV	GALVANIZED		
GWB	GYPSUM WALL BOARD		
HM	HOLLOW METAL		
HP	HIGH POINT		
HR	HOUR		
HVAC	HEATING, VENTILATING, AND AIR CONDITIONING		
IRGWB	IMPACT RESISTANT GYPSUM WALL BOARD		
ILO	IN LIEU OF		
INSUL	INSULATED OR INSULATION		
INT	INTERIOR		
MAX	MAXIMUM		
MECH	MECHANICAL		
MIN	MINIMUM		
MTL	METAL		
NIC	NOT IN CONTRACT		
NO	NUMBER		
NOM	NOMINAL		
OC	ON CENTER		
OH	OPPOSITE HAND		

LEGEND

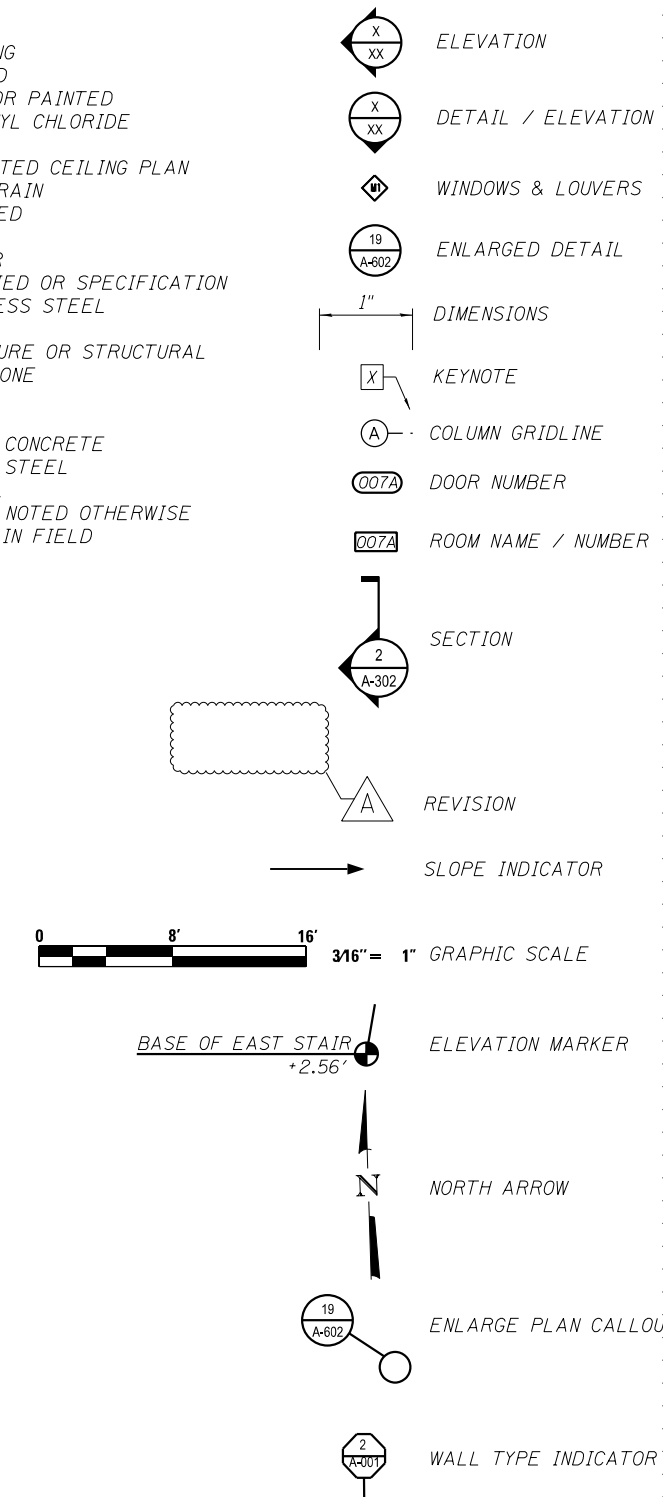

0 8' 16' 3/16" = 1" GRAPHIC SCALE

BASE OF EAST STAIR +2.56'

4/31/12 PM 0161708-60W29-g-001.dgn



USER NAME = whbruce	DESIGNED - WHB	REVISED 1/20/2014
	CHECKED - CRR	REVISED
PLOT SCALE = 2:0.0000 ins/in / in.	DRAWN - WHB	REVISED
PLOT DATE = 1/20/2014	CHECKED - CRR	REVISED

STATE OF ILLINOIS
DEPARTMENT OF TRANSPORTATION

PEORIA STREET STATION
SHEET INDEX

SHEET NO. G-001 OF 117 SHEETS

MUN	SECTION	COUNTY	TOTAL SHEETS	SHEET NO.
2090	2013-011R	COOK	356	191A
CONTRACT NO.			60W29	
ILLINOIS FED. AID PROJECT FED. AID PROJECT				