


NOTES:

1. REFER TO PEORIA ST. BRIDGE PLANS OVER FA1290 (SN 016-1708) SHEETS NO. 133 TO 187. ELECTRICAL DRAWINGS FOR NEW DUCT LOCATIONS AND ROUTING ON BRIDGE BACK TO COMED ATT SERVICE POINTS.
2. EXISTING TELEPHONE SERVICE CONDUIT (2") AND CABLE DOWN TO PLATFORM TO BE REMOVED PROVIDE TEMPORARY TELEPHONE SERVICE TO PLATFORM TELEPHONE CABINET DURING CONSTRUCTION. REFER TO SHEET 295 FOR TELEPHONE CABINET LOCATION.
3. NEW COMED ELECTRICAL SERVICE ATTACHED TO STRUCTURE. SEE SINGLE LINE DIAGRAM ON SHEET 276.
4. PROVIDE TEMPORARY POWER AS NEEDED FOR CONSTRUCTION.
5. EXISTING ATT TELEPHONE UTILITY MANHOLE.
6. UP TO UIC TELEPHONE IN STATION HOUSE. REFER TO SHEET 298 FOR LOCATION OF TELEPHONE.
7. RACEWAY ATTACHED TO STRUCTURE.

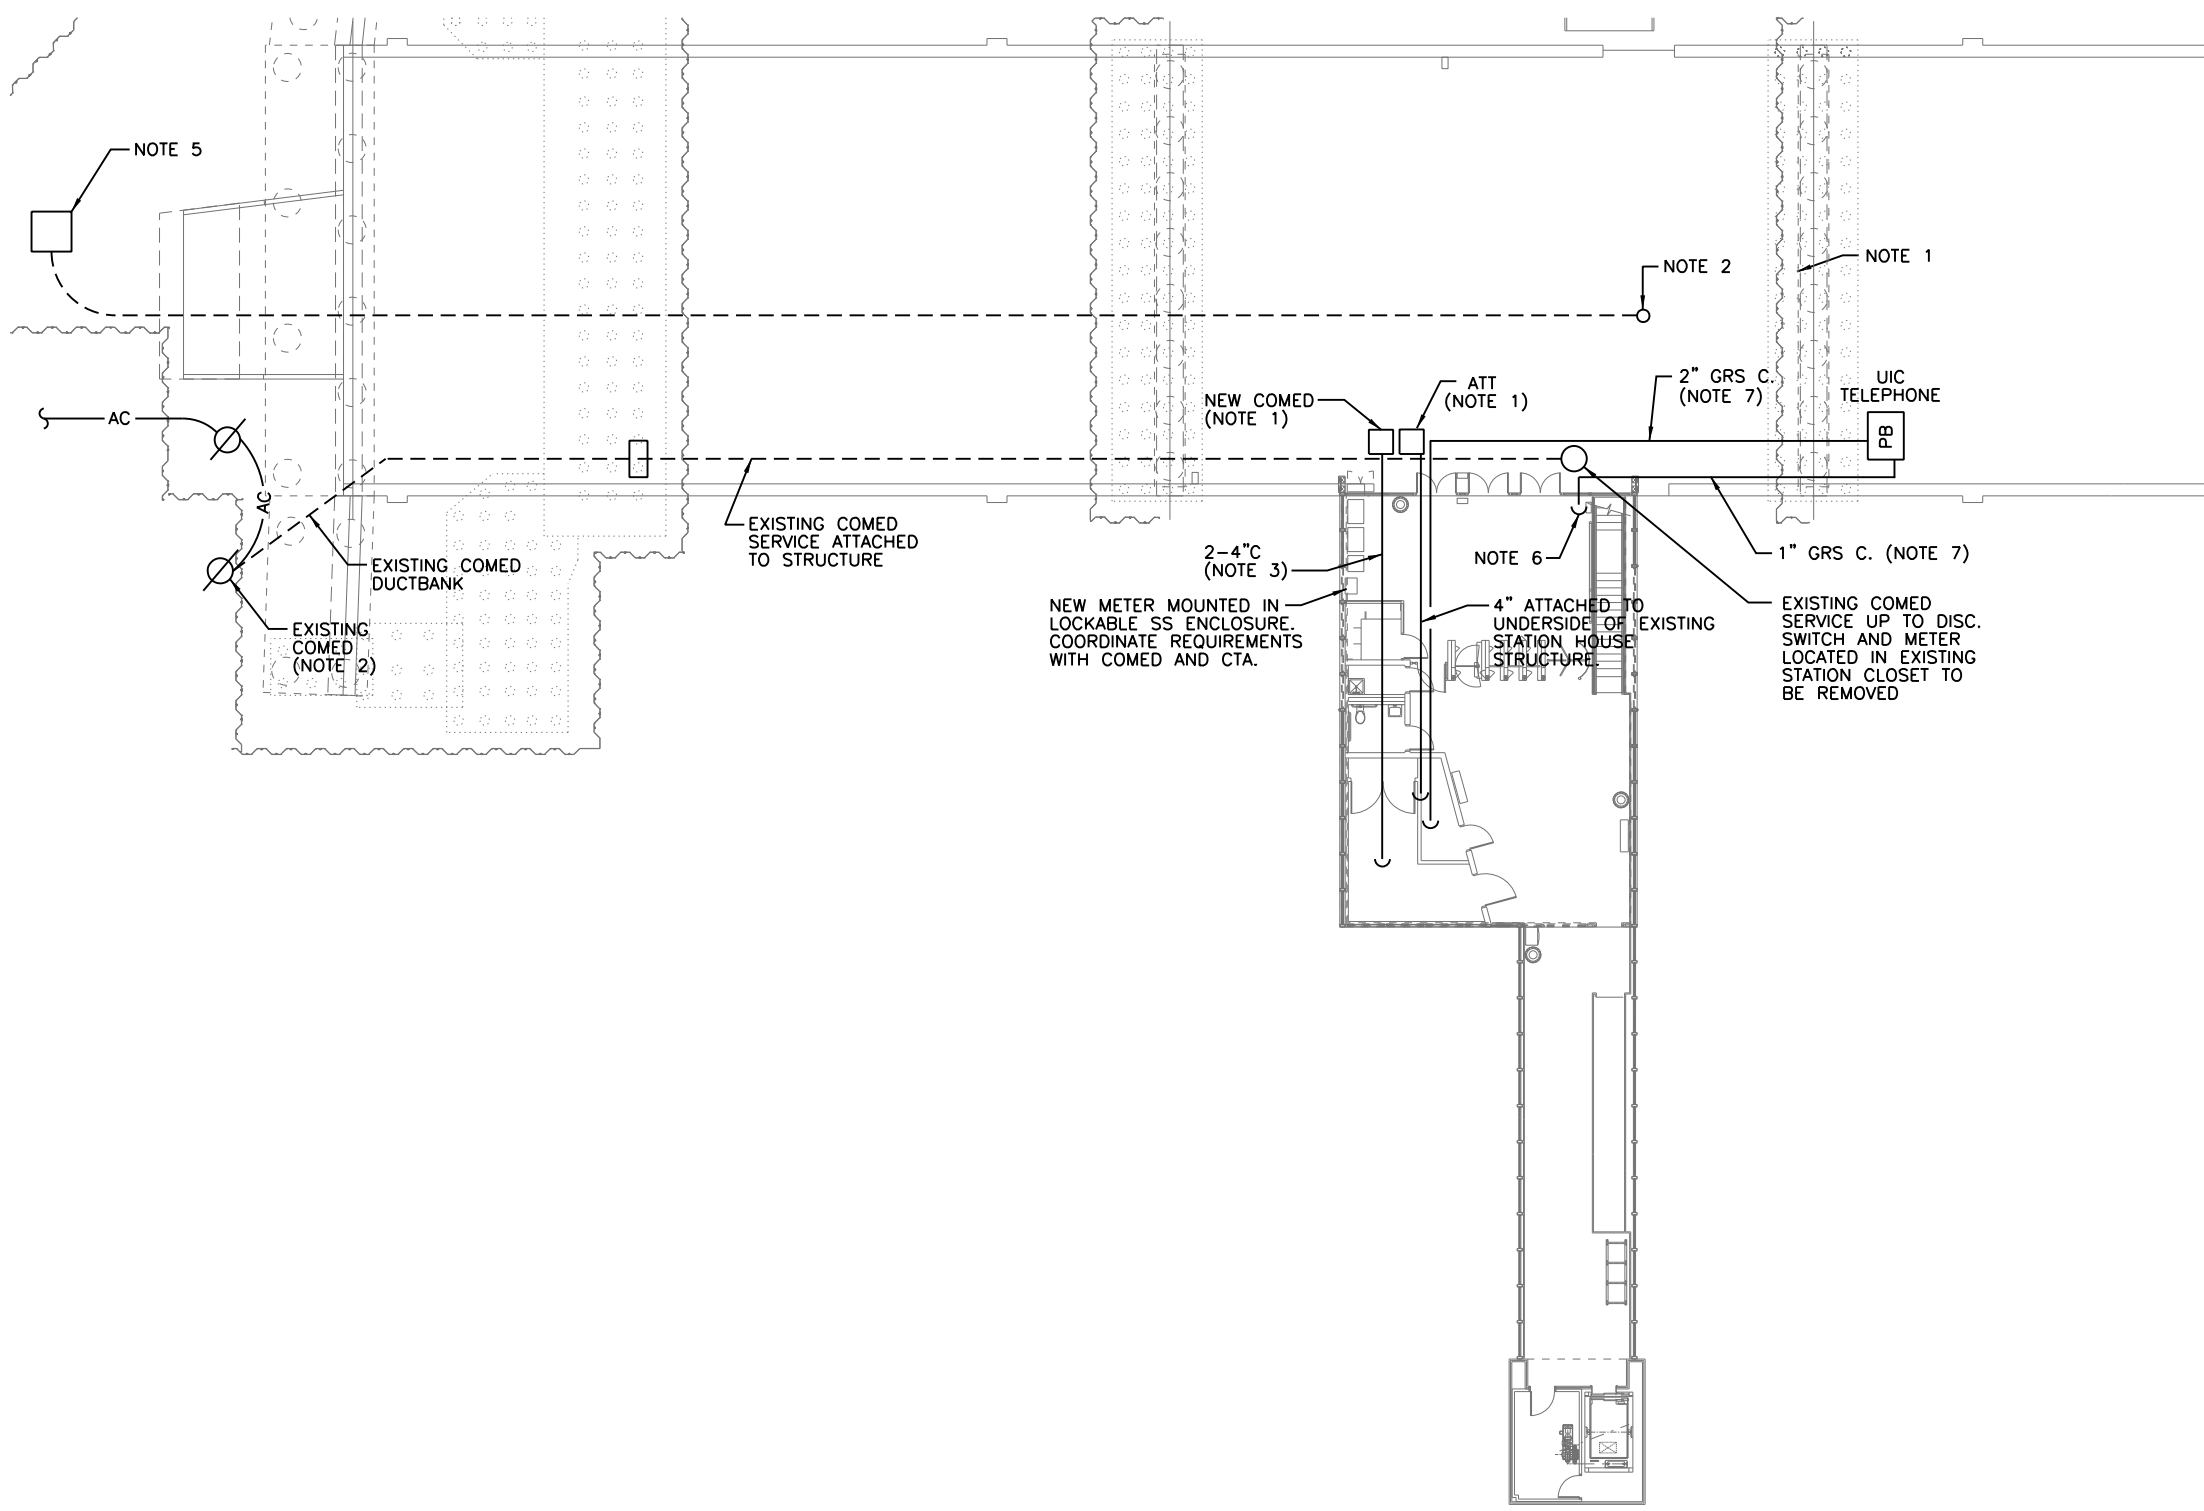

1 ELECTRICAL BRIDGE PLAN
 SCALE: 1" = 1'-0"

AAA ENGINEERING
 WBE/DBE CERTIFIED
 5940 West Touhy Avenue, Suite 210, Niles, IL 60714
 Phone: 847-647-9300 • Fax: 847-647-4710



USER NAME = habib	DESIGNED JCM	REVISED 1/20/2014
	CHECKED OS	REVISED
PLOT SCALE = 24:0 "/>		

STATE OF ILLINOIS
DEPARTMENT OF TRANSPORTATION

PEORIA STREET STATION
ELECTRICAL BRIDGE PLAN

SHEET NO. E-130 OF 117 SHEETS

MUN	SECTION	COUNTY	TOTAL SHEETS	SHEET NO.
2090	2013-011R	COOK	356	275
CONTRACT NO.			60W29	

ILLINOIS FED. AID PROJECT

1/21/14 5:55 AM 60W29-275.dgn