



NOTES:

- DASHED LINES INDICATE FIELD WIRING.
- PANEL ALARM OUTPUT CONTACTS SHOWN IN ALARM MODE.
NORMAL:
ALARM: R3 ENERGIZED
R3 DE-ENERGIZED

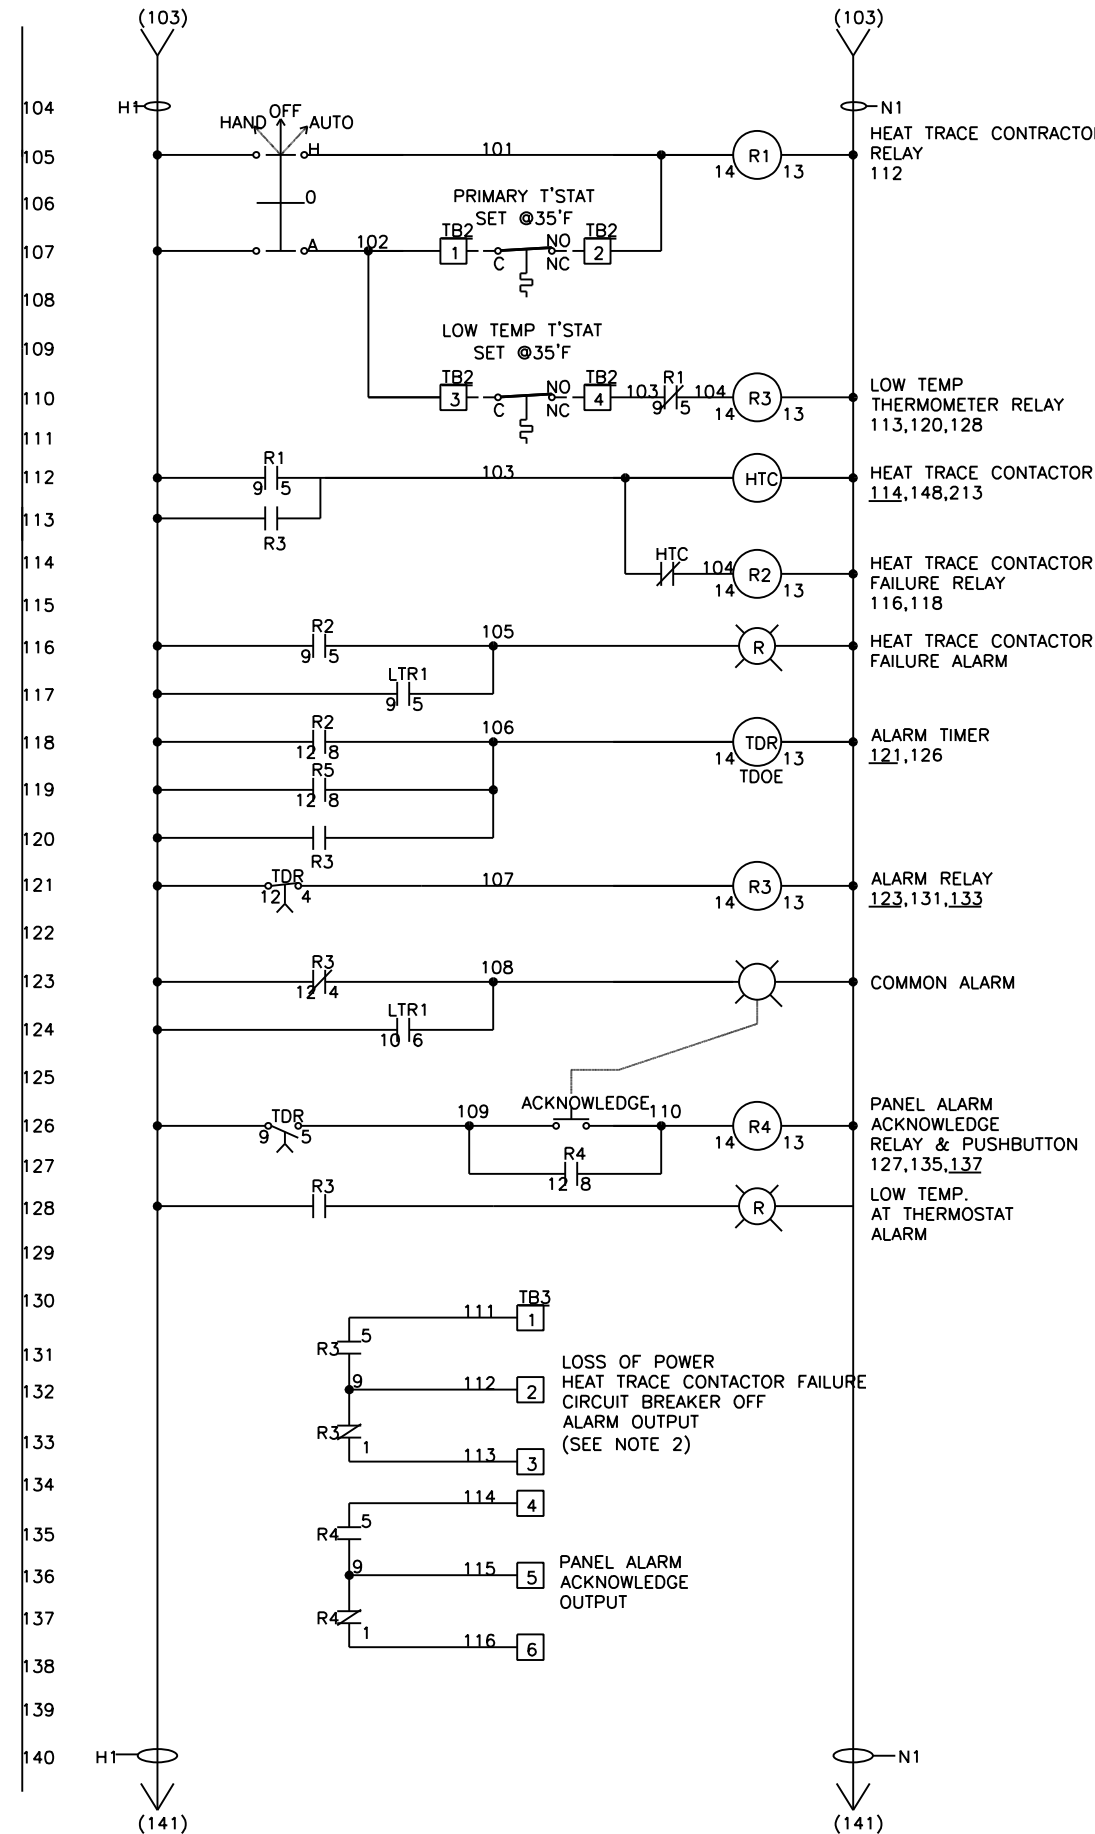

5940 West Touhy Avenue, Suite 210, Niles, IL 60714
Phone: 847-647-9300 • Fax: 847-647-4710

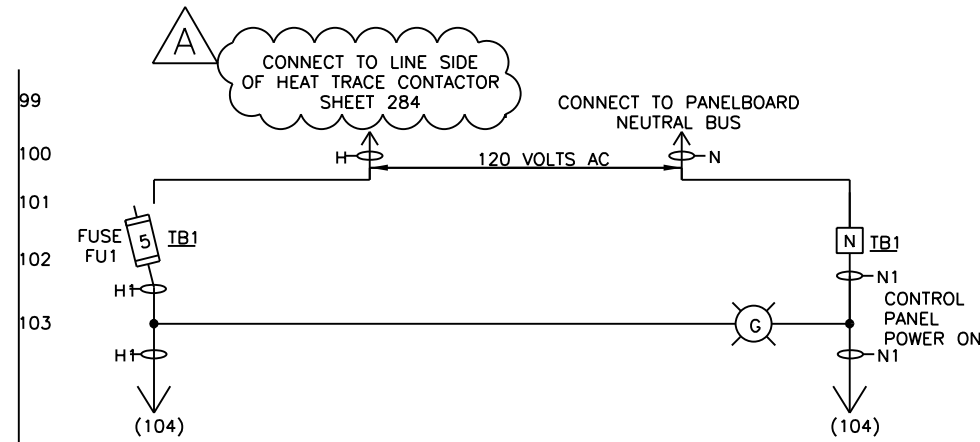

USER NAME = habib	DESIGNED JCM	REVISED 1/20/2014
CHECKED OS	DRAWN HR	REVISED
PLOT SCALE = 0.2" = 1' in.	CHECKED BC	REVISED
PLOT DATE = 1/21/2014		

**STATE OF ILLINOIS
DEPARTMENT OF TRANSPORTATION**

**PEORIA STREET STATION
ELECTRICAL CONTROL DIAGRAM HEAT TRACING PART 2**

SHEET NO. E-209 OF 117 SHEETS

MUN 2090	SECTION 2013-011R	COUNTY COOK	TOTAL SHEETS 356	SHEET NO. 285
CONTRACT NO. 60W29				

ILLINOIS FED. AID PROJECT

11:05:58 AM 6/01/2014 285.dgn