


NOTES:

1. FURNISH AND INSTALL CAT6 TO RG6/V COAX CONVERTER BOX.

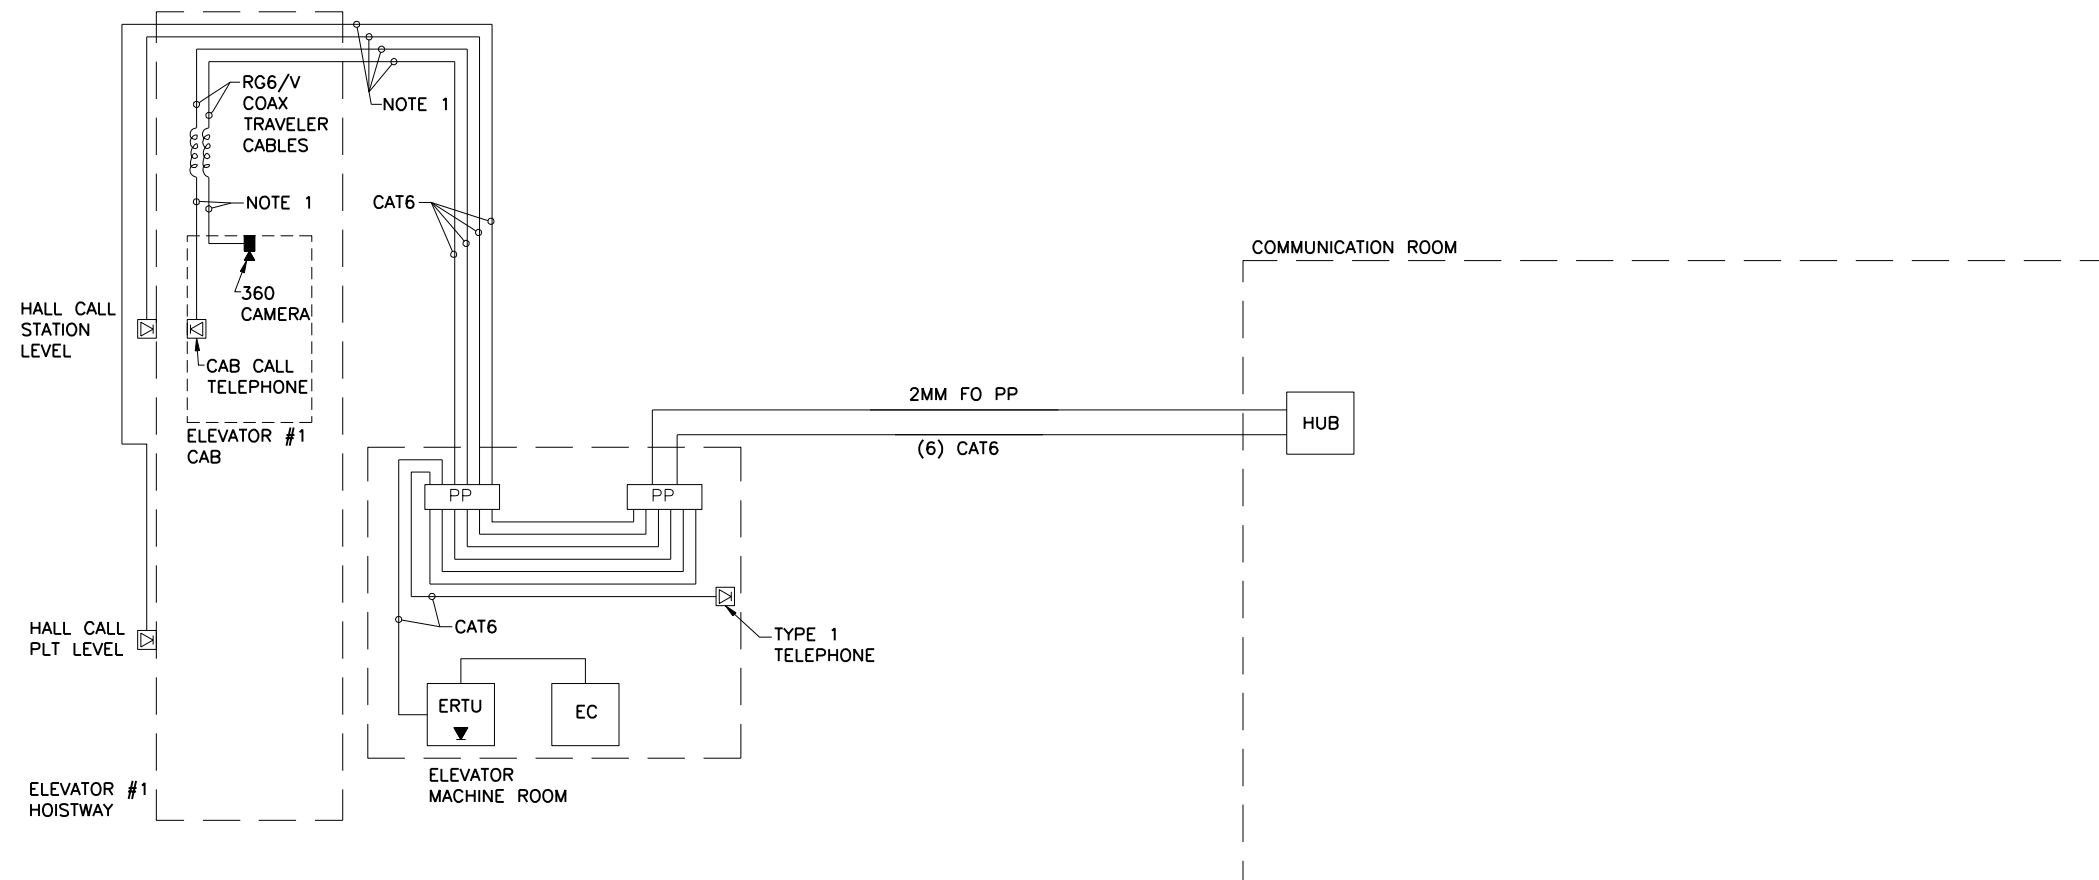

1 ELEVATOR SYSTEM ONE LINE DIAGRAM

A

USER NAME = habib	DESIGNED -	REVISED 12/18/2013
	CHECKED -	REVISED
PLOT SCALE = 2.0000 / in.	DRAWN -	REVISED
PLOT DATE = 12/17/2013	CHECKED -	REVISED

MUN	SECTION	COUNTY	TOTAL SHEETS	SHEET NO.
2090	2013-011R	COOK	356	301
CONTRACT NO.			60W29	