


TYPE 1, SPECIAL TERMINAL BARRIER (TANGENT)	
STATION TO STATION	LOCATION
96+73.07 TO 97+23.07	RT
97+04.79 TO 97+54.79	LT
101+82.70 TO 102+32.70	RT
102+76.93 TO 103+26.93	LT

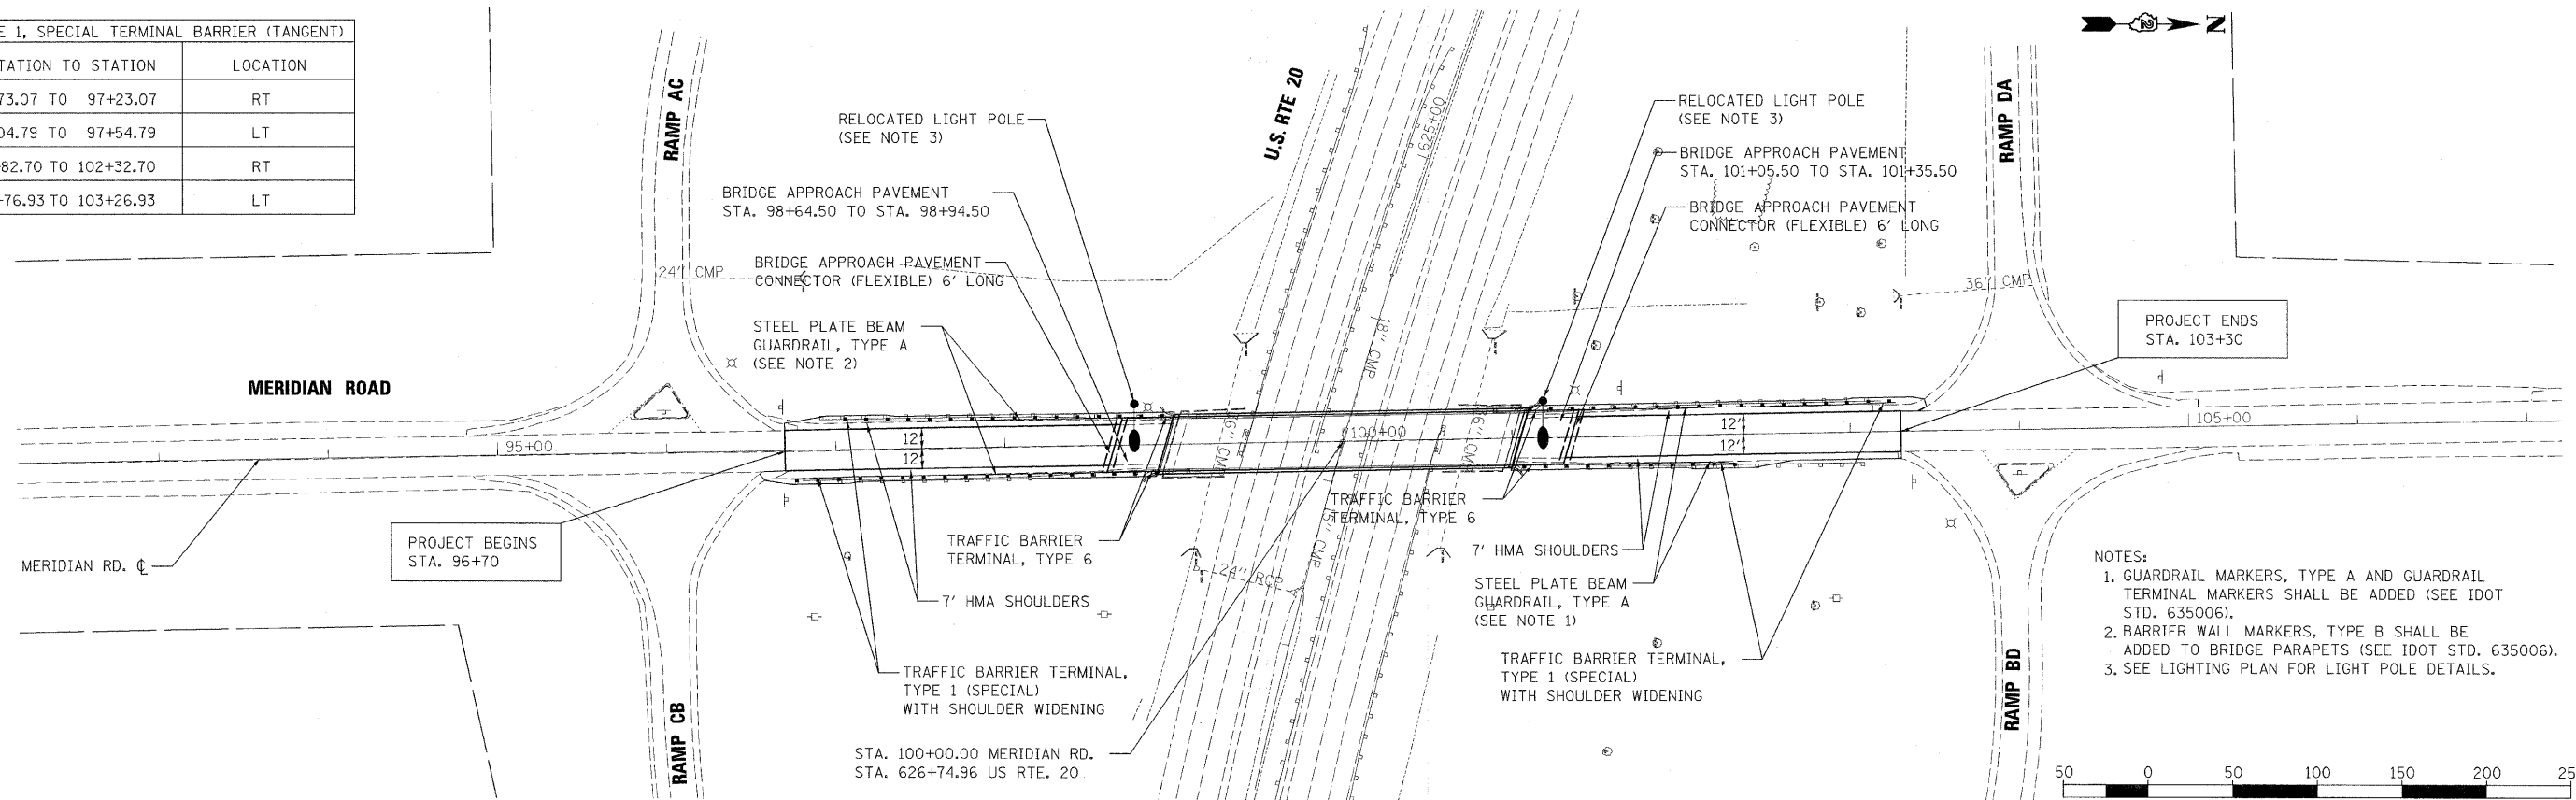


- NOTES:
- GUARDRAIL MARKERS, TYPE A AND GUARDRAIL TERMINAL MARKERS SHALL BE ADDED (SEE IDOT STD. 635006).
  - BARRIER WALL MARKERS, TYPE B SHALL BE ADDED TO BRIDGE PARAPETS (SEE IDOT STD. 635006).
  - SEE LIGHTING PLAN FOR LIGHT POLE DETAILS.

STEEL PLATE GUARDRAIL, TYPE A			
STATION TO STATION	LOCATION	LENGTH (LF)	
97+23.07 TO 98+48.07	RT	125.00	
97+54.79 TO 98+54.79	LT	100.00	
101+45.20 TO 101+82.70	RT	37.50	
101+51.93 TO 102+76.93	LT	125.00	

TRAFFIC BARRIER TERMINAL, TYPE 6		
STATION TO STATION	LOCATION	
98+54.79 TO 99+00.44	LT	
98+48.07 TO 98+93.72	RT	
100+99.56 TO 101+45.20	RT	
101+06.28 TO 101+51.93	LT	

EARTHWORK QUANTITIES	
EARTH EXCAVATION	145 CU YD
FURNISHED EXCAVATION	1,230 CU YD

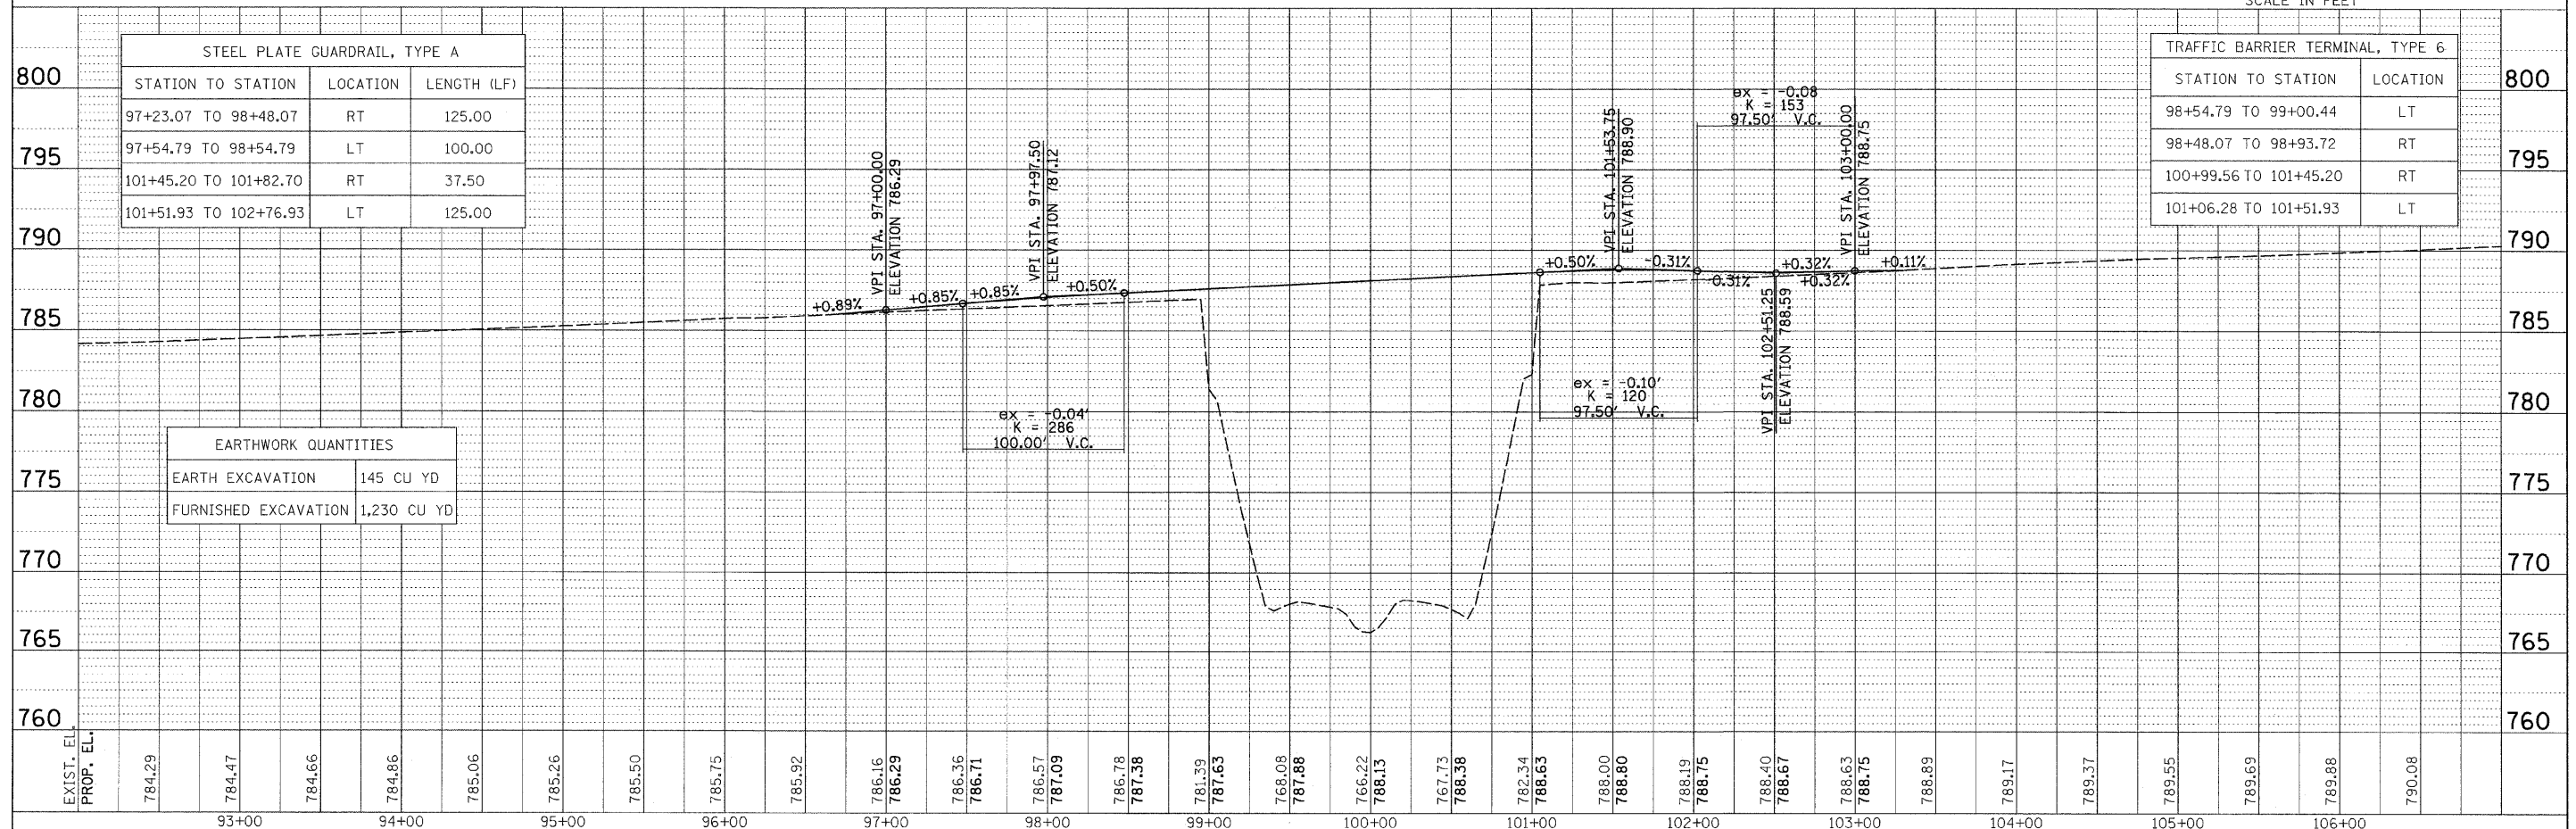

DATE: \_\_\_\_\_ BY: \_\_\_\_\_  
 PLAN SURVEYED: \_\_\_\_\_  
 PLOTTED: \_\_\_\_\_  
 NOTE BOOK NO.: \_\_\_\_\_  
 CHECKED: \_\_\_\_\_  
 STRUCTURE NOTATION: \_\_\_\_\_  
 CAD FILE NAME: \_\_\_\_\_

DATE: \_\_\_\_\_ BY: \_\_\_\_\_  
 PROFILE SURVEYED: \_\_\_\_\_  
 PLOTTED: \_\_\_\_\_  
 NOTE BOOK NO.: \_\_\_\_\_  
 CHECKED: \_\_\_\_\_  
 STRUCTURE NOTATION: \_\_\_\_\_

HOH  
 HARRY R. HOFFER-ASSOCIATES, INC.  
 5110 S. WILSON AVE., SUITE 100  
 CHICAGO, IL 60628  
 PROJECT NUMBER: 2945

FILE NAME = H:\Projects\2945\DCMS\09209507\209507.PLN.dgn	USER NAME = #USER#	DESIGNED - AAF	REVISED -	<b>STATE OF ILLINOIS DEPARTMENT OF TRANSPORTATION</b>	<b>MERIDIAN ROAD PROPOSED ROADWAY PLAN &amp; PROFILE</b>	F.A.P. RTE. 301	SECTION 1-HBR-2	COUNTY WINNEBAGO	TOTAL SHEETS 57	SHEET NO. 9		
PILOT SCALE = 5/8"=20' / 1"=40'	CHECKED - BAP	REVISOR -	REVISOR -			SCALE: 1"=50'	SHEET NO. 1 OF 1 SHEETS	STA. 96+70 TO STA. 103+30	FED. ROAD DIST. NO. ILLINOIS FED. AID PROJECT	CONTRACT NO. 64D50		
PILOT DATE = 11/13/2009	DATE = 2/02/09	REVISOR -	REVISOR -									