

STATE OF ILLINOIS
DEPARTMENT OF TRANSPORTATION
DIVISION OF HIGHWAYS

PLANS FOR PROPOSED
AMERICAN RECOVERY AND REINVESTMENT ACT PROJECT


SECTION 09-00053-00-PV CITY OF FLORA

JOB NO. C-97-027-10

PROJECT NO. M-ARA-5023(010)

WORTHY STREET - F.A.U. 8526

ROUTE	SECTION	CITY	TOTAL SHEETS	SHEET NO.
F.A.U. 8526	09-00053-00-PV	FLORA	25	1
CONTRACT NO. 95611		ILLINOIS	PROJECT M-ARA-5023(010)	

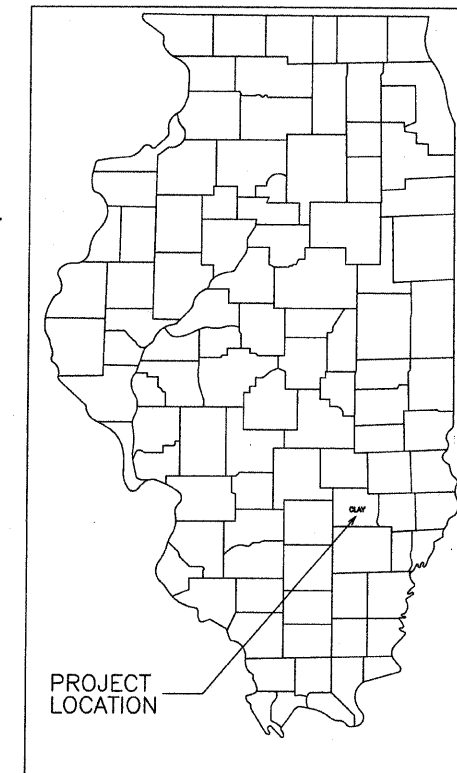


INDEX OF SHEETS

SHEET	ITEM
1	COVER SHEET
2	TYPICAL SECTIONS
3	SUMMARY OF QUANTITIES
4	DRAINAGE STRUCTURES / STORM SEWER
5-9	PLAN & PROFILE
10	INTERSECTION DETAILS
11	EROSION CONTROL
12-25	CROSS SECTIONS
	STANDARD 000001-05
	STANDARD 280001-05
	STANDARD 420001-07
	STANDARD 424001-05
	STANDARD 542301-02
	STANDARD 602301-02
	STANDARD 602306-02
	STANDARD 602401-02
	STANDARD 602406-03
	STANDARD 602601-02
	STANDARD 602701-02
	STANDARD 604001-03
	STANDARD 604006-04
	STANDARD 604036-02
	STANDARD 604086-02
	STANDARD 606001-04
	STANDARD 701006-03
	STANDARD 701301-03
	STANDARD 701311-03
	STANDARD 701501-05
	STANDARD 701901-01
	STANDARD 780001-02
	STANDARD BLR 10-6
	STANDARD BLR 21-8
	STANDARD BLR 22-6

PLAN	0' 20' 40'
PROFILE HOR.	0' 20' 40'
PROFILE VERT.	0' 5' 10'
CROSS SECTIONS	
HOR.	0' 5' 10'
VERT.	0' 5' 10'

Joint Utility Locating Information for Excavators

JULIE 1-800-892-0123

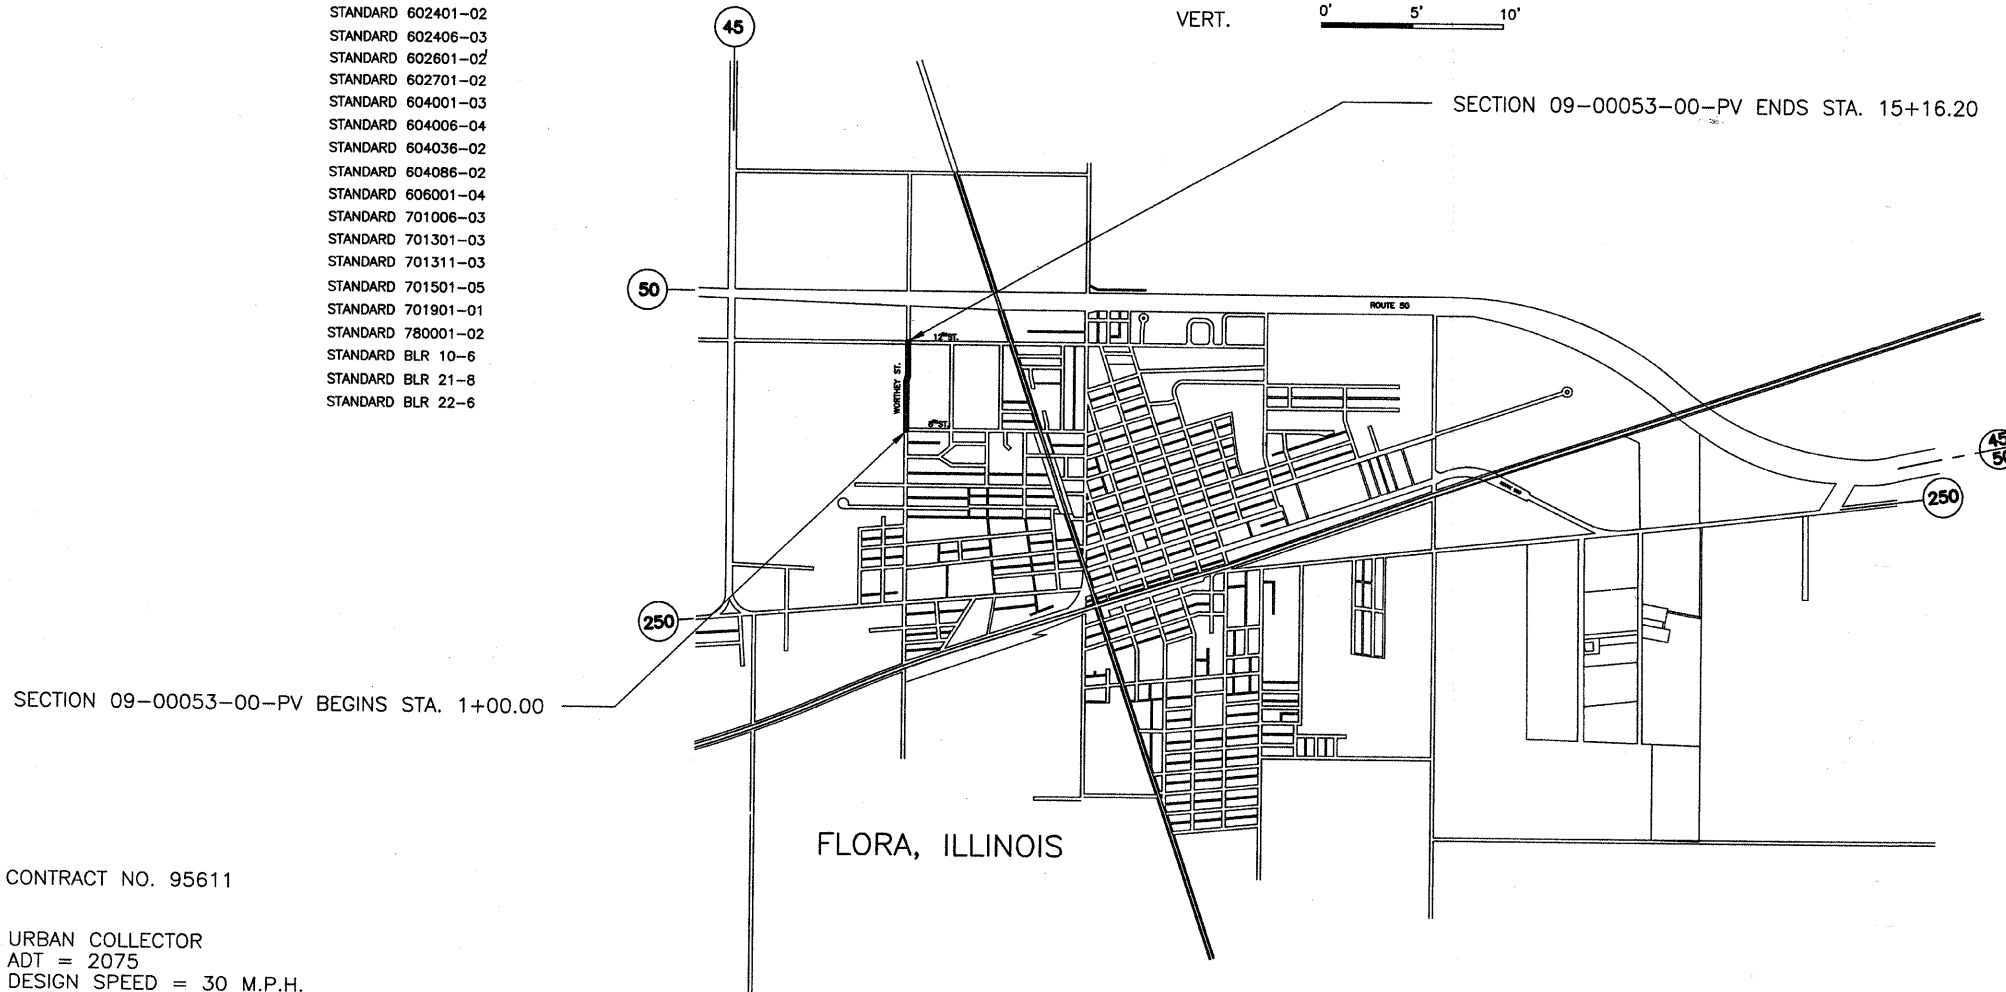

SECTION 09-00053-00-PV BEGINS STA. 1+00.00

SECTION 09-00053-00-PV ENDS STA. 15+16.20

FLORA, ILLINOIS

NET LENGTH SECTION 09-00053-00-PV = 1416.20 FEET = 0.268 MILE

CONTRACT NO. 95611

URBAN COLLECTOR
ADT = 2075
DESIGN SPEED = 30 M.P.H.

Roger A. Charleston
Ill. Reg. Prof. Eng. #29198
12/15/09
Lic. Expires 11/30/2011



CHARLESTON ENGINEERING, INC.

CONSULTING ENGINEERS

105 NORTH KITCHELL
P.O. BOX 397
OLNEY, ILLINOIS 62450
(618) 392-0736

ILLINOIS DEPARTMENT OF PROFESSIONAL REGULATION REGISTRATION #184.003513

APPROVED Nov. 15 2009
Bob Cochran
MAYOR - CITY OF FLORA

STATE OF ILLINOIS
DEPARTMENT OF TRANSPORTATION

PASSED 12-29 2009
Maurice Kestel
DISTRICT SEVEN ENGINEER OF
LOCAL ROADS AND STREETS

Releasing For
Bid Based on
Limited Review
12-29 2009
Roger A. Charleston
DEPUTY DIRECTOR OF HIGHWAYS
REGION FOUR ENGINEER