
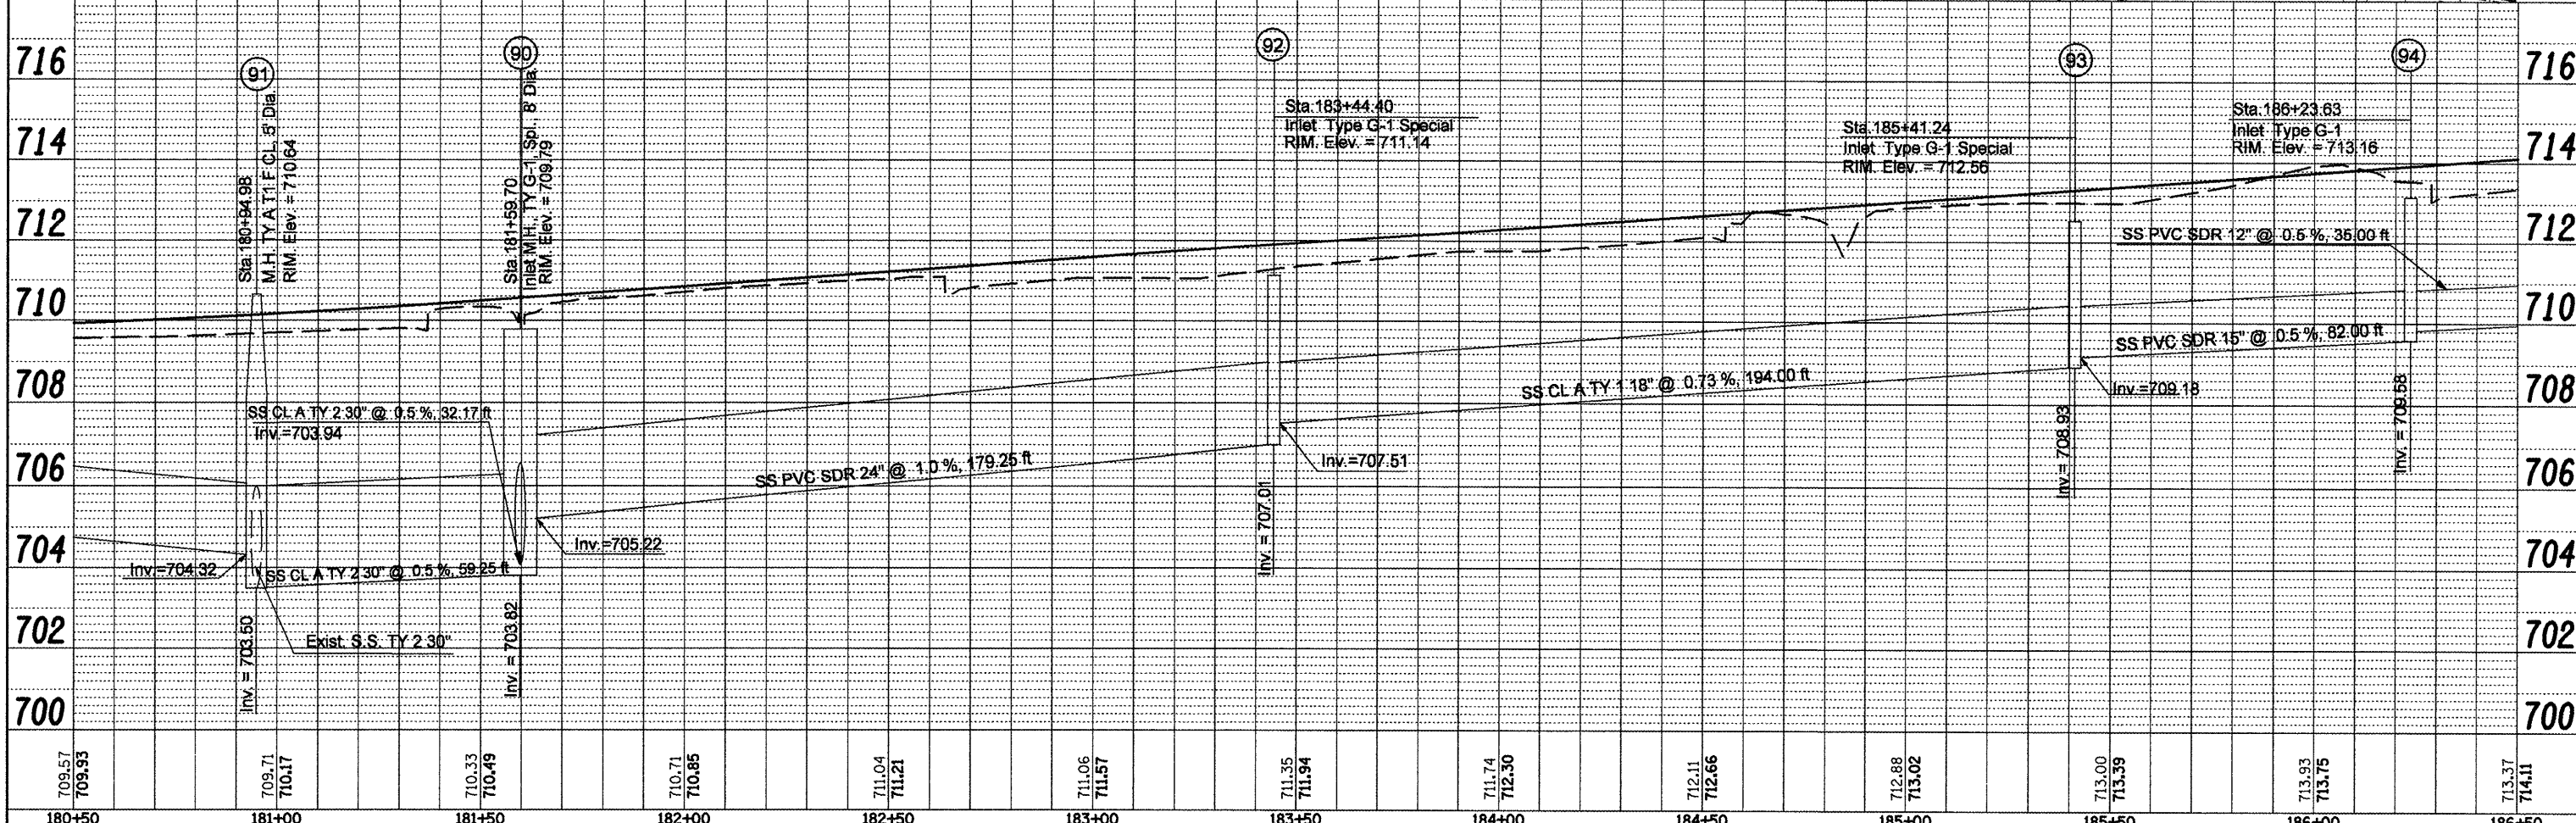


DATE	
BY	
DESIGNED	
DRAWN	
CHECKED	
DATE	
NO.	
ADD. FILE NAME	

DATE	
BY	
DESIGNED	
DRAWN	
CHECKED	
DATE	
NO.	
ADD. FILE NAME	

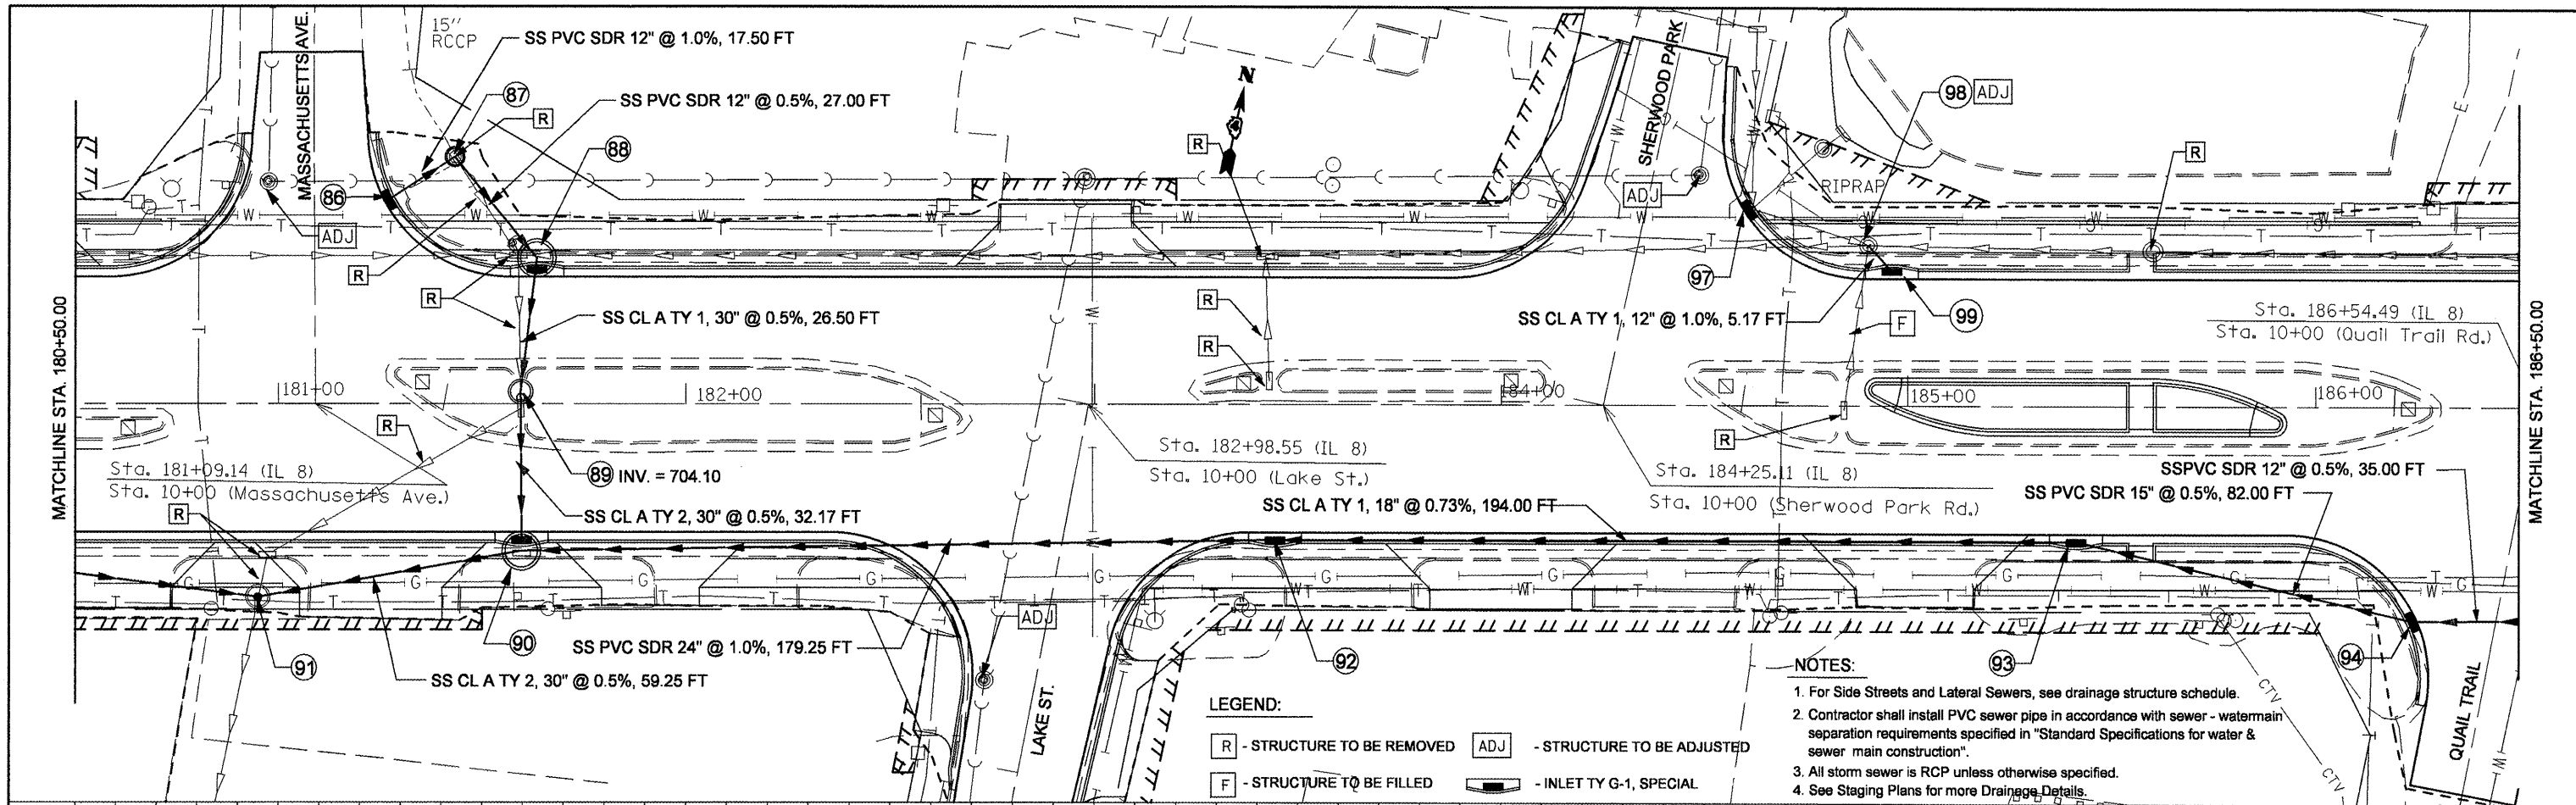

FILE NAME =	USER NAME = swisher-dh	DESIGNED -	REVISED -	STATE OF ILLINOIS DEPARTMENT OF TRANSPORTATION		IL RTE 8 - DRAINAGE PLANS RT SIDE		F.A.P. RTE.	SECTION	COUNTY	TOTAL SHEETS	SHEET NO.
copy of drainage plan rtdgn		DRAWN -	REVISED -					399	36 R-8	TAZEWELL	429	120
PLOT SCALE = 48.0000' / IN.		CHECKED -	REVISED -					CONTRACT NO. 68258				
PLOT DATE = 12/11/2008		DATE -	REVISED -					FED. ROAD DIST. NO. 4 ILLINOIS FED. AID PROJECT				