


IMAGE FILES:

KA038

K:\Kankakee\0807506 Lighting Ph.2\Draw\Sheets  
 FILE: Lighting-02.dwg  
 LAYOUT: Layout1  
 UPDATE BY: Jim Ohse  
 SURVEY BOOK #  
 DATE: Thursday, January 15, 2009 11:20:16 AM  
 XREF DWG: tbcInt.dwg  
 tb.dwg  
 elec-base.dwg

FOR LEGEND AND NOTES  
 SEE AIRFIELD LIGHTING SHEET 1

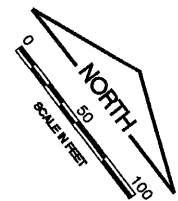



REVISIONS		
NUMBER	BY	DATE

0 1 2  
 THIS BAR IS EQUAL TO 2"  
 AT FULL SCALE (34X22).

**GREATER KANKAKEE AIRPORT  
 KANKAKEE, ILLINOIS  
 REHABILITATE AIRFIELD LIGHTING SYSTEM -  
 RUNWAY 4/22 PARALLEL AND CONNECTING TAXIWAYS  
 AIRFIELD LIGHTING PLAN  
 STA. 106+00 TO STA. 118+00**

© Copyright CMT, Inc.  
**CMT**  
 CRAWFORD, MURPHY & TILLY, INC.  
 CONSULTING ENGINEERS  
 License No. 84-000613

DESIGN BY:	MND
DRAWN BY:	JRO
CHECKED BY:	MND
APPROVED BY:	
DATE:	01/16/09
JOB No:	08075-06
IL PROJECT: IKK-3863 A.I.P. PROJECT: 3-17-0057-B15	
<b>FINAL SUBMITTAL</b>	
SHEET 13 OF 20 SHEETS	

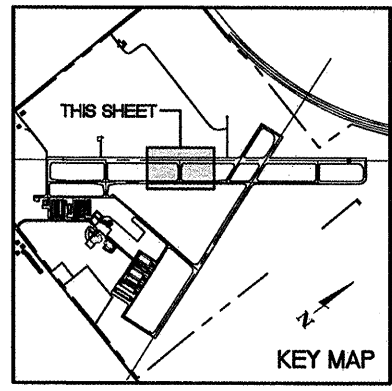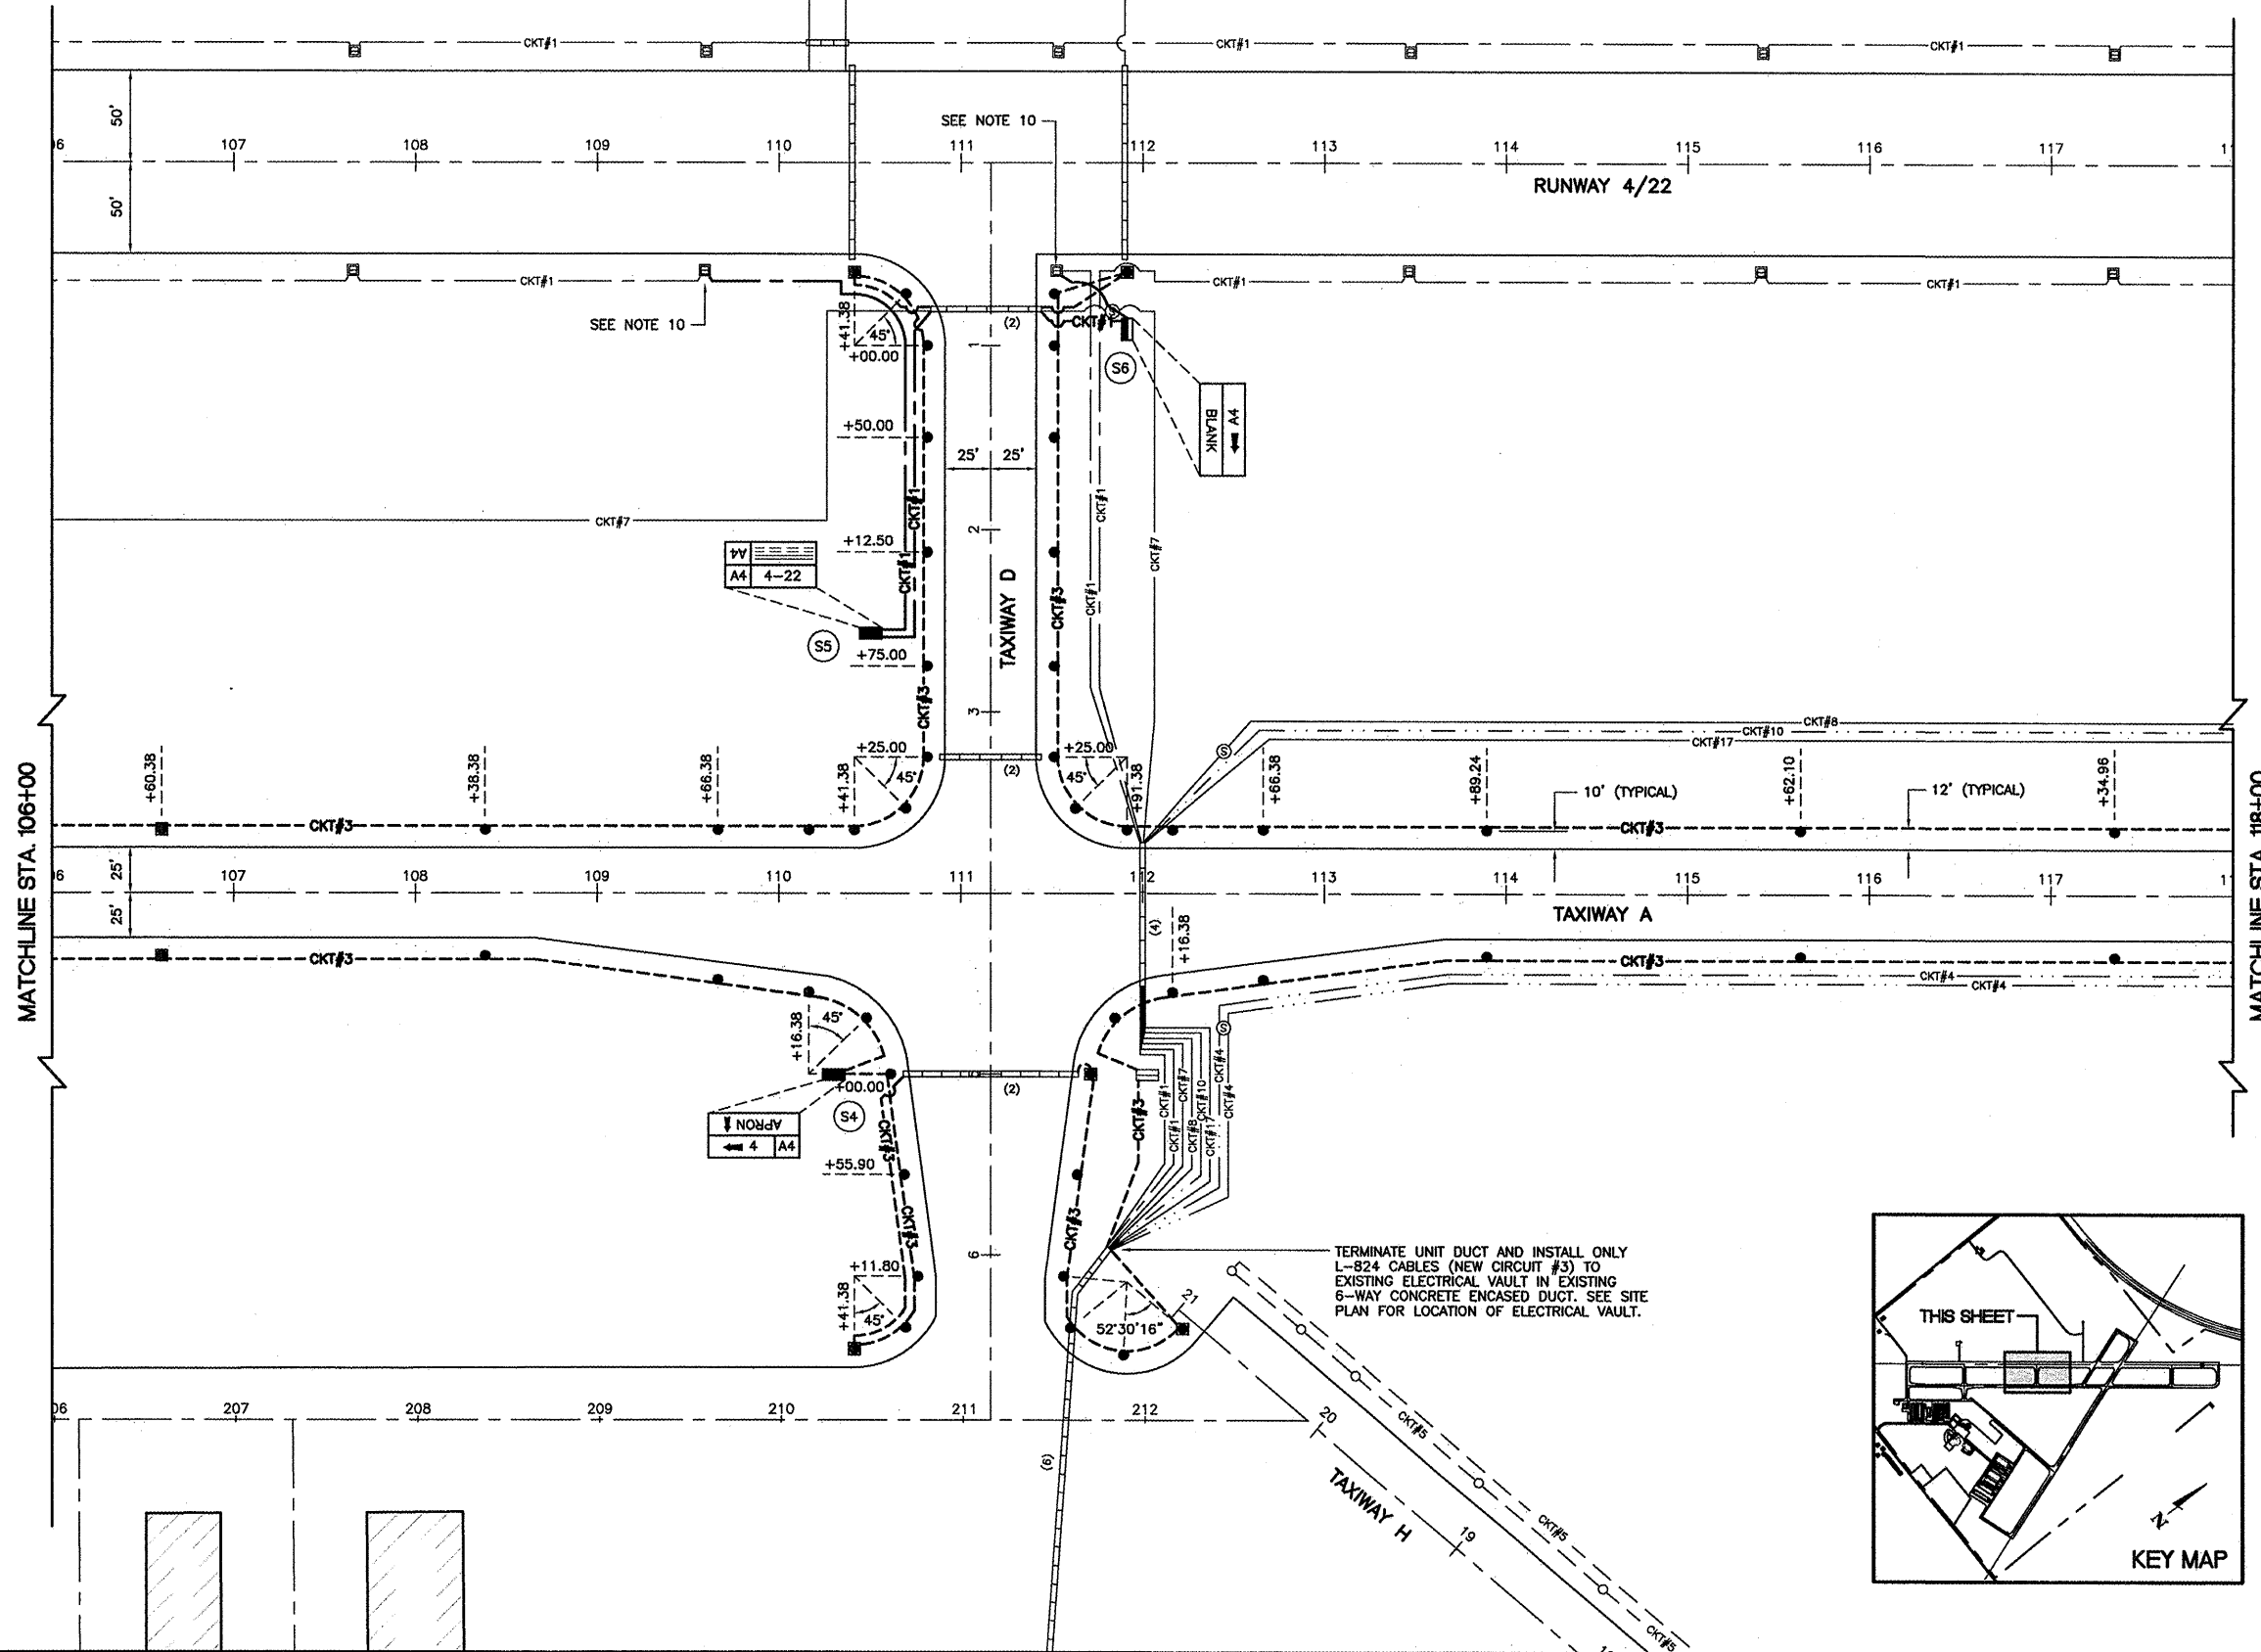

MATCHLINE STA. 106+00

MATCHLINE STA. 118+00