


IMAGE FILES:

KA038



K:\Kankakee\0807506 Lighting Ph.2\Draw\Sheets
 FILE: Lighting-05.dwg
 LAYOUT: Layout1
 UPDATE BY: Jim Ohse
 SURVEY BOOK #
 DATE: Thursday, January 15, 2009 11:23:04 AM
 XREF DWG: tbcInt.dwg
 tb.dwg
 elec-base.dwg

FOR LEGEND AND NOTES
 SEE AIRFIELD LIGHTING SHEET 1

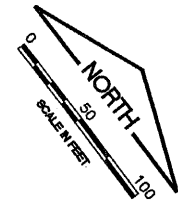

REVISIONS		
NUMBER	BY	DATE

0 1 2
 THIS BAR IS EQUAL TO 2"
 AT FULL SCALE (34X22).

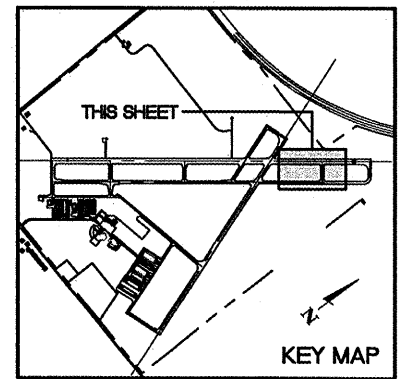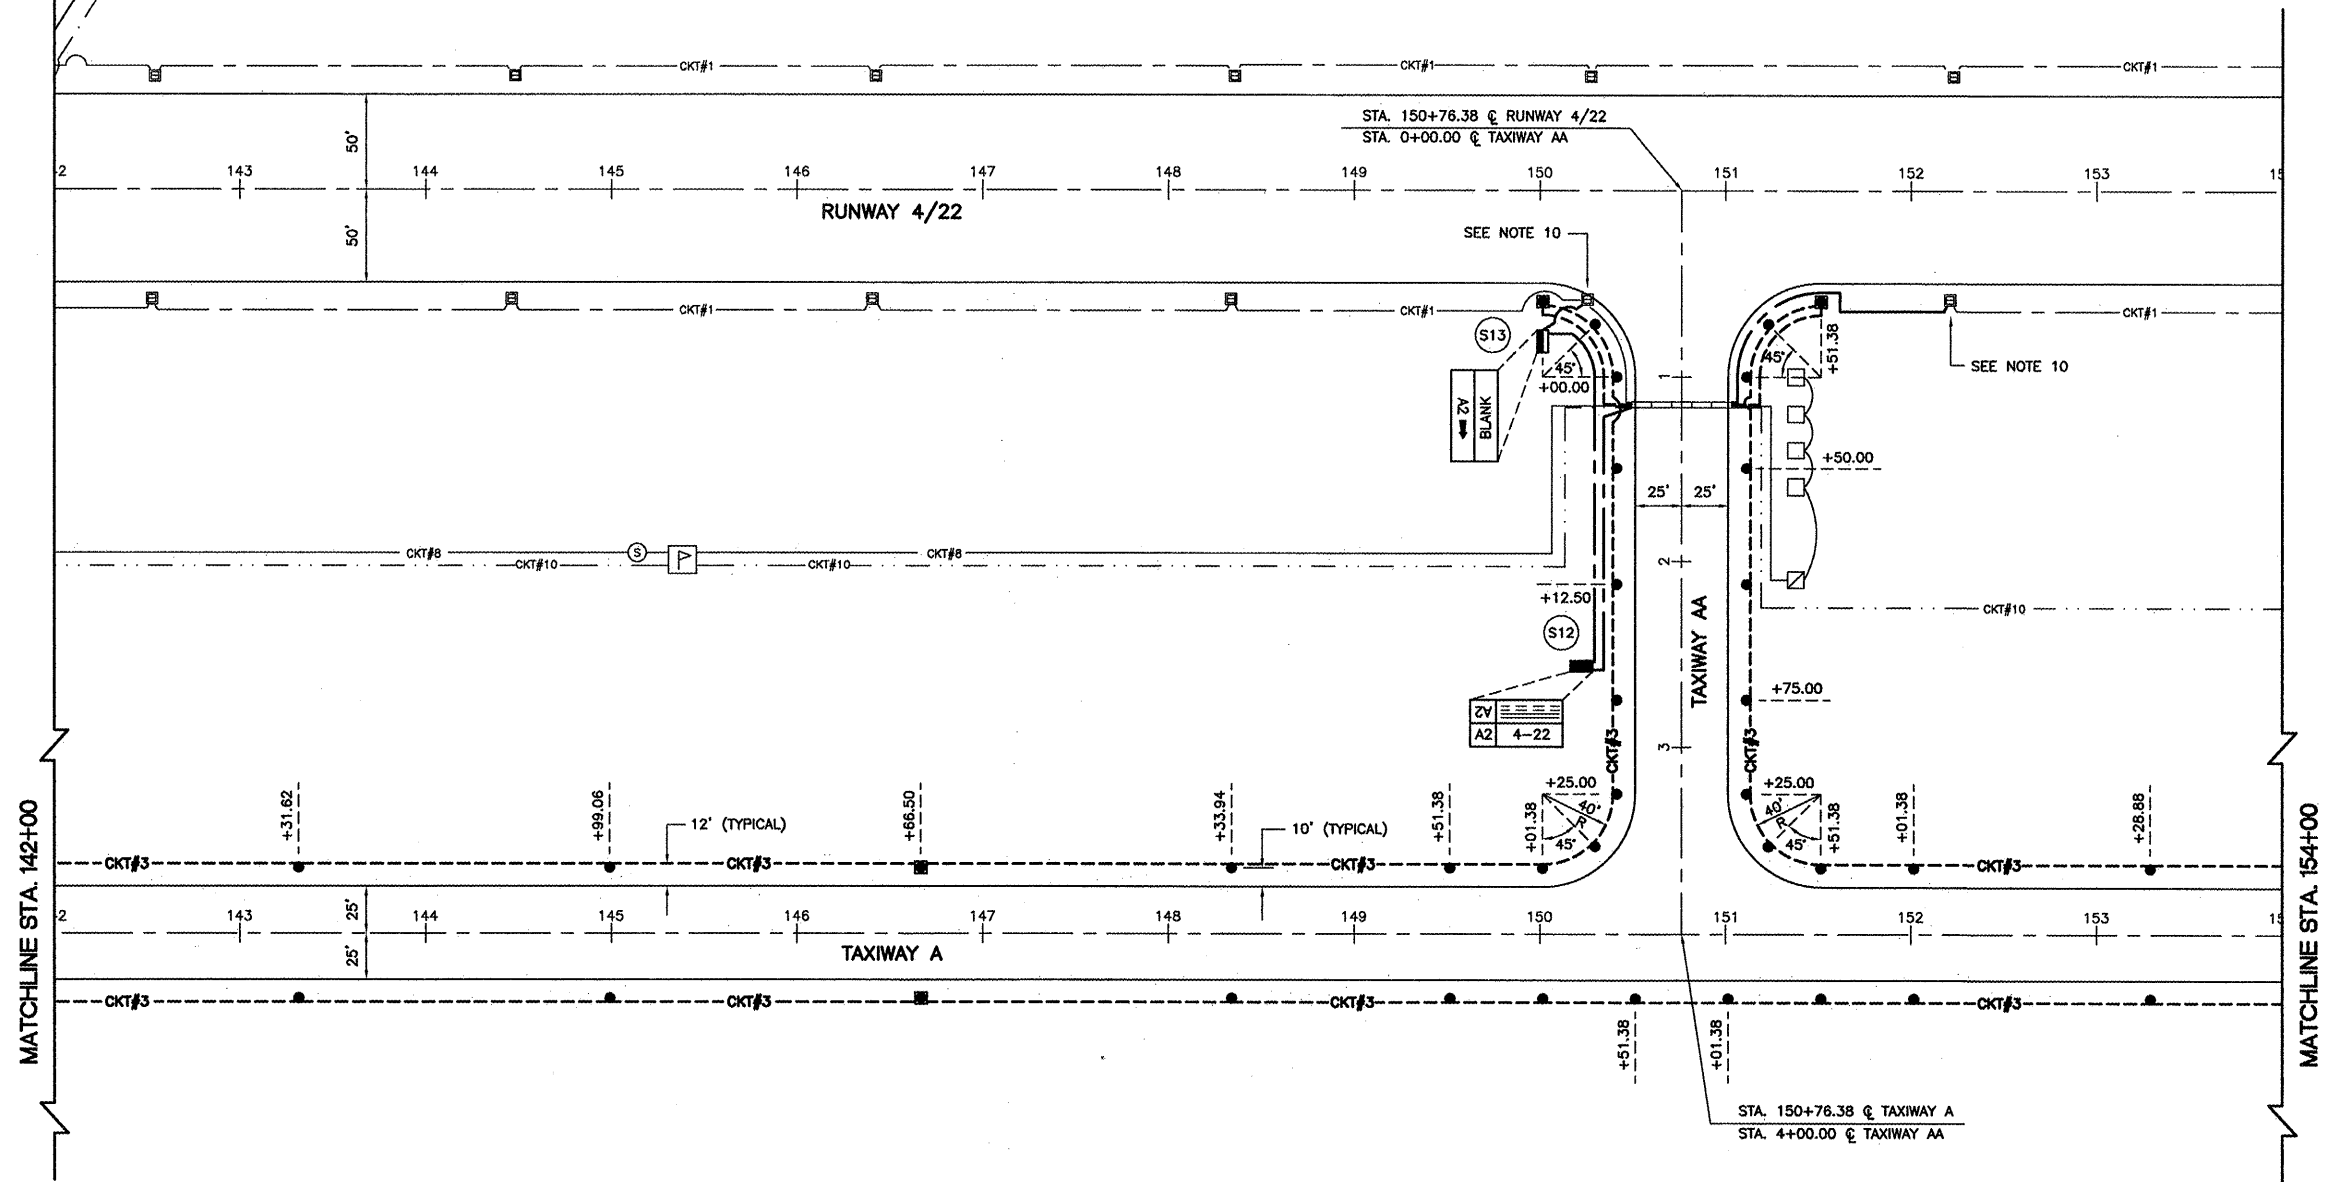

GREATER KANKAKEE AIRPORT
 KANKAKEE, ILLINOIS
 REHABILITATE AIRFIELD LIGHTING SYSTEM -
 RUNWAY 4/22 PARALLEL AND CONNECTING TAXIWAYS
 AIRFIELD LIGHTING PLAN
 STA. 142+00 TO STA. 154+00

© Copyright CMT, Inc.
CMT
 CRAWFORD, MURPHY & TILLY, INC.
 CONSULTING ENGINEERS
 License No. 84-000613

DESIGN BY:	MND
DRAWN BY:	JRO
CHECKED BY:	MND
APPROVED BY:	
DATE:	01/16/09
JOB No:	08075-06
IL PROJECT:	IKK-3863
A.I.P. PROJECT:	3-17-0057-B15
FINAL SUBMITTAL	
SHEET 16 OF 20 SHEETS	