
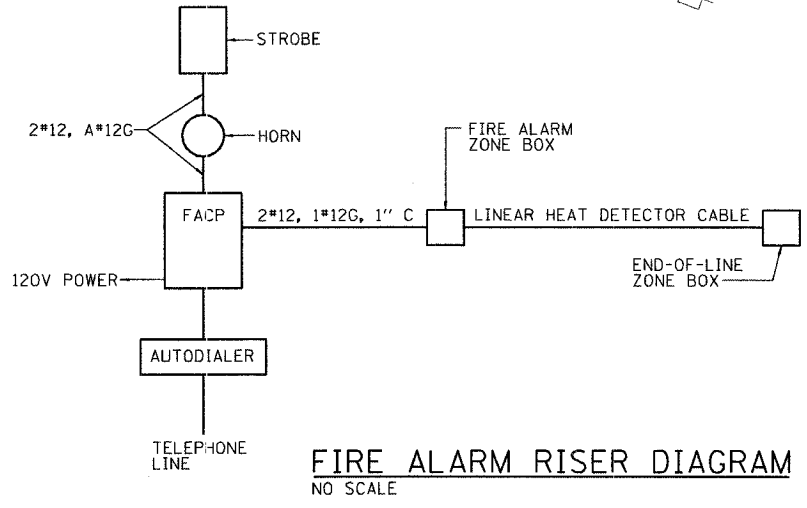


PROJECT	SECTION	COUNTY	SUBJECT	SHEET
245	98-20101-00-BR	BUREAU	65	62
FED. ROAD DIST. NO. 7	MILEAGE	FED. AID PROJECT - BROS-011(62)		

ELECTRICAL SHEET 4 OF 5

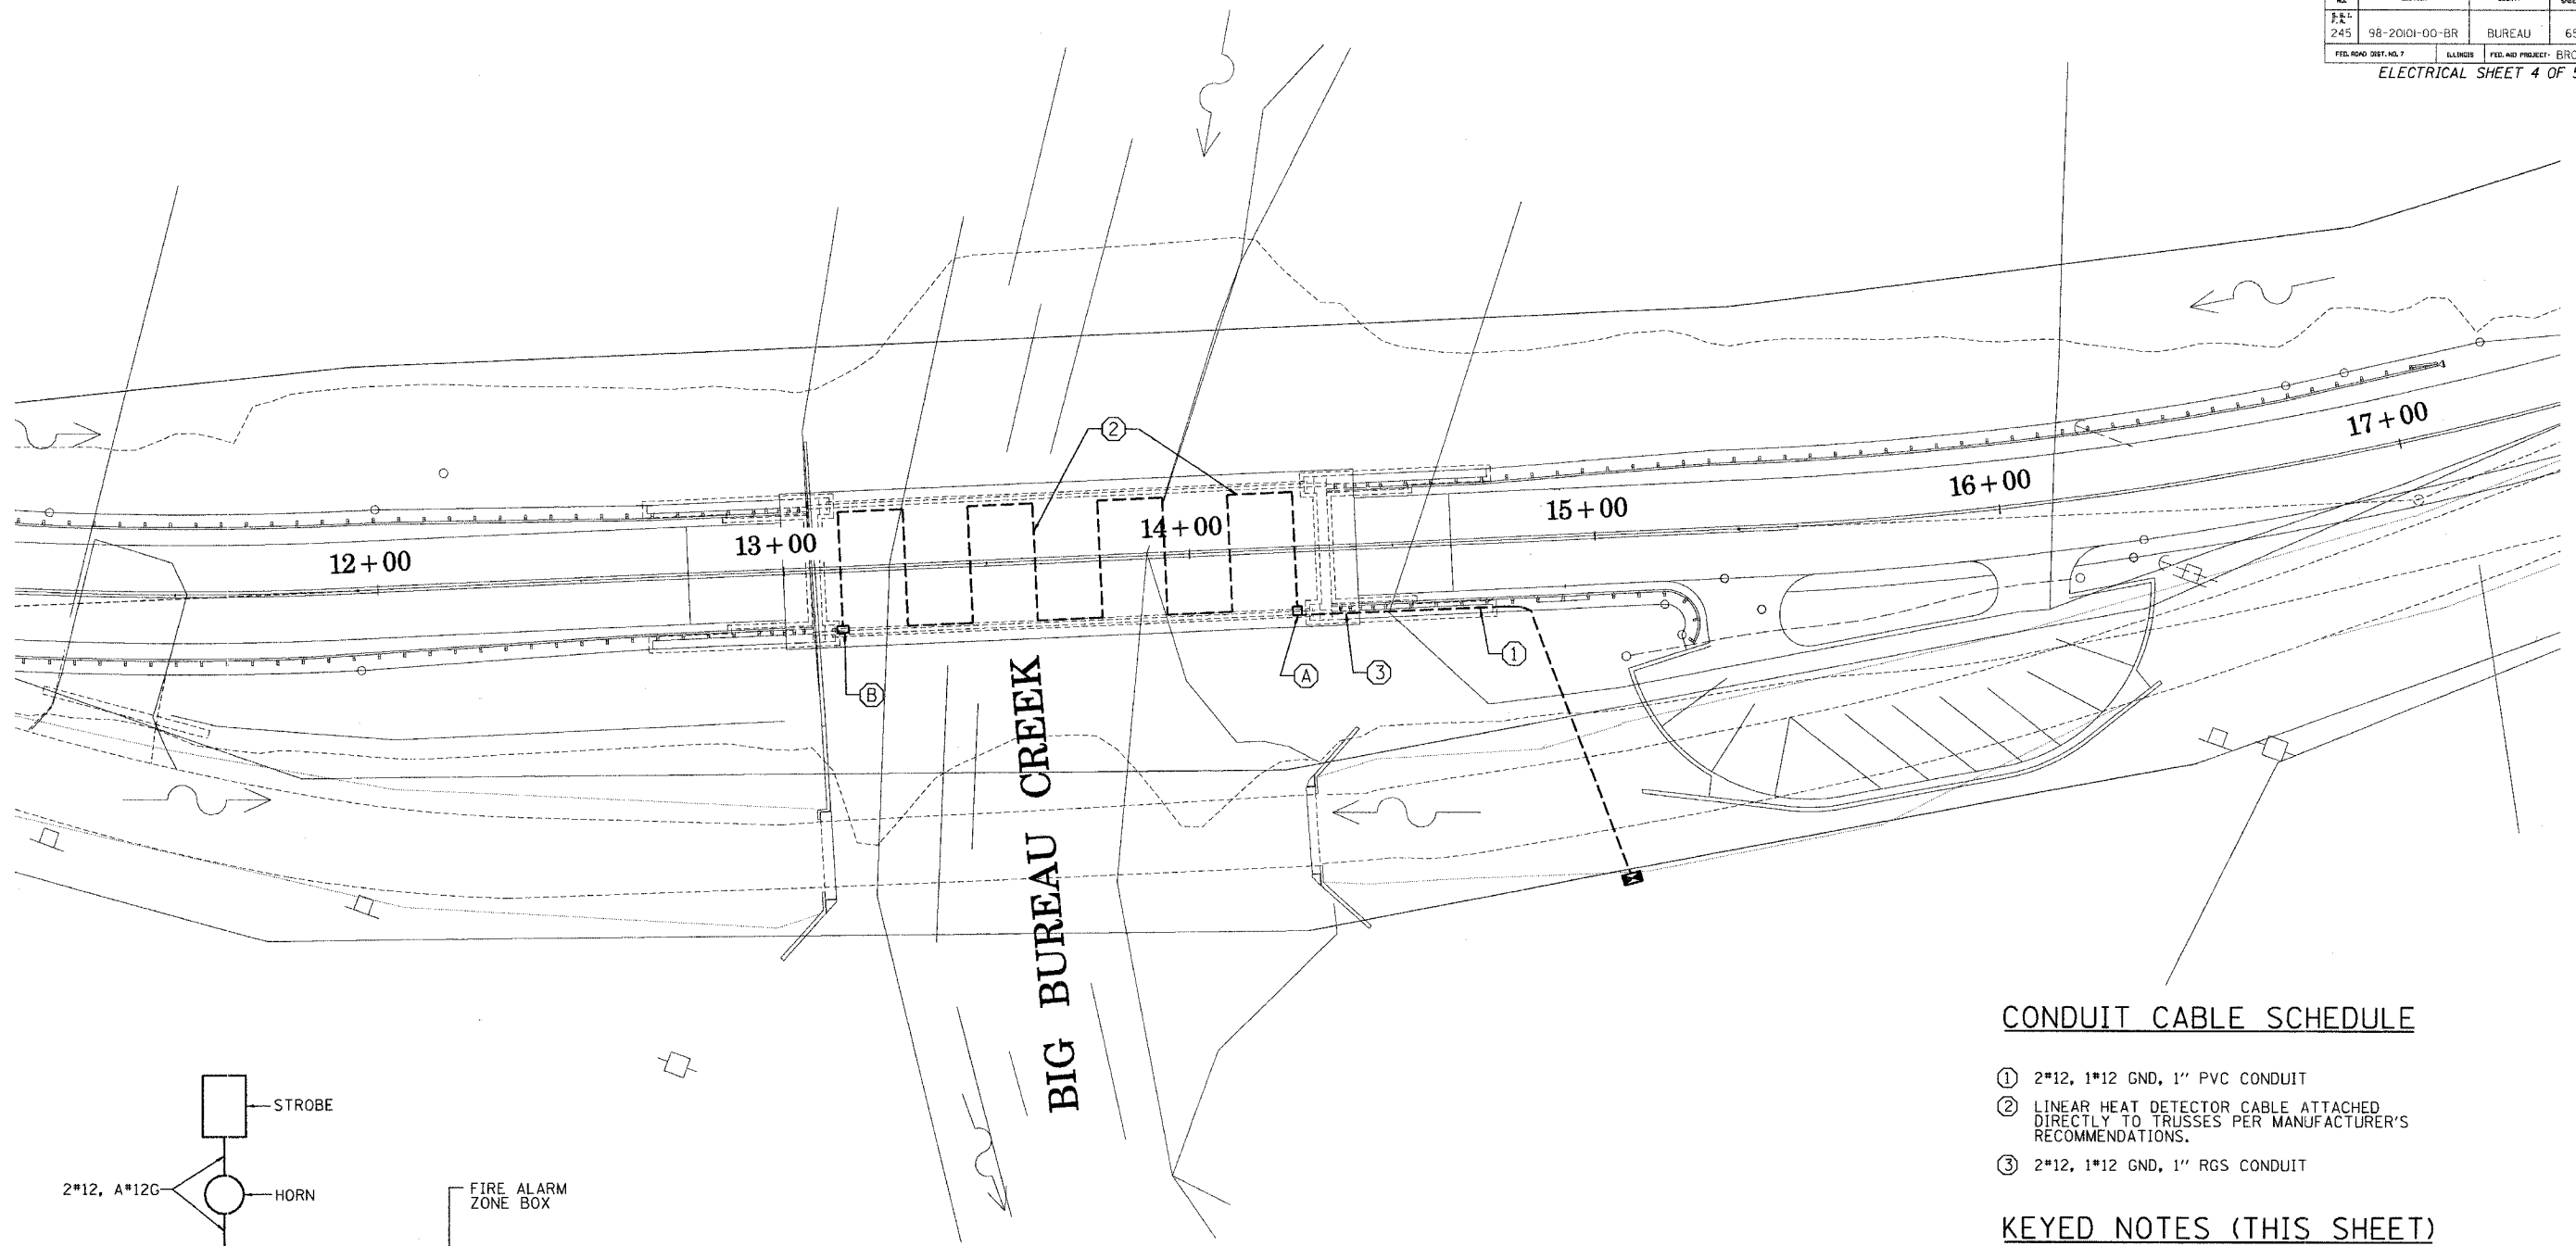

FIRE ALARM PLAN
SCALE: 1"=20'

CONDUIT CABLE SCHEDULE

- ① 2*12, 1*12 GND, 1" PVC CONDUIT
- ② LINEAR HEAT DETECTOR CABLE ATTACHED DIRECTLY TO TRUSSES PER MANUFACTURER'S RECOMMENDATIONS.
- ③ 2*12, 1*12 GND, 1" RGS CONDUIT

KEYED NOTES (THIS SHEET)

- (A) MANUFACTURER SUPPLIED ZONE BOX, SPLICE LINEAR HEAT DETECTOR CABLE TO 2*12 CONDUCTORS BACK TO CONTROLLER PER MANUFACTURER'S RECOMMENDATIONS.
- (B) END OF LINE ZONE BOX. INSTALL PER MANUFACTURER'S RECOMMENDATIONS.

FIRE ALARM PLAN
SECTION 98-20101-00-BR
T.R. 245 OVER BIG BUREAU CREEK
STA. 13+70 (S.N. 006-4288)
BUREAU COUNTY

		Designed By: J.J.F.
		Date: August, 05
		Checked By: C.E.C.
		Date: August, 05
		Drawn By: M.E.W.
		Date: August, 05

WHA # 1104D04