
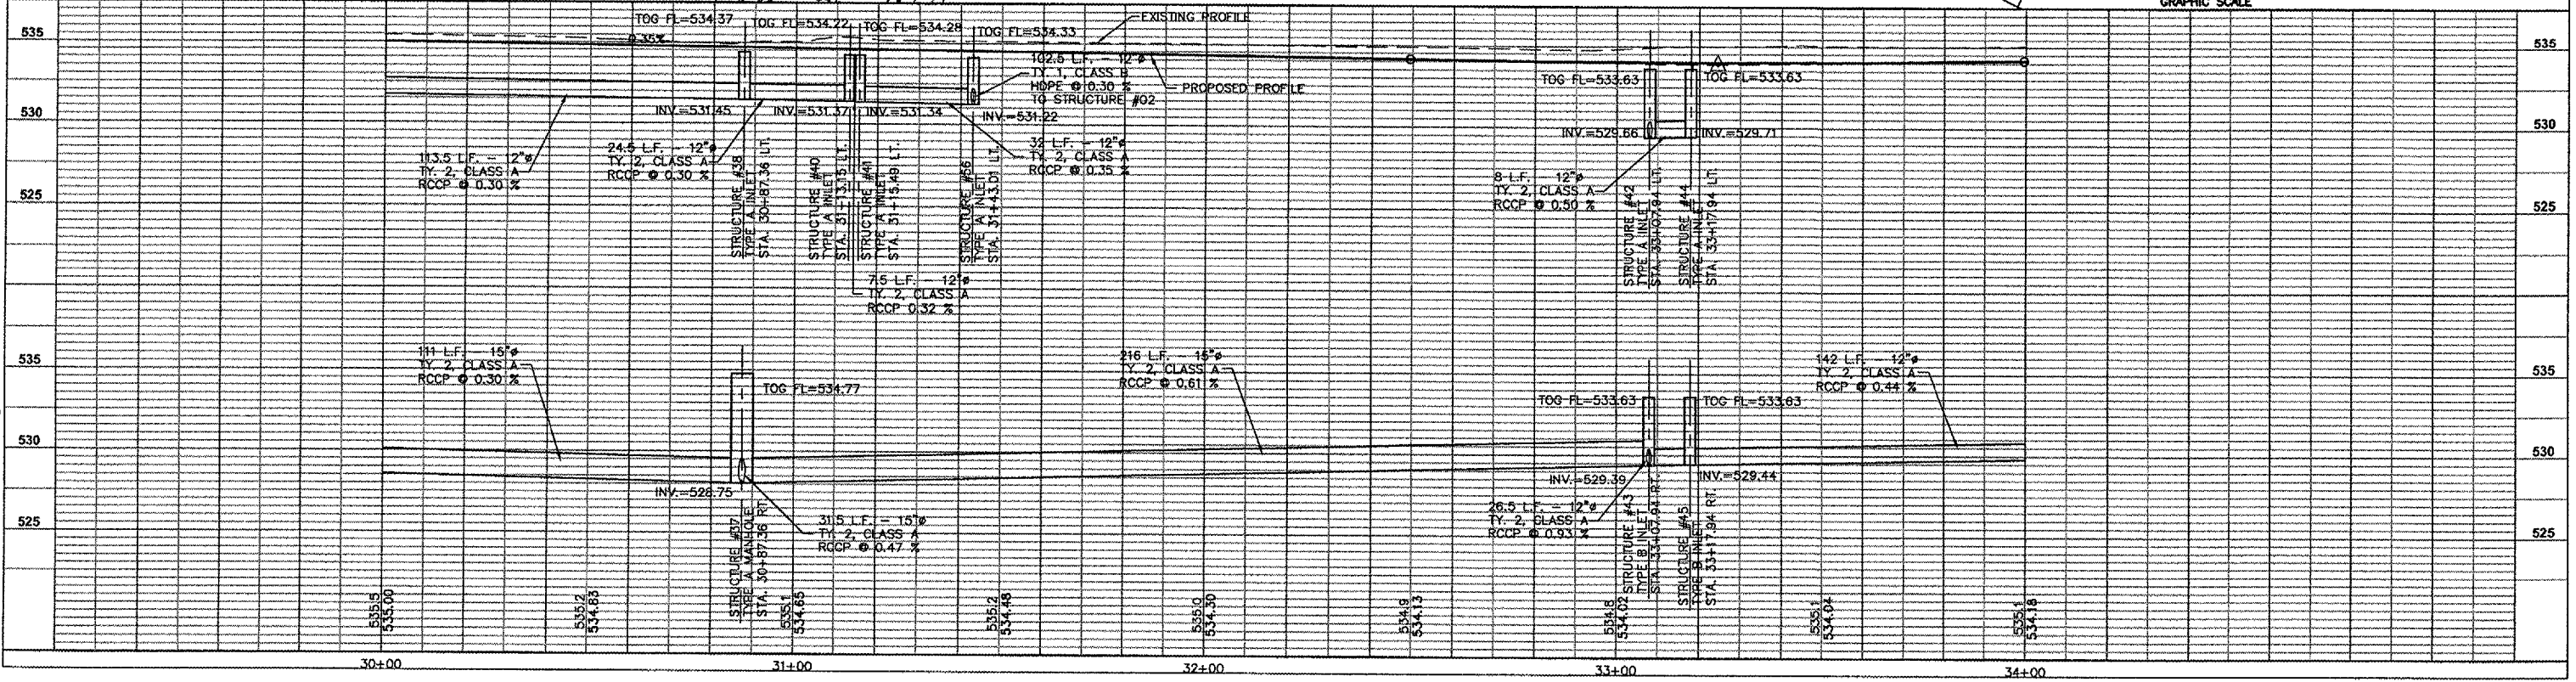
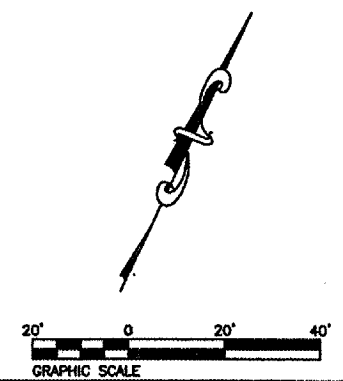


EAU NO.	SECTION	COUNTY	TOTAL SHEETS	SHEET NO.
9397	01-00022-00-RP	MADISON	72	33
STA. 30+00		TO STA. 34+00		
DRAINAGE PLAN AND PROFILE				

CONTRACT NO. 97269

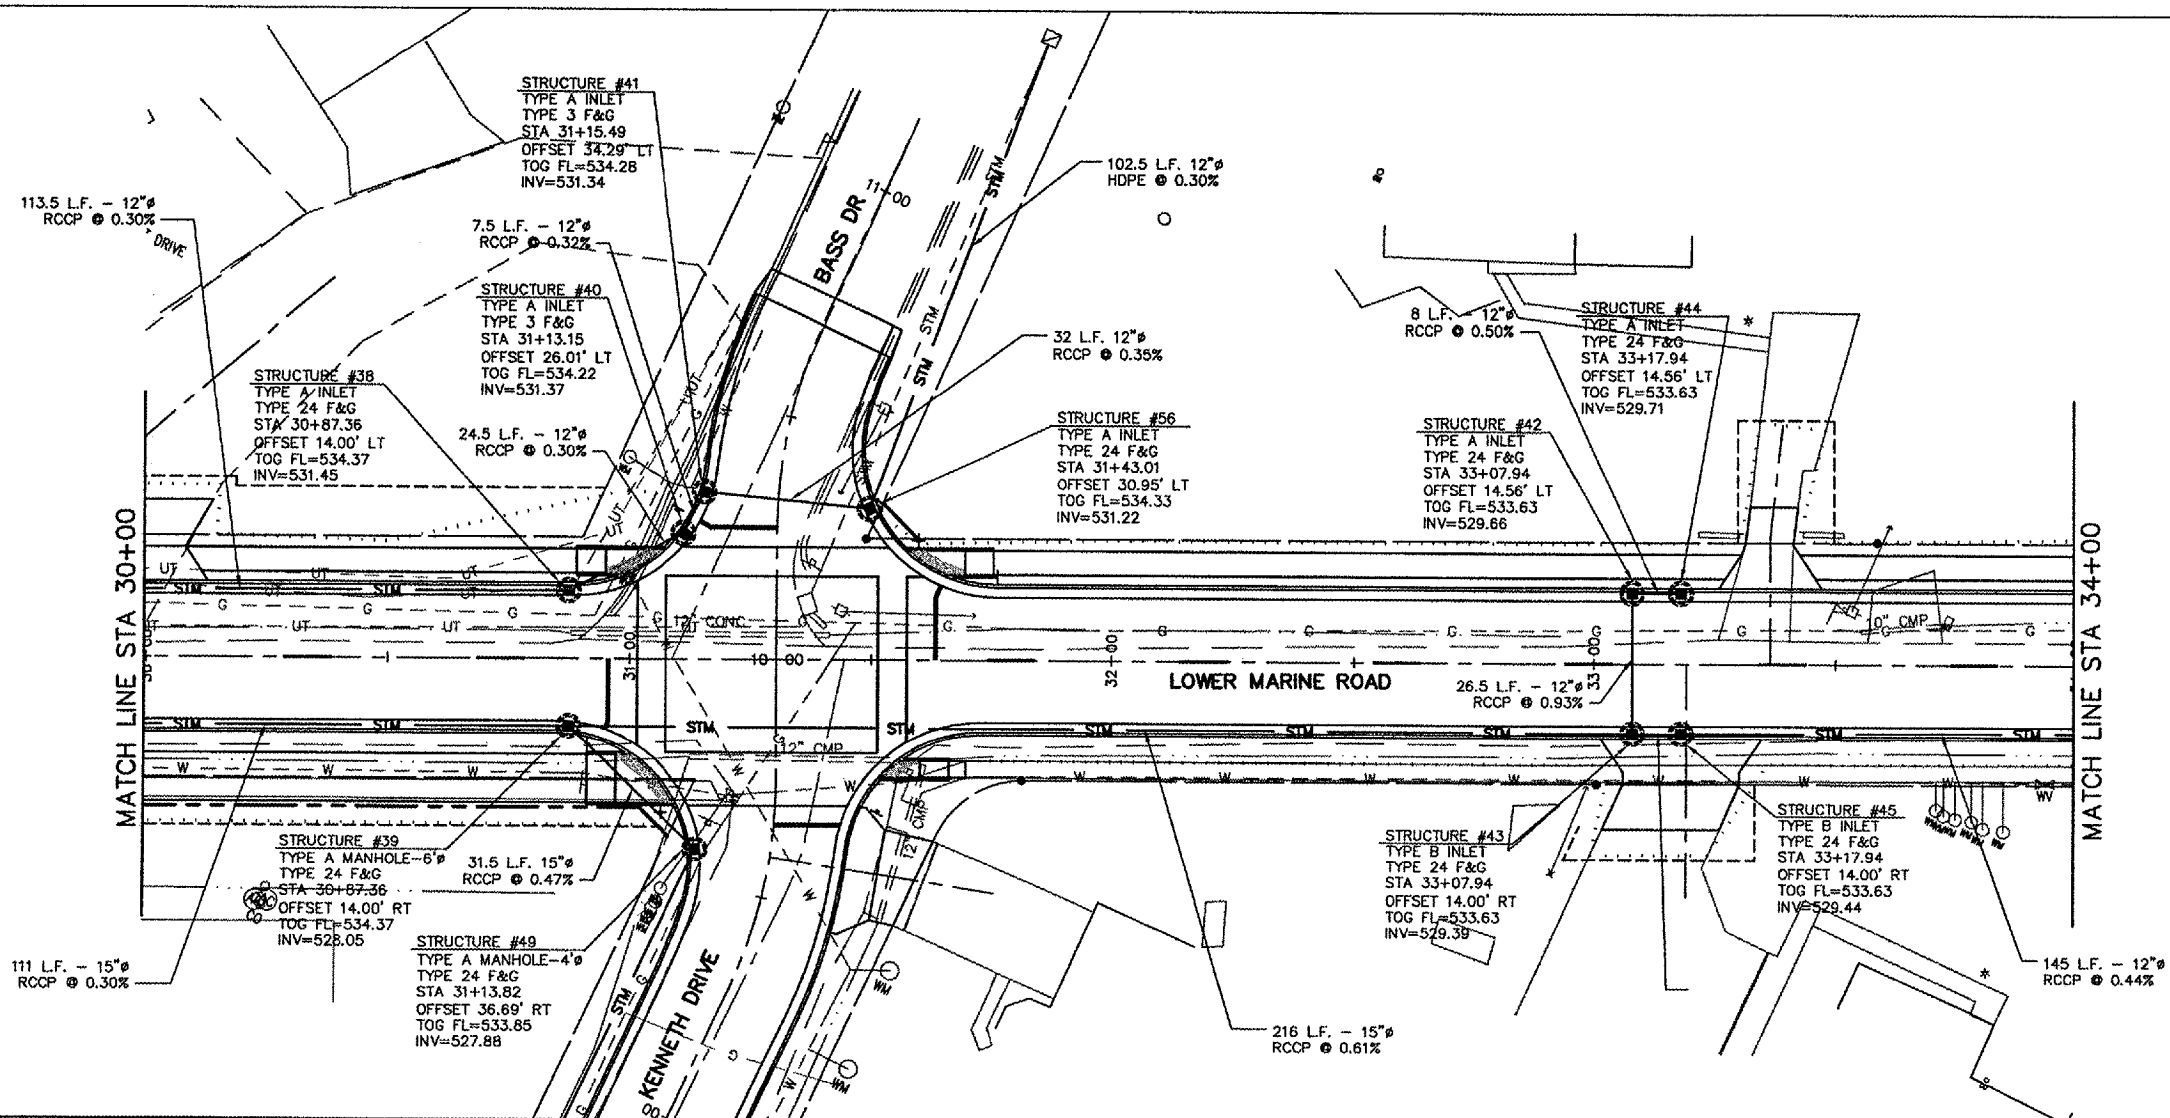

P:\000139a\dwg\000139AK05.dwg 11/21/2005 4:45:34 PM CST