
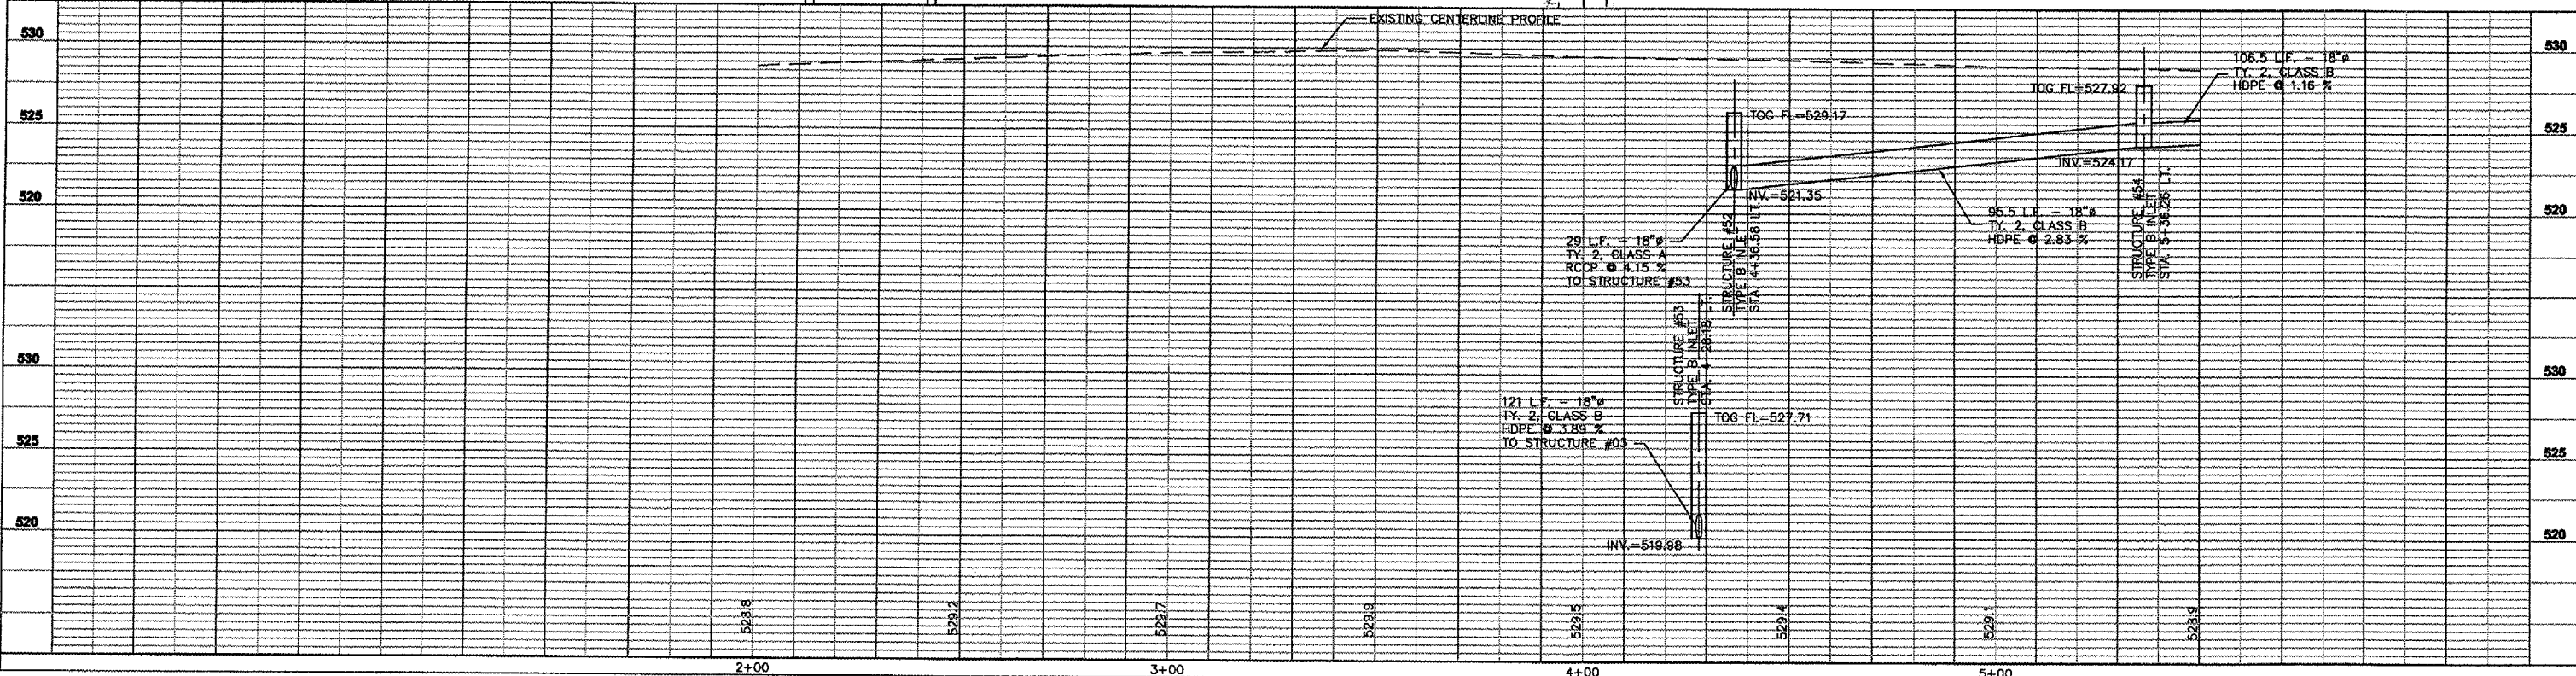
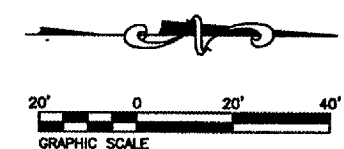


PIV NO./7E	SECTION	COUNTY	TOTAL SHEETS	SHEET NO.
9397	01-00022-00-RP	MADISON	72	35
STA. 2+00		TO STA. 5+50		

DRAINAGE PLAN AND PROFILE

CONTRACT NO. 97269

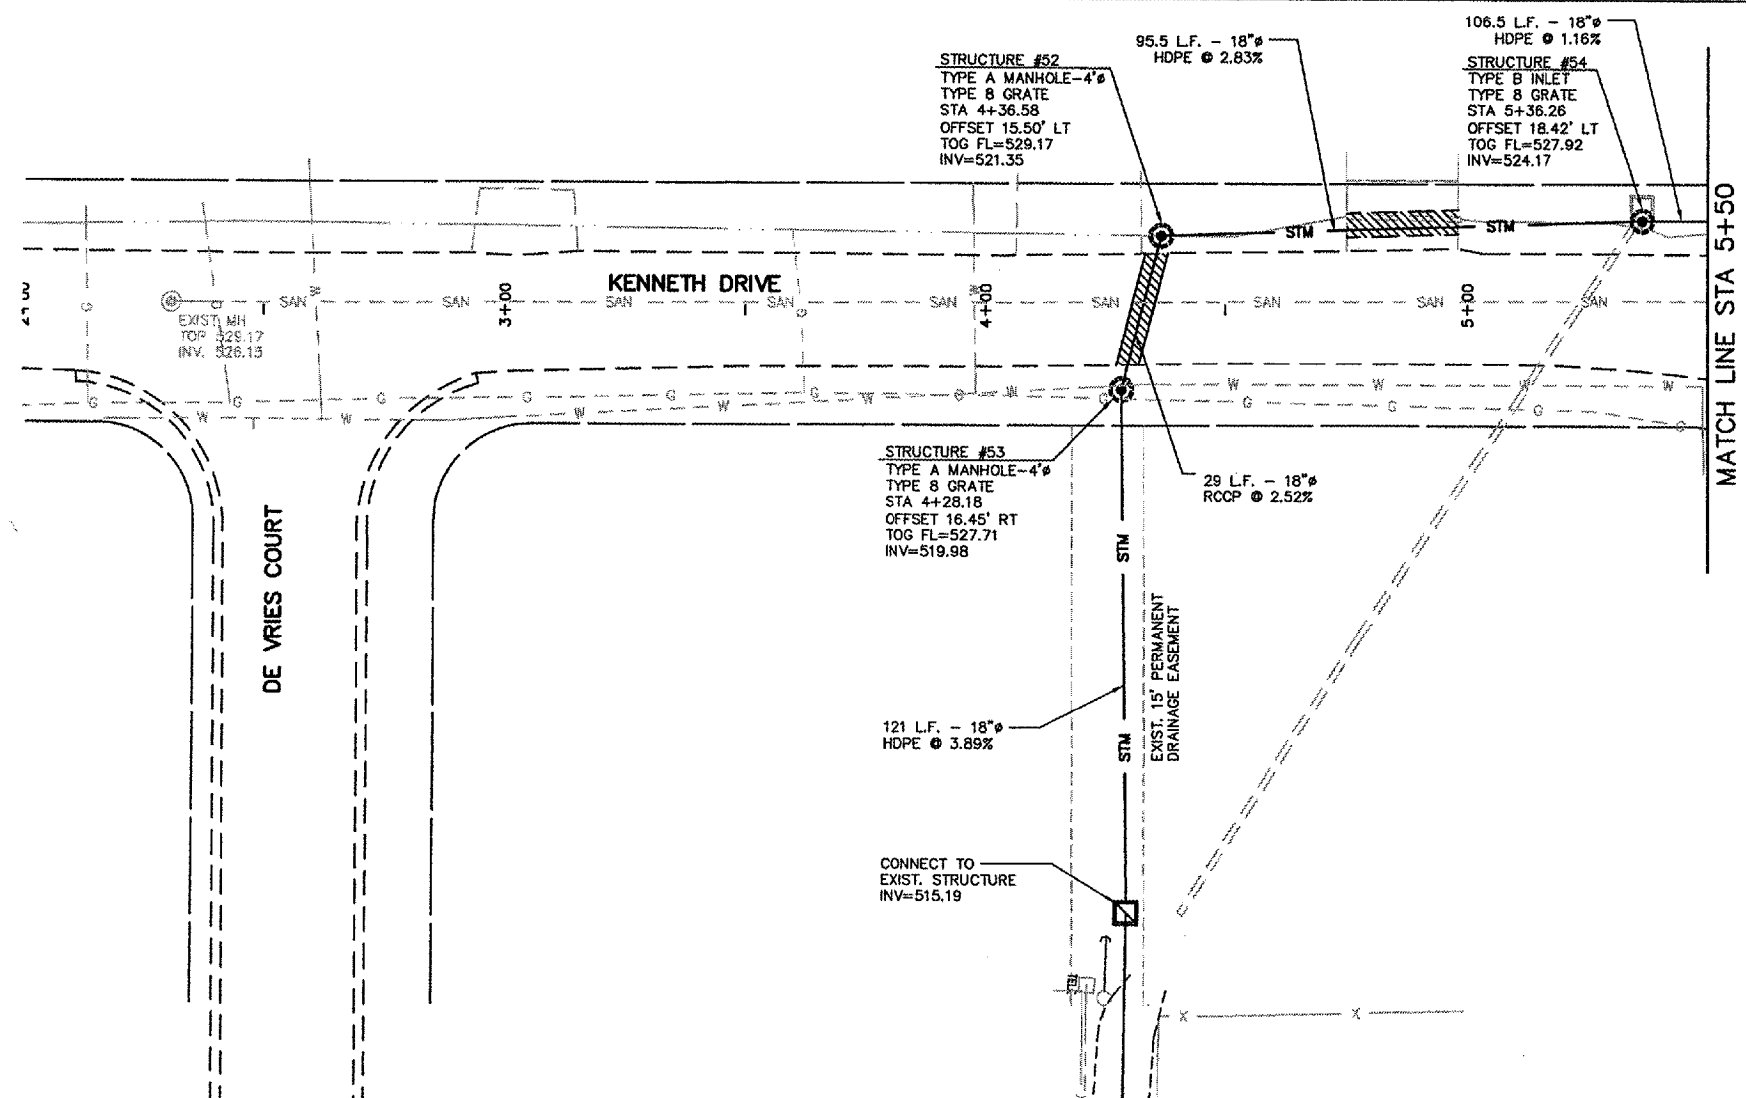

P:\000139a\dwg\000139AK08.dwg 11/21/2005 4:47:39 PM CST