


F.A.T. RTE.	SECTION	COUNTY	TOTAL SHEETS	SHEET NO.
55	2002-022 K	WILL	172	47
STA. 10+00		TO STA. 22+96.05		
FED. ROAD DIST. NO.		ILLINOIS FED. AID PROJECT		
CONTRACT NO. 62389				

- LEGEND: PROPOSED UTILITIES**
- INLET
  - MANHOLE
  - CATCHBASIN
  - ∩ CONCRETE HEADWALL
  - ▶ FLARED END SECTION
  - ~ DITCH FLOW
  - ⊕ DITCH CHECK
  - ↔ SUMMIT
  - ➔ DIRECTION OF WATER
  - ⦿ FIRE HYDRANT
  - SWALE
  - SANITARY SEWER LINE
  - STORM SEWER LINE
  - CULVERT

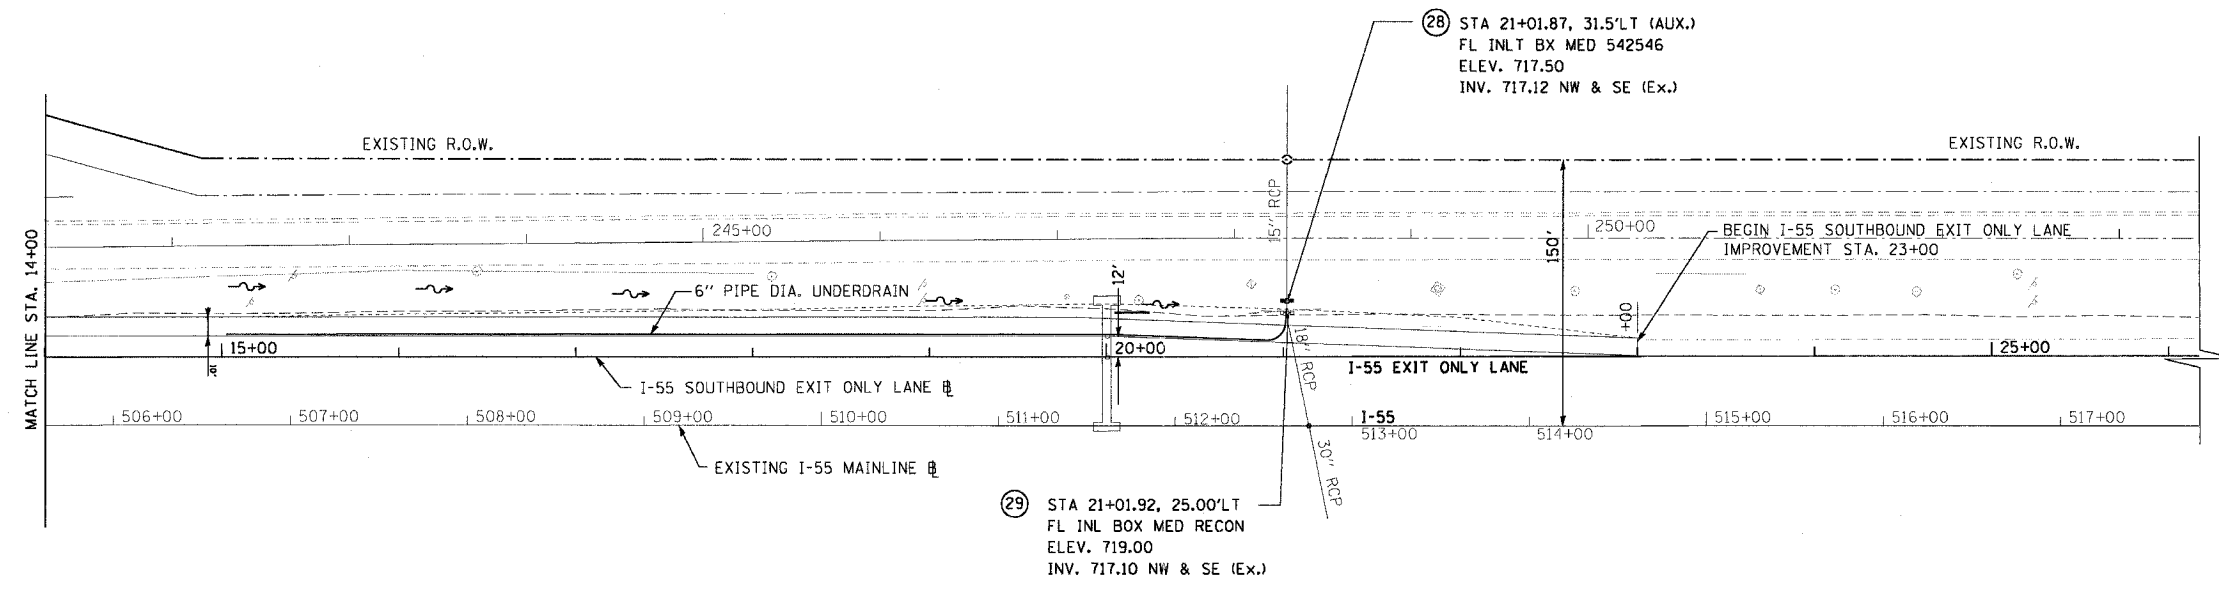


**PLAN**

DATE	
BY	
SURVEYED	
PLotted	
Checked	
RT. OF WAY CHECKED	
NO. CAD FILE NAME	

**PROFILE**

DATE	
BY	
SURVEYED	
PLotted	
Checked	
BL. NOTED	
STRUCTURE NOTATIONS CHKD	

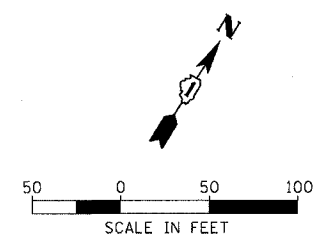

**DMJM HARRIS**  
 303 East Wacker Drive, Suite 600  
 Chicago, Illinois, 60601 Phone: 312.321.6101 Fax: 312.396.2392

REVISIONS	
NAME	DATE

ILLINOIS DEPARTMENT OF TRANSPORTATION

PROPOSED DRAINAGE PLAN  
 I-55 SOUTHBOUND EXIT ONLY LANE  
 STA 14+00 TO STA 23+00

SCALE: 1"=50'  
 DATE: 11/8/2004

DRAWN BY: CC  
 CHECKED BY: RI

OCTOBER, 2004