


F.A.I. RTE.	SECTION	COUNTY	TOTAL SHEETS	SHEET NO.
55	2002-022 K	WILL	172	72
STA.		TO STA.		
FED. ROAD DIST. NO.		ILLINOIS FED. AID PROJECT		
CONTRACT # 62389				

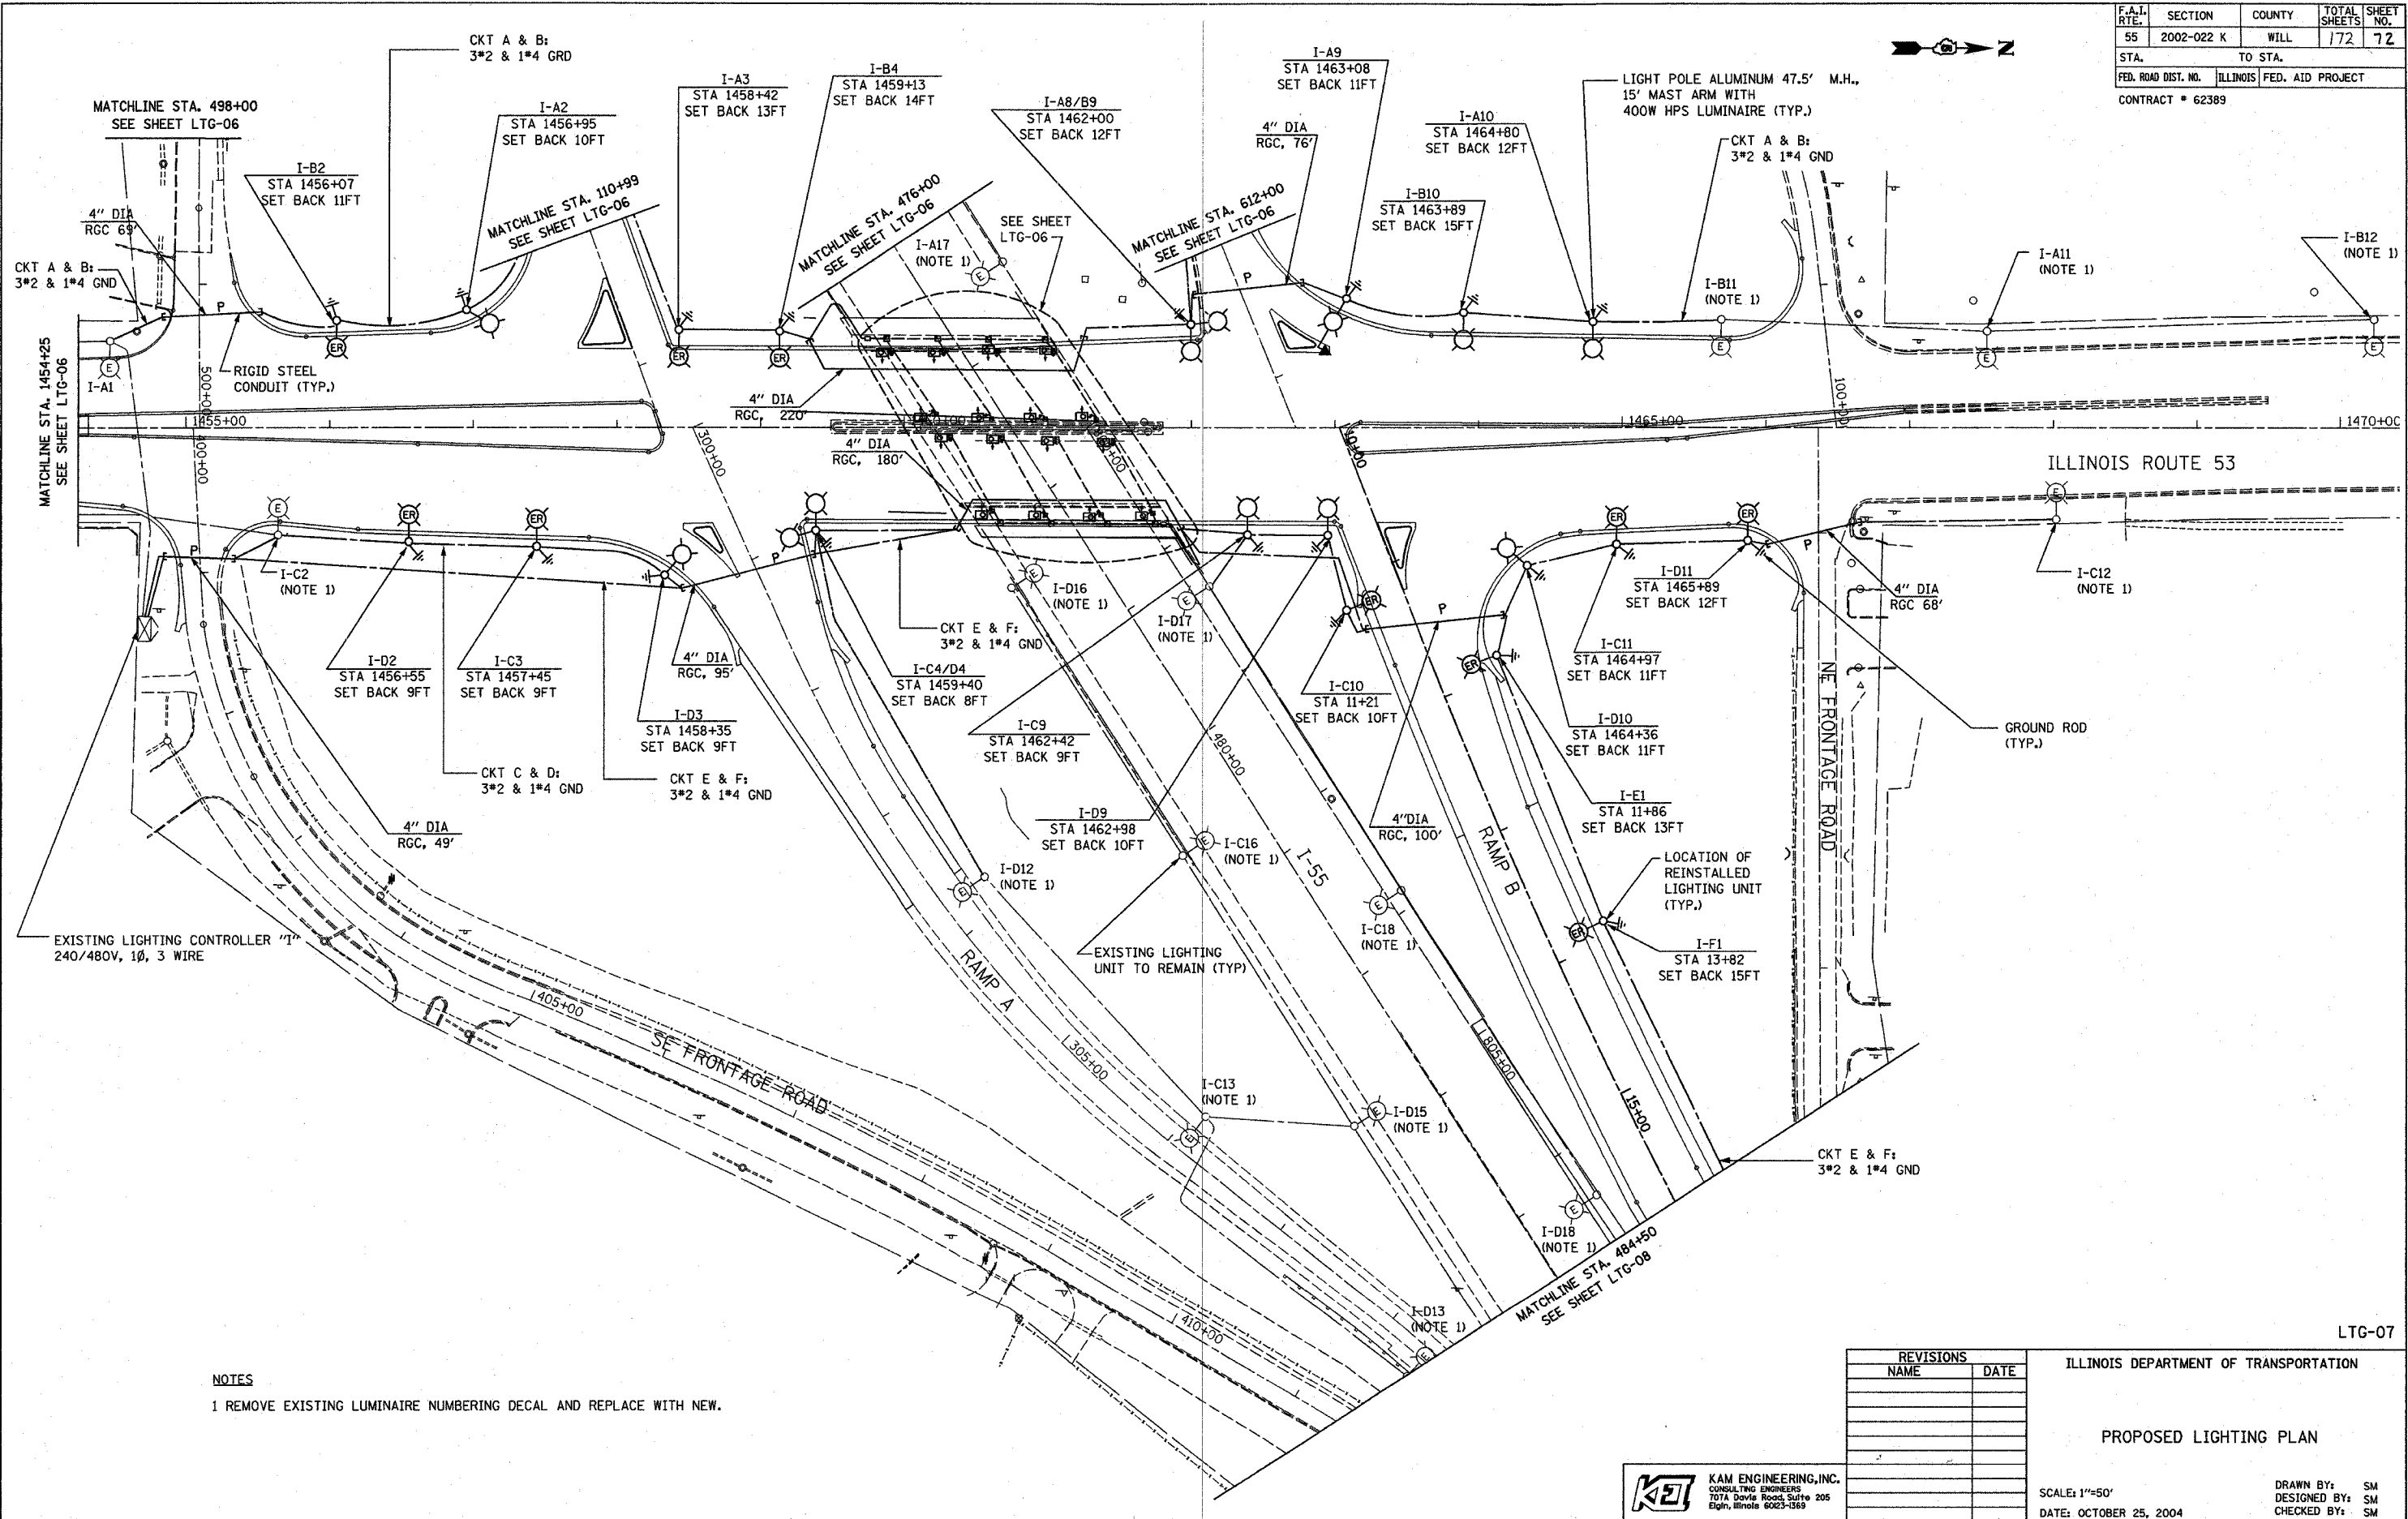

PLAN	DATE	BY
NO.		
NO.		
NO.		
NO.		

PROFILE	DATE	BY
NO.		
NO.		
NO.		
NO.		

**NOTES**  
 1 REMOVE EXISTING LUMINAIRE NUMBERING DECAL AND REPLACE WITH NEW.

REVISIONS	
NAME	DATE

ILLINOIS DEPARTMENT OF TRANSPORTATION  
**PROPOSED LIGHTING PLAN**  
 SCALE: 1"=50'  
 DATE: OCTOBER 25, 2004  
 DRAWN BY: SM  
 DESIGNED BY: SM  
 CHECKED BY: SM

**K&E** KAM ENGINEERING, INC.  
 CONSULTING ENGINEERS  
 707A Davis Road, Suite 205  
 Elgin, Illinois 60120-1569