





MATCH LINE
STA. 1061+00 F.A.I. 55
SEE SHEET NO. 205E

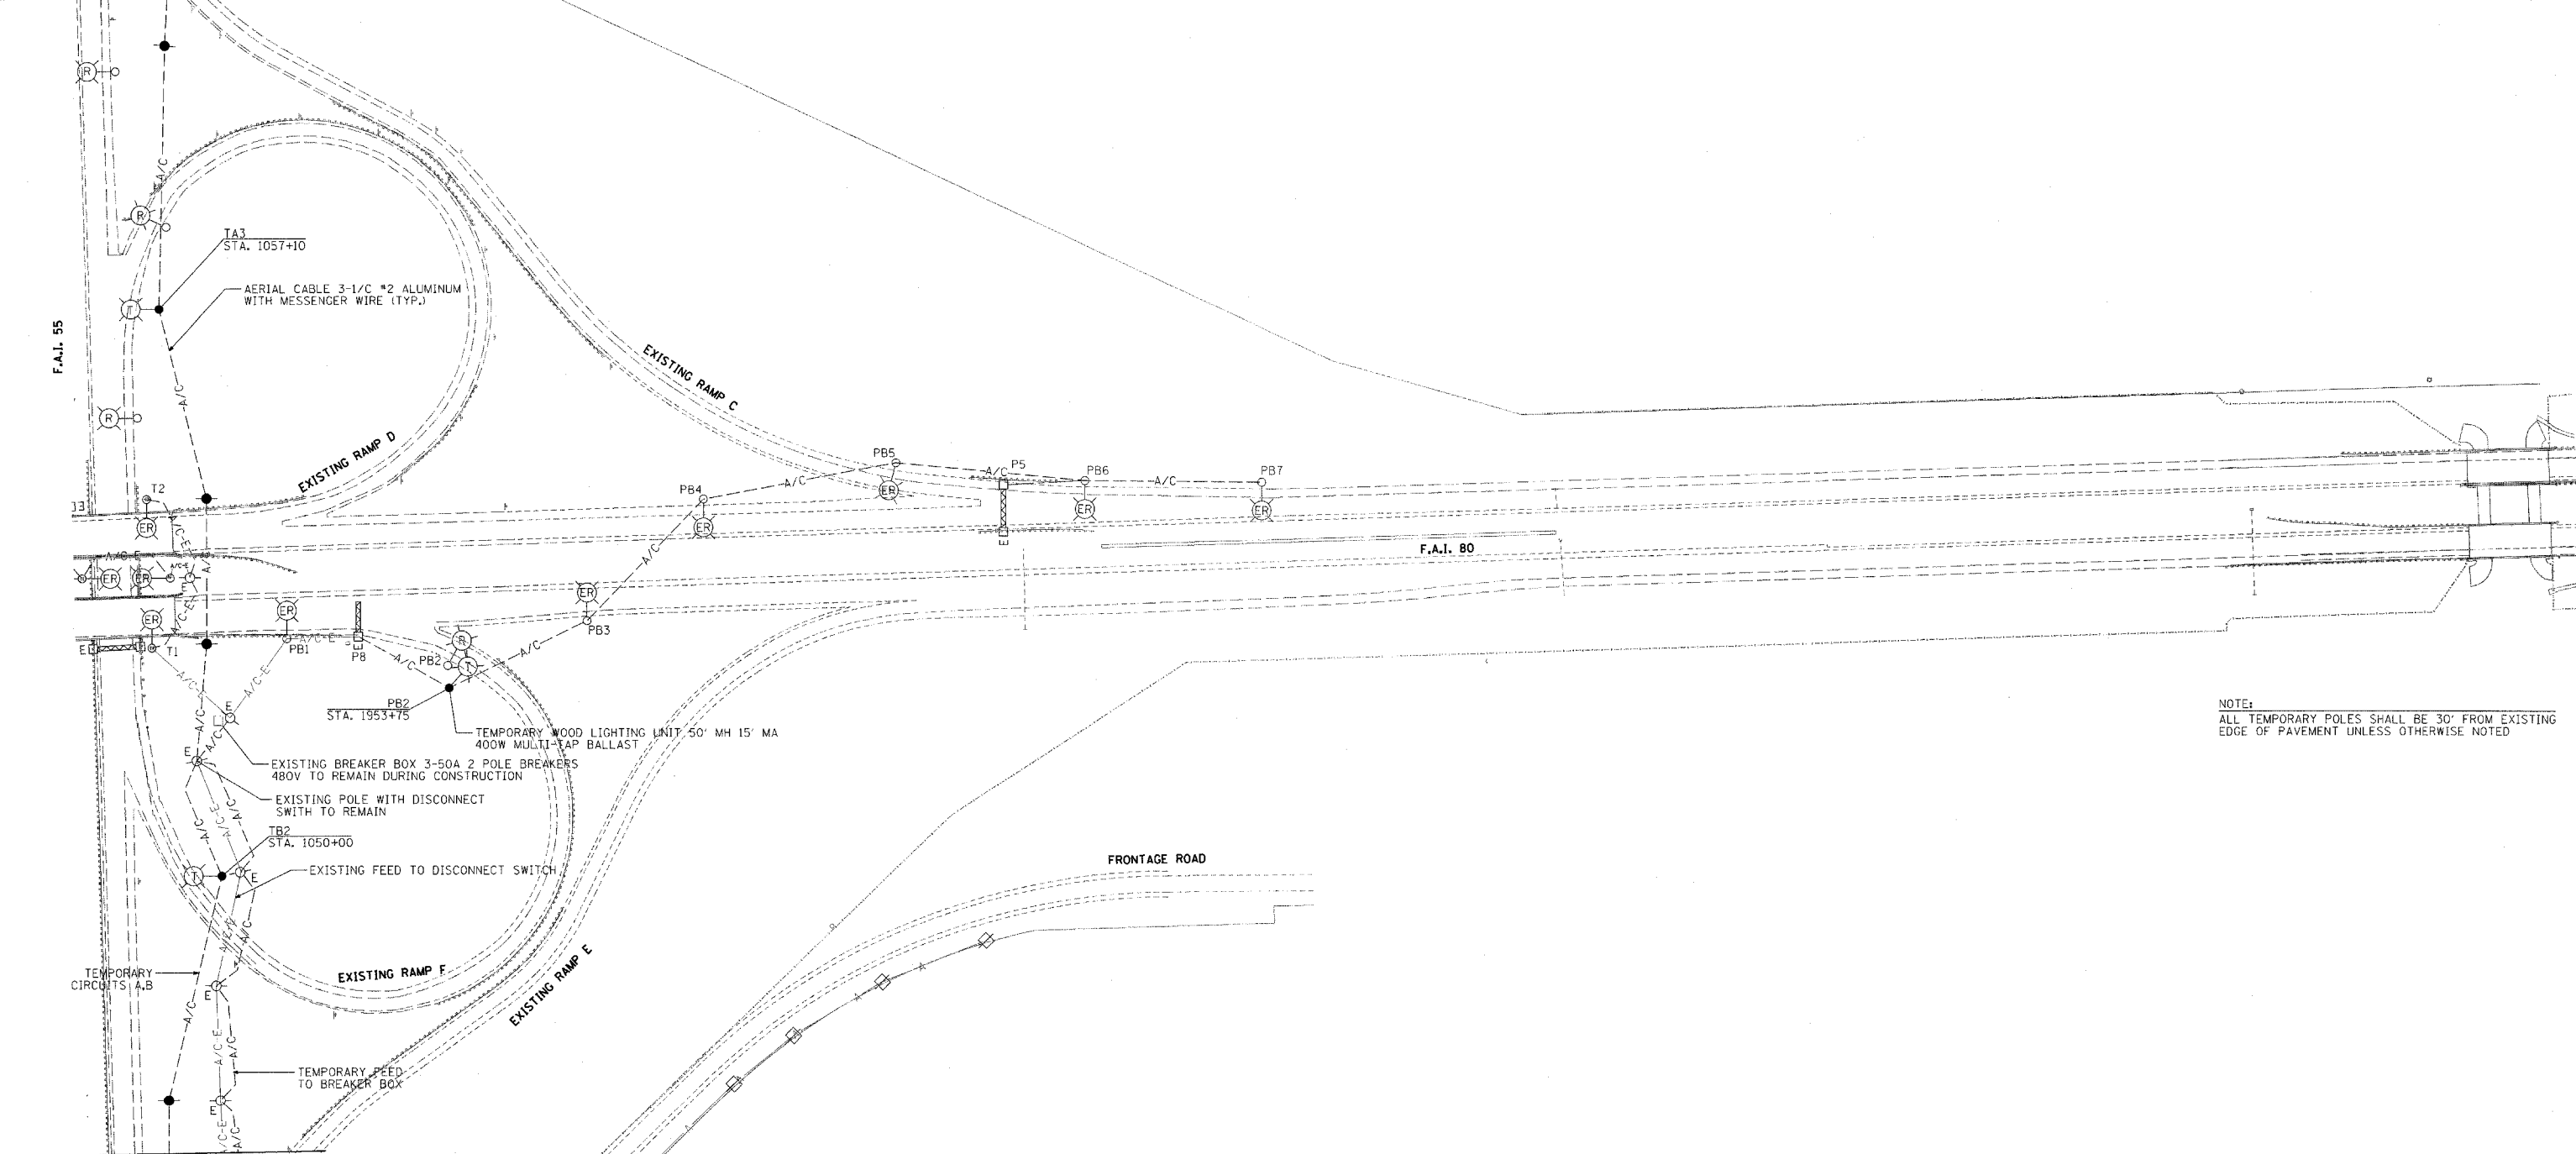

NOTE:
ALL TEMPORARY POLES SHALL BE 30' FROM EXISTING
EDGE OF PAVEMENT UNLESS OTHERWISE NOTED

MATCH LINE
STA. 1046+50 F.A.I. 55
SEE SHEET NO. 205D

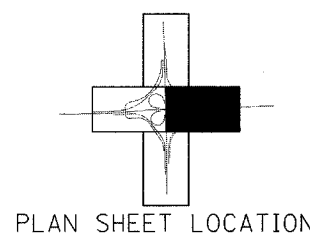

PLAN SHEET LOCATION

REVISIONS	
NAME	DATE

STATE OF ILLINOIS
DEPARTMENT OF TRANSPORTATION
F.A.I. 80 & F.A.I. 55 INTERCHANGE
**TEMPORARY LIGHTING PLAN
PRE-STAGE**

SCALE: 1" = 100'
DATE: JANUARY, 2005

DRAWN BY: JMV
CHECKED BY: AC