
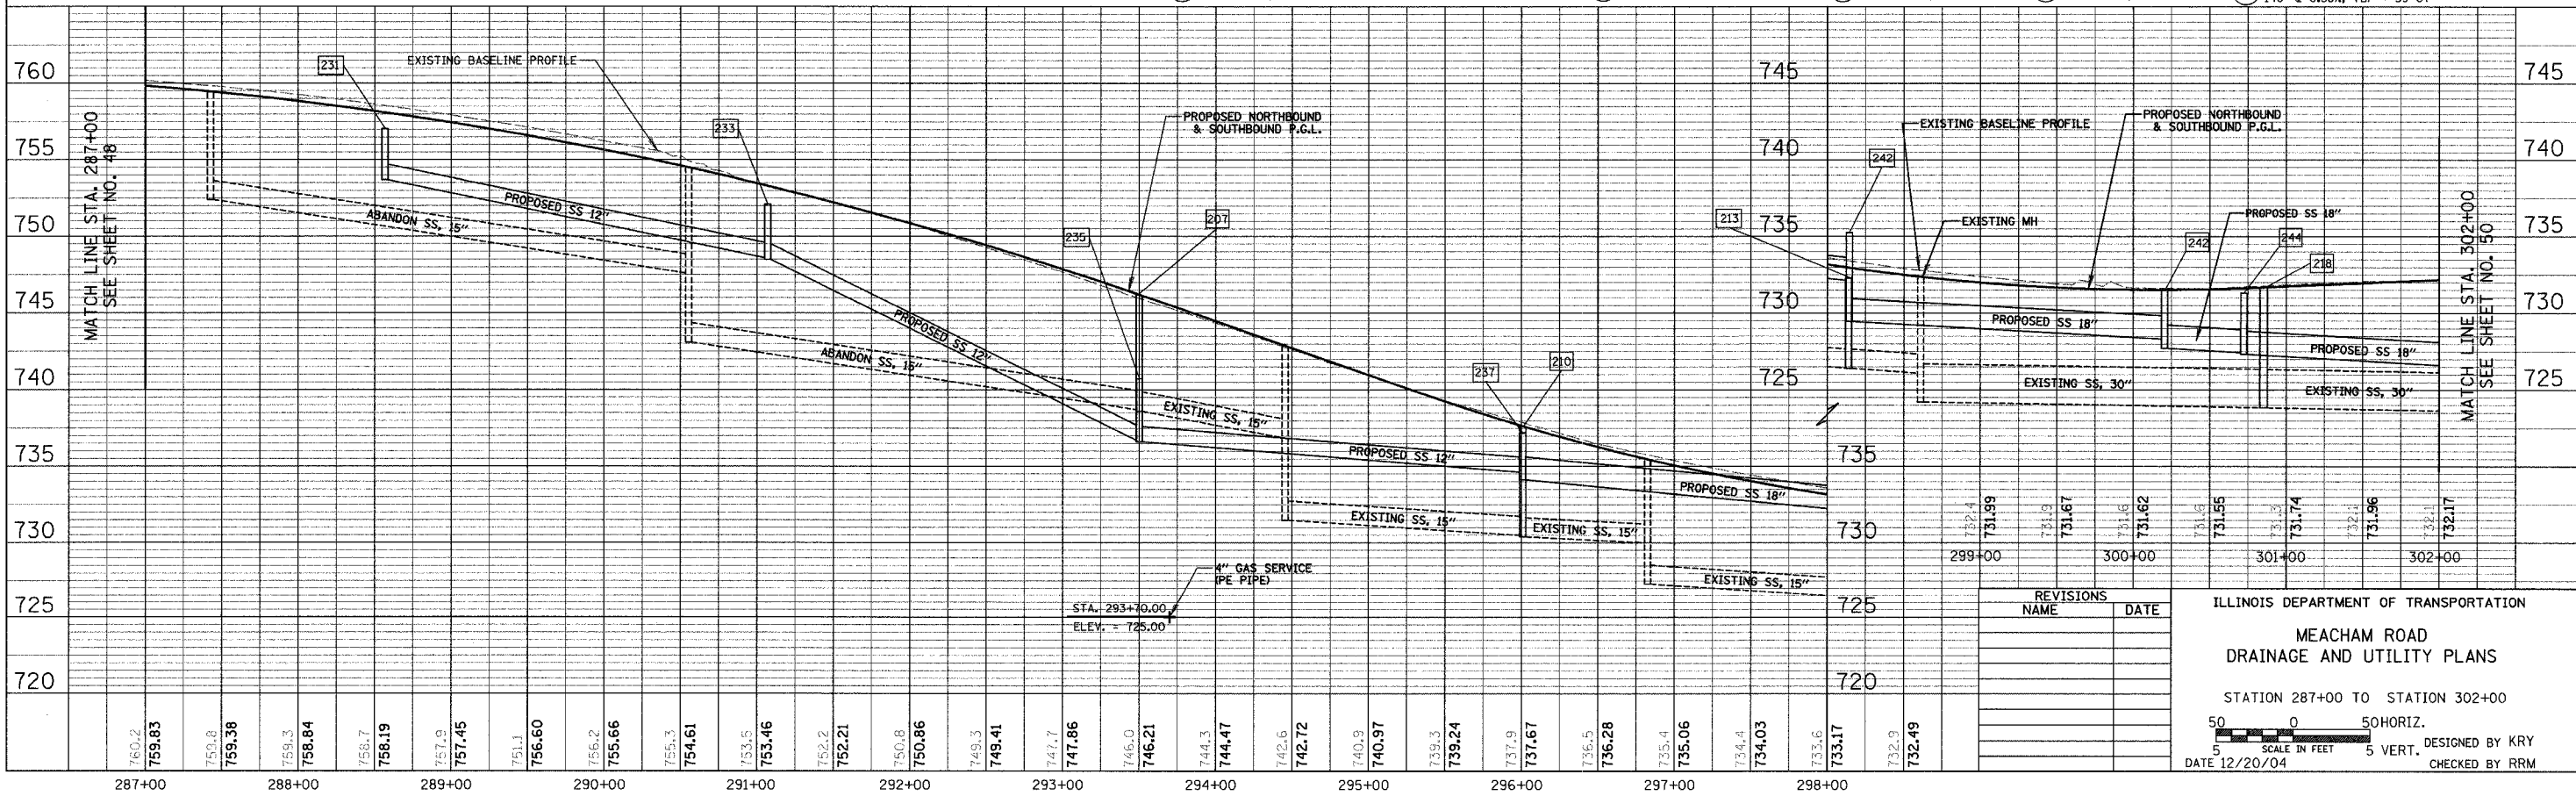


F.A.U. RTE.	SECTION	COUNTY	TOTAL SHEETS	SHEET NO.
2585	00-00068-01-WR	COOK	145	49
STA. 287+00 TO STA. 302+00				
FED. ROAD DIST. NO. ILLINOIS FED. AID PROJECT				
CONTRACT NUMBER 83785				

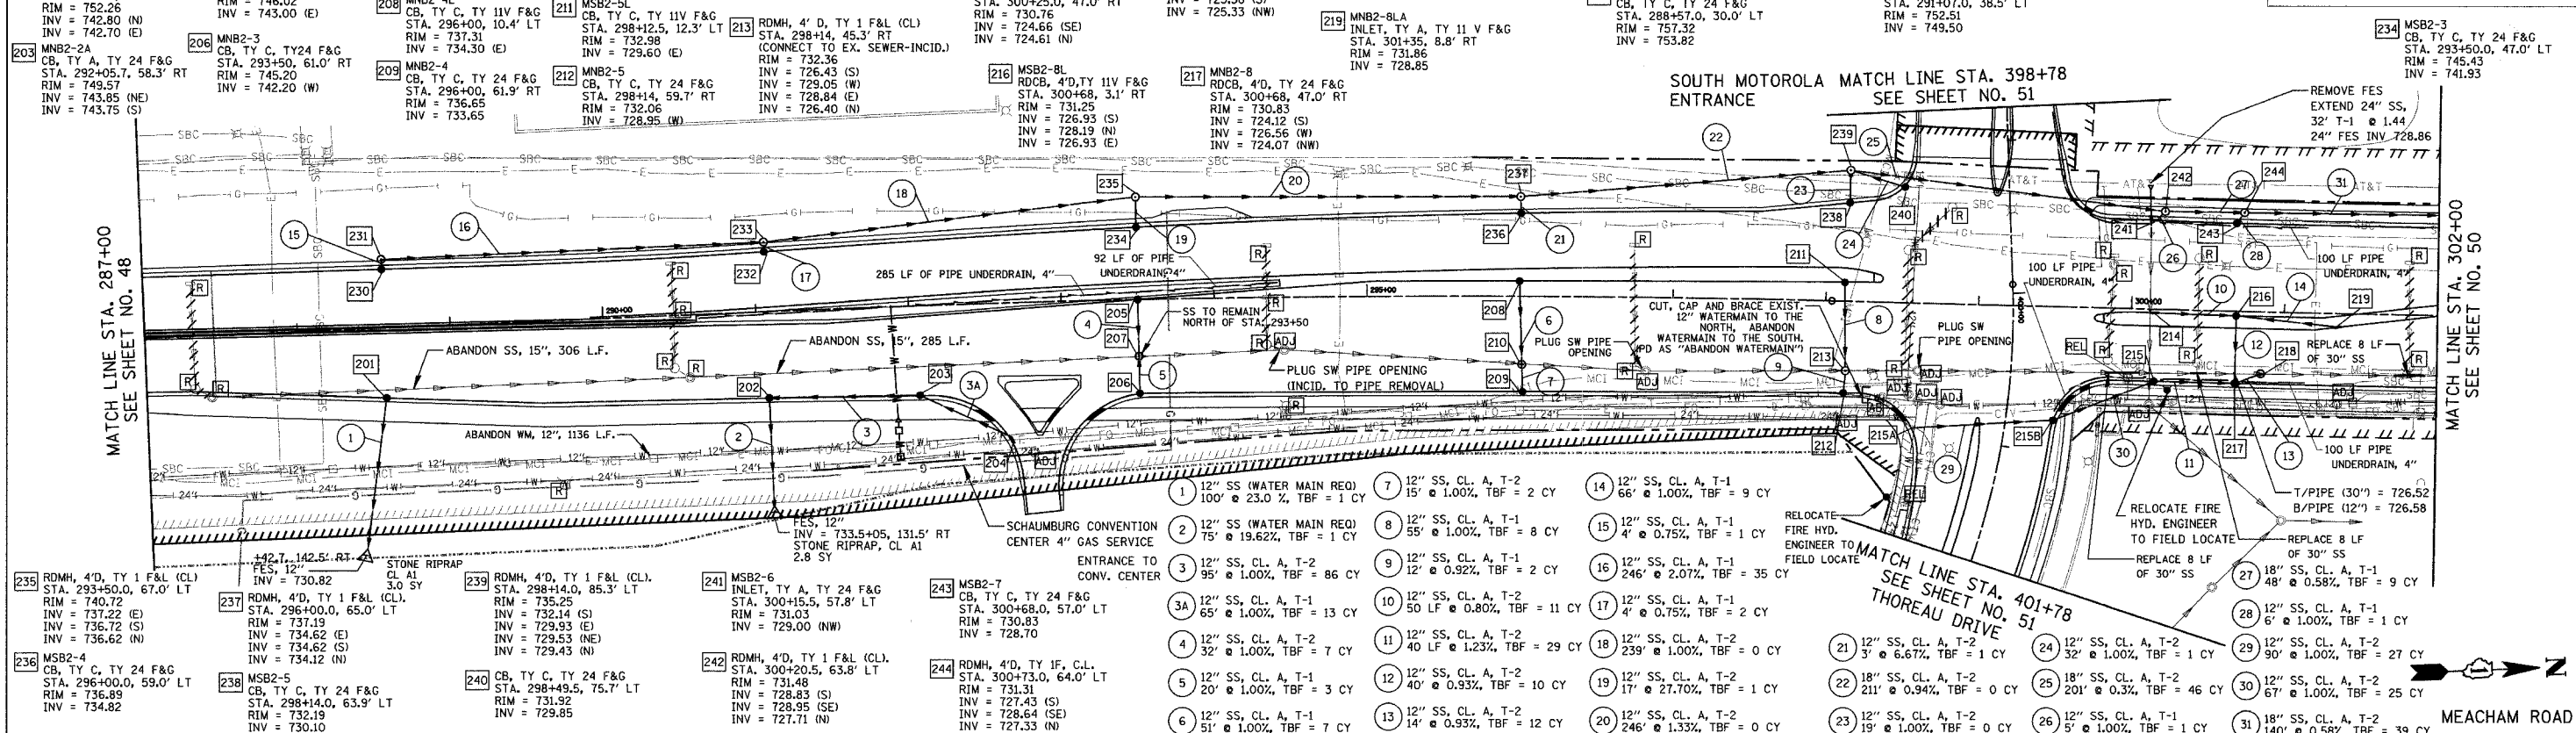

REVISIONS	NAME	DATE

ILLINOIS DEPARTMENT OF TRANSPORTATION
MEACHAM ROAD DRAINAGE AND UTILITY PLANS
 STATION 287+00 TO STATION 302+00
 50 HORIZ. SCALE IN FEET 5 VERT. SCALE IN FEET
 DATE 12/20/04 DESIGNED BY KRY CHECKED BY RRM