


F.A.I.	SECTION	COUNTY	TOTAL SHEETS	SHEET NO.
57	1919.2B	COOK	119	33
FED. ROAD DIST. NO.		ILLINOIS	FED. AID PROJECT	

CONTRACT 60371

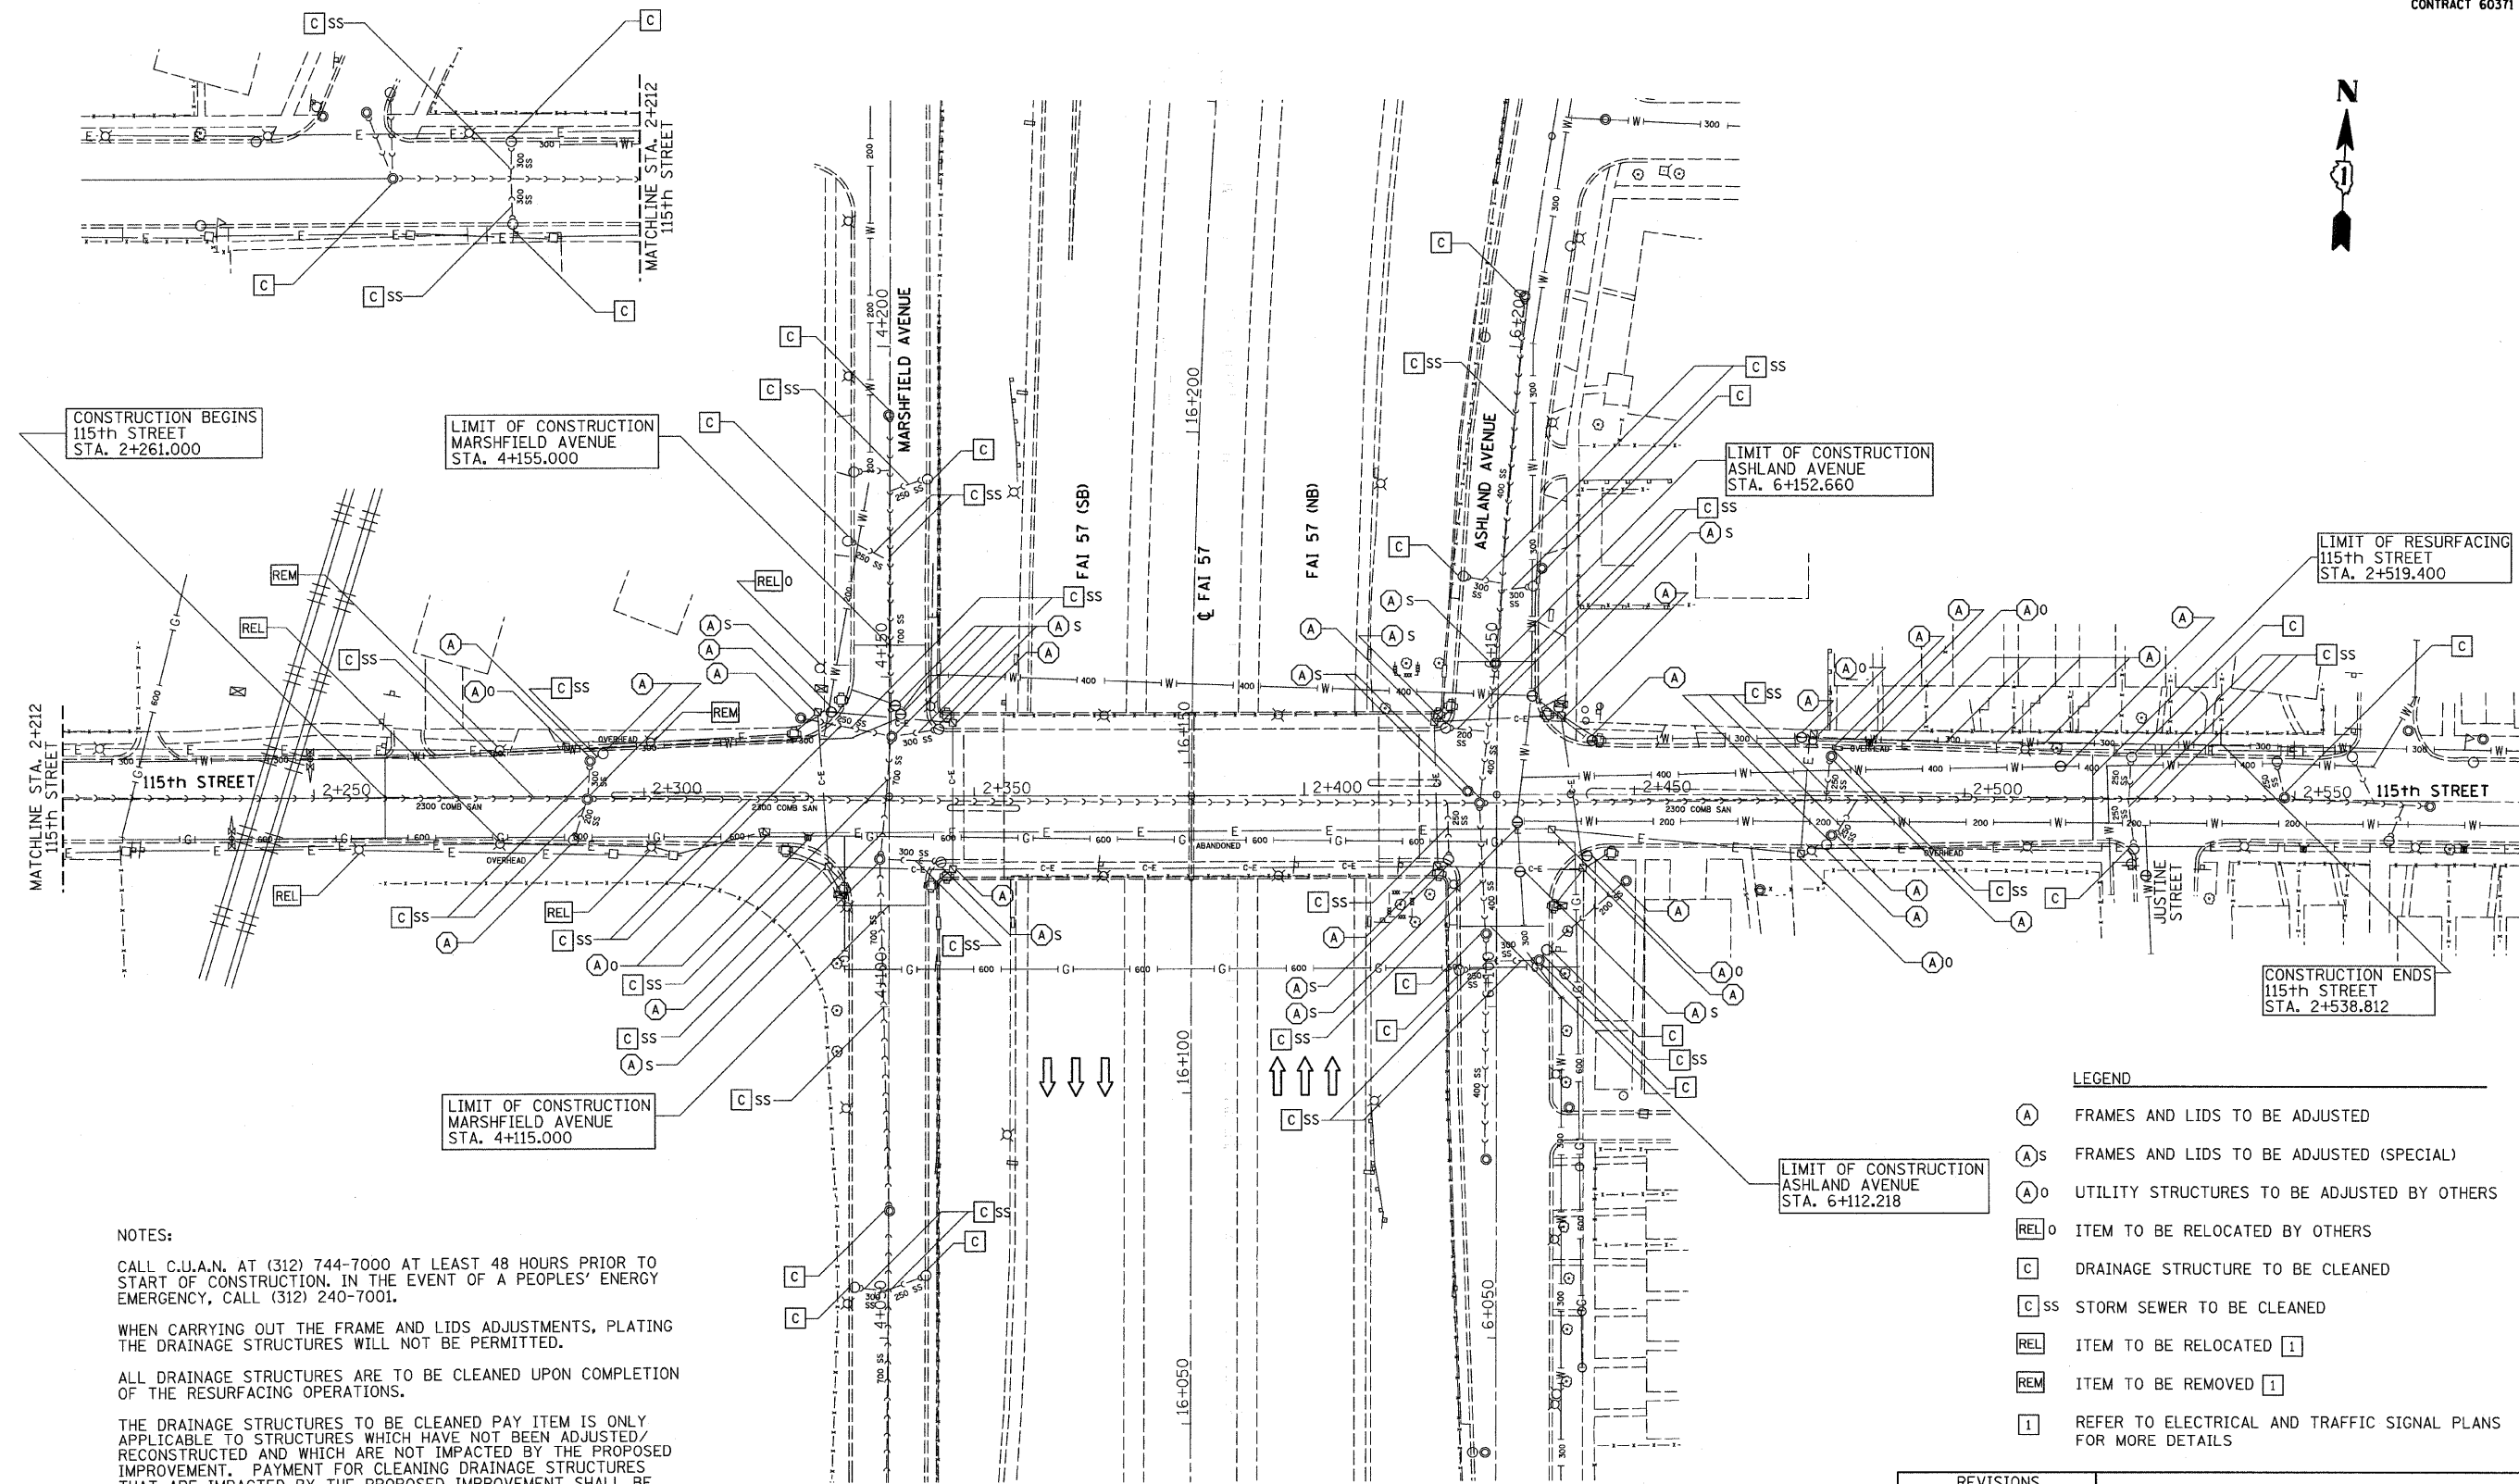

CONSTRUCTION BEGINS
115th STREET
STA. 2+261.000

LIMIT OF CONSTRUCTION
MARSHFIELD AVENUE
STA. 4+155.000

LIMIT OF CONSTRUCTION
ASHLAND AVENUE
STA. 6+152.660

LIMIT OF RESURFACING
115th STREET
STA. 2+519.400

LIMIT OF CONSTRUCTION
MARSHFIELD AVENUE
STA. 4+115.000

LIMIT OF CONSTRUCTION
ASHLAND AVENUE
STA. 6+112.218

CONSTRUCTION ENDS
115th STREET
STA. 2+538.812

NOTES:

CALL C.U.A.N. AT (312) 744-7000 AT LEAST 48 HOURS PRIOR TO START OF CONSTRUCTION. IN THE EVENT OF A PEOPLES' ENERGY EMERGENCY, CALL (312) 240-7001.

WHEN CARRYING OUT THE FRAME AND LIDS ADJUSTMENTS, PLATING THE DRAINAGE STRUCTURES WILL NOT BE PERMITTED.

 
ALL DRAINAGE STRUCTURES ARE TO BE CLEANED UPON COMPLETION OF THE RESURFACING OPERATIONS.

THE DRAINAGE STRUCTURES TO BE CLEANED PAY ITEM IS ONLY APPLICABLE TO STRUCTURES WHICH HAVE NOT BEEN ADJUSTED/RECONSTRUCTED AND WHICH ARE NOT IMPACTED BY THE PROPOSED IMPROVEMENT. PAYMENT FOR CLEANING DRAINAGE STRUCTURES THAT ARE IMPACTED BY THE PROPOSED IMPROVEMENT SHALL BE INCLUDED IN THE PAY ITEM FOR STRUCTURE ADJUSTMENT.

FOR FIRE HYDRANTS TO BE RELOCATED BY THE CITY OF CHICAGO, THE CONTRACTOR AND RESIDENT ENGINEER SHALL CONTACT AND COORDINATE WITH THE CITY OF CHICAGO DEPARTMENT OF WATER MANAGEMENT AT (312) 742-5919.

LEGEND

- (A) FRAMES AND LIDS TO BE ADJUSTED
- (A)S FRAMES AND LIDS TO BE ADJUSTED (SPECIAL)
- (A)O UTILITY STRUCTURES TO BE ADJUSTED BY OTHERS
- REL O ITEM TO BE RELOCATED BY OTHERS
- C DRAINAGE STRUCTURE TO BE CLEANED
- C SS STORM SEWER TO BE CLEANED
- REL ITEM TO BE RELOCATED [1]
- REM ITEM TO BE REMOVED [1]
- [1] REFER TO ELECTRICAL AND TRAFFIC SIGNAL PLANS FOR MORE DETAILS



REVISIONS	
NAME	DATE

ILLINOIS DEPARTMENT OF TRANSPORTATION
EXISTING DRAINAGE AND UTILITY PLAN
115th STREET

DRAWN BY: PRH
CHECKED BY: JMH

DATE: JANUARY 16, 2009

COLLINS ENGINEERS
123 North Wacker Drive
Suite 300
Chicago, IL 60606
(312) 704-9300
www.collinseng.com
ILLINOIS PROFESSIONAL DESIGN FIRM LICENSE NO. 184-000995