


F.A.P. RTE.	SECTION	COUNTY	TOTAL SHEETS	SHEET NO.
595	1-3-K	ROCK ISLAND	476	218
STA.		TO STA.		
FED. ROAD DIST. NO.	ILLINOIS	FED. AID PROJECT		

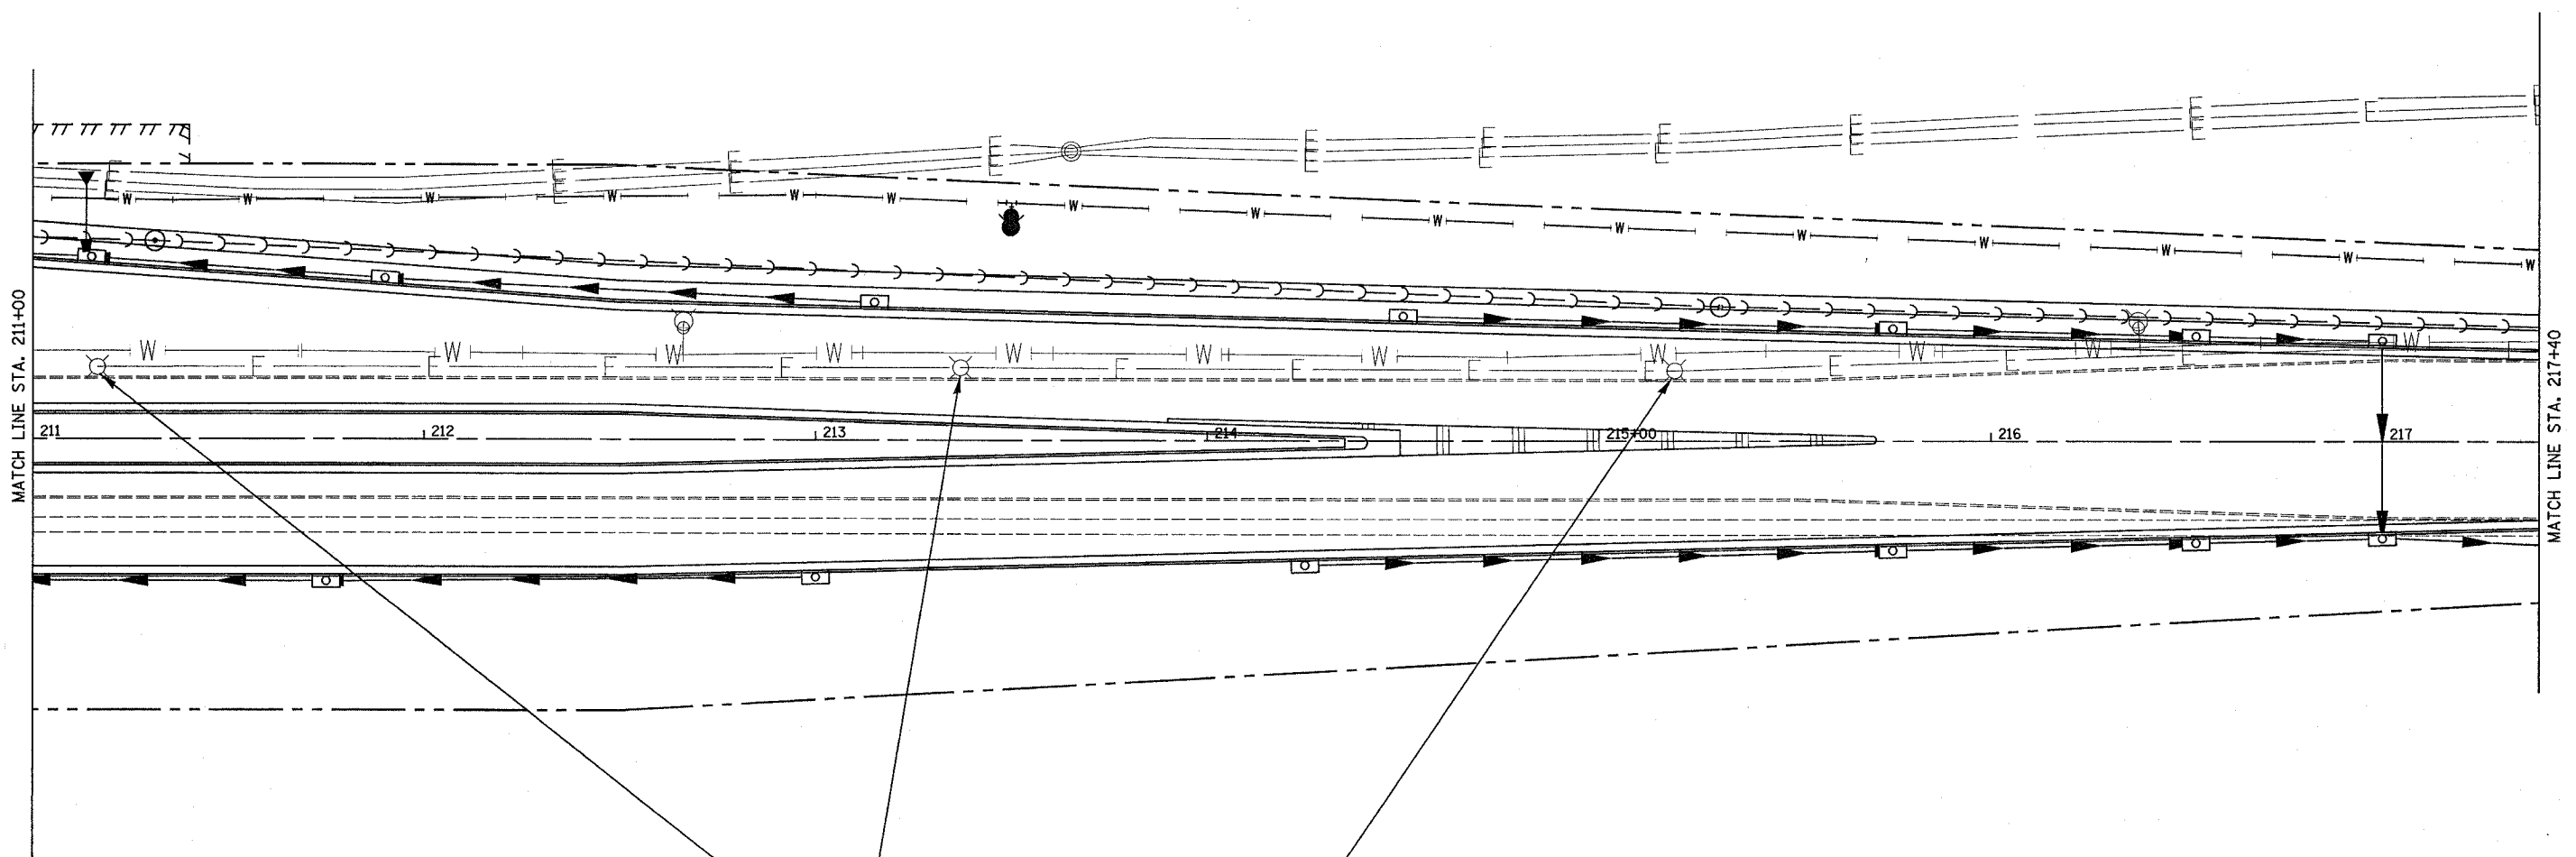

EXISTING STREET LIGHT POLE
AND LUMINAIRE TO BE REMOVED
AND RELOCATED

LIGHTING NOTES

1. GROUND RODS SHALL BE INSTALLED IN ALL LIGHT BASES.
2. ALL POLES SHALL BE CONNECTED TO ALTERNATE SIDES OF CIRCUIT.
3. EXISTING LIGHTING CABLES SHALL BE ABANDONED IN PLACE.

LEGEND

- PROPOSED UNIT DUCT LIGHTING CABLE
- ⊗ RELOCATED LIGHT POLE
- ⊗ EXISTING LIGHT POLE TO BE RELOCATED

NOTES: SEE SHEET 217 FOR LIGHTING PLAN