



FILE NAME = D168122-SHT-DRAIN03.dgn	USER NAME = EricG	DESIGNED - YSK	REVISED -
PLOT SCALE = 1:50	CHECKED - E.JG	DRAWN - YSK	REVISED -
PLOT DATE = 12/9/2011	DATE - 12/09/11	CHECKED - E.JG	REVISED -

**STATE OF ILLINOIS
 DEPARTMENT OF TRANSPORTATION**

DRAINAGE AND UTILITY PLAN

SCALE: 1"=50' SHEET NO. 3 OF 5 SHEETS STA. 115+00 TO STA. 129+00

F.A.P. RTE.	SECTION	COUNTY	TOTAL SHEETS	SHEET NO.
347	LY (HB & VB)	DUPAGE/KANE	421	70
DU-3		CONTRACT NO. 60122		
FED. ROAD DIST. NO. 1 ILLINOIS FED. AID PROJECT				

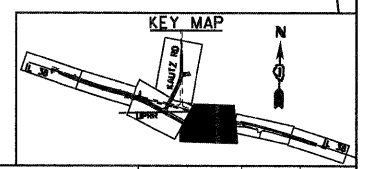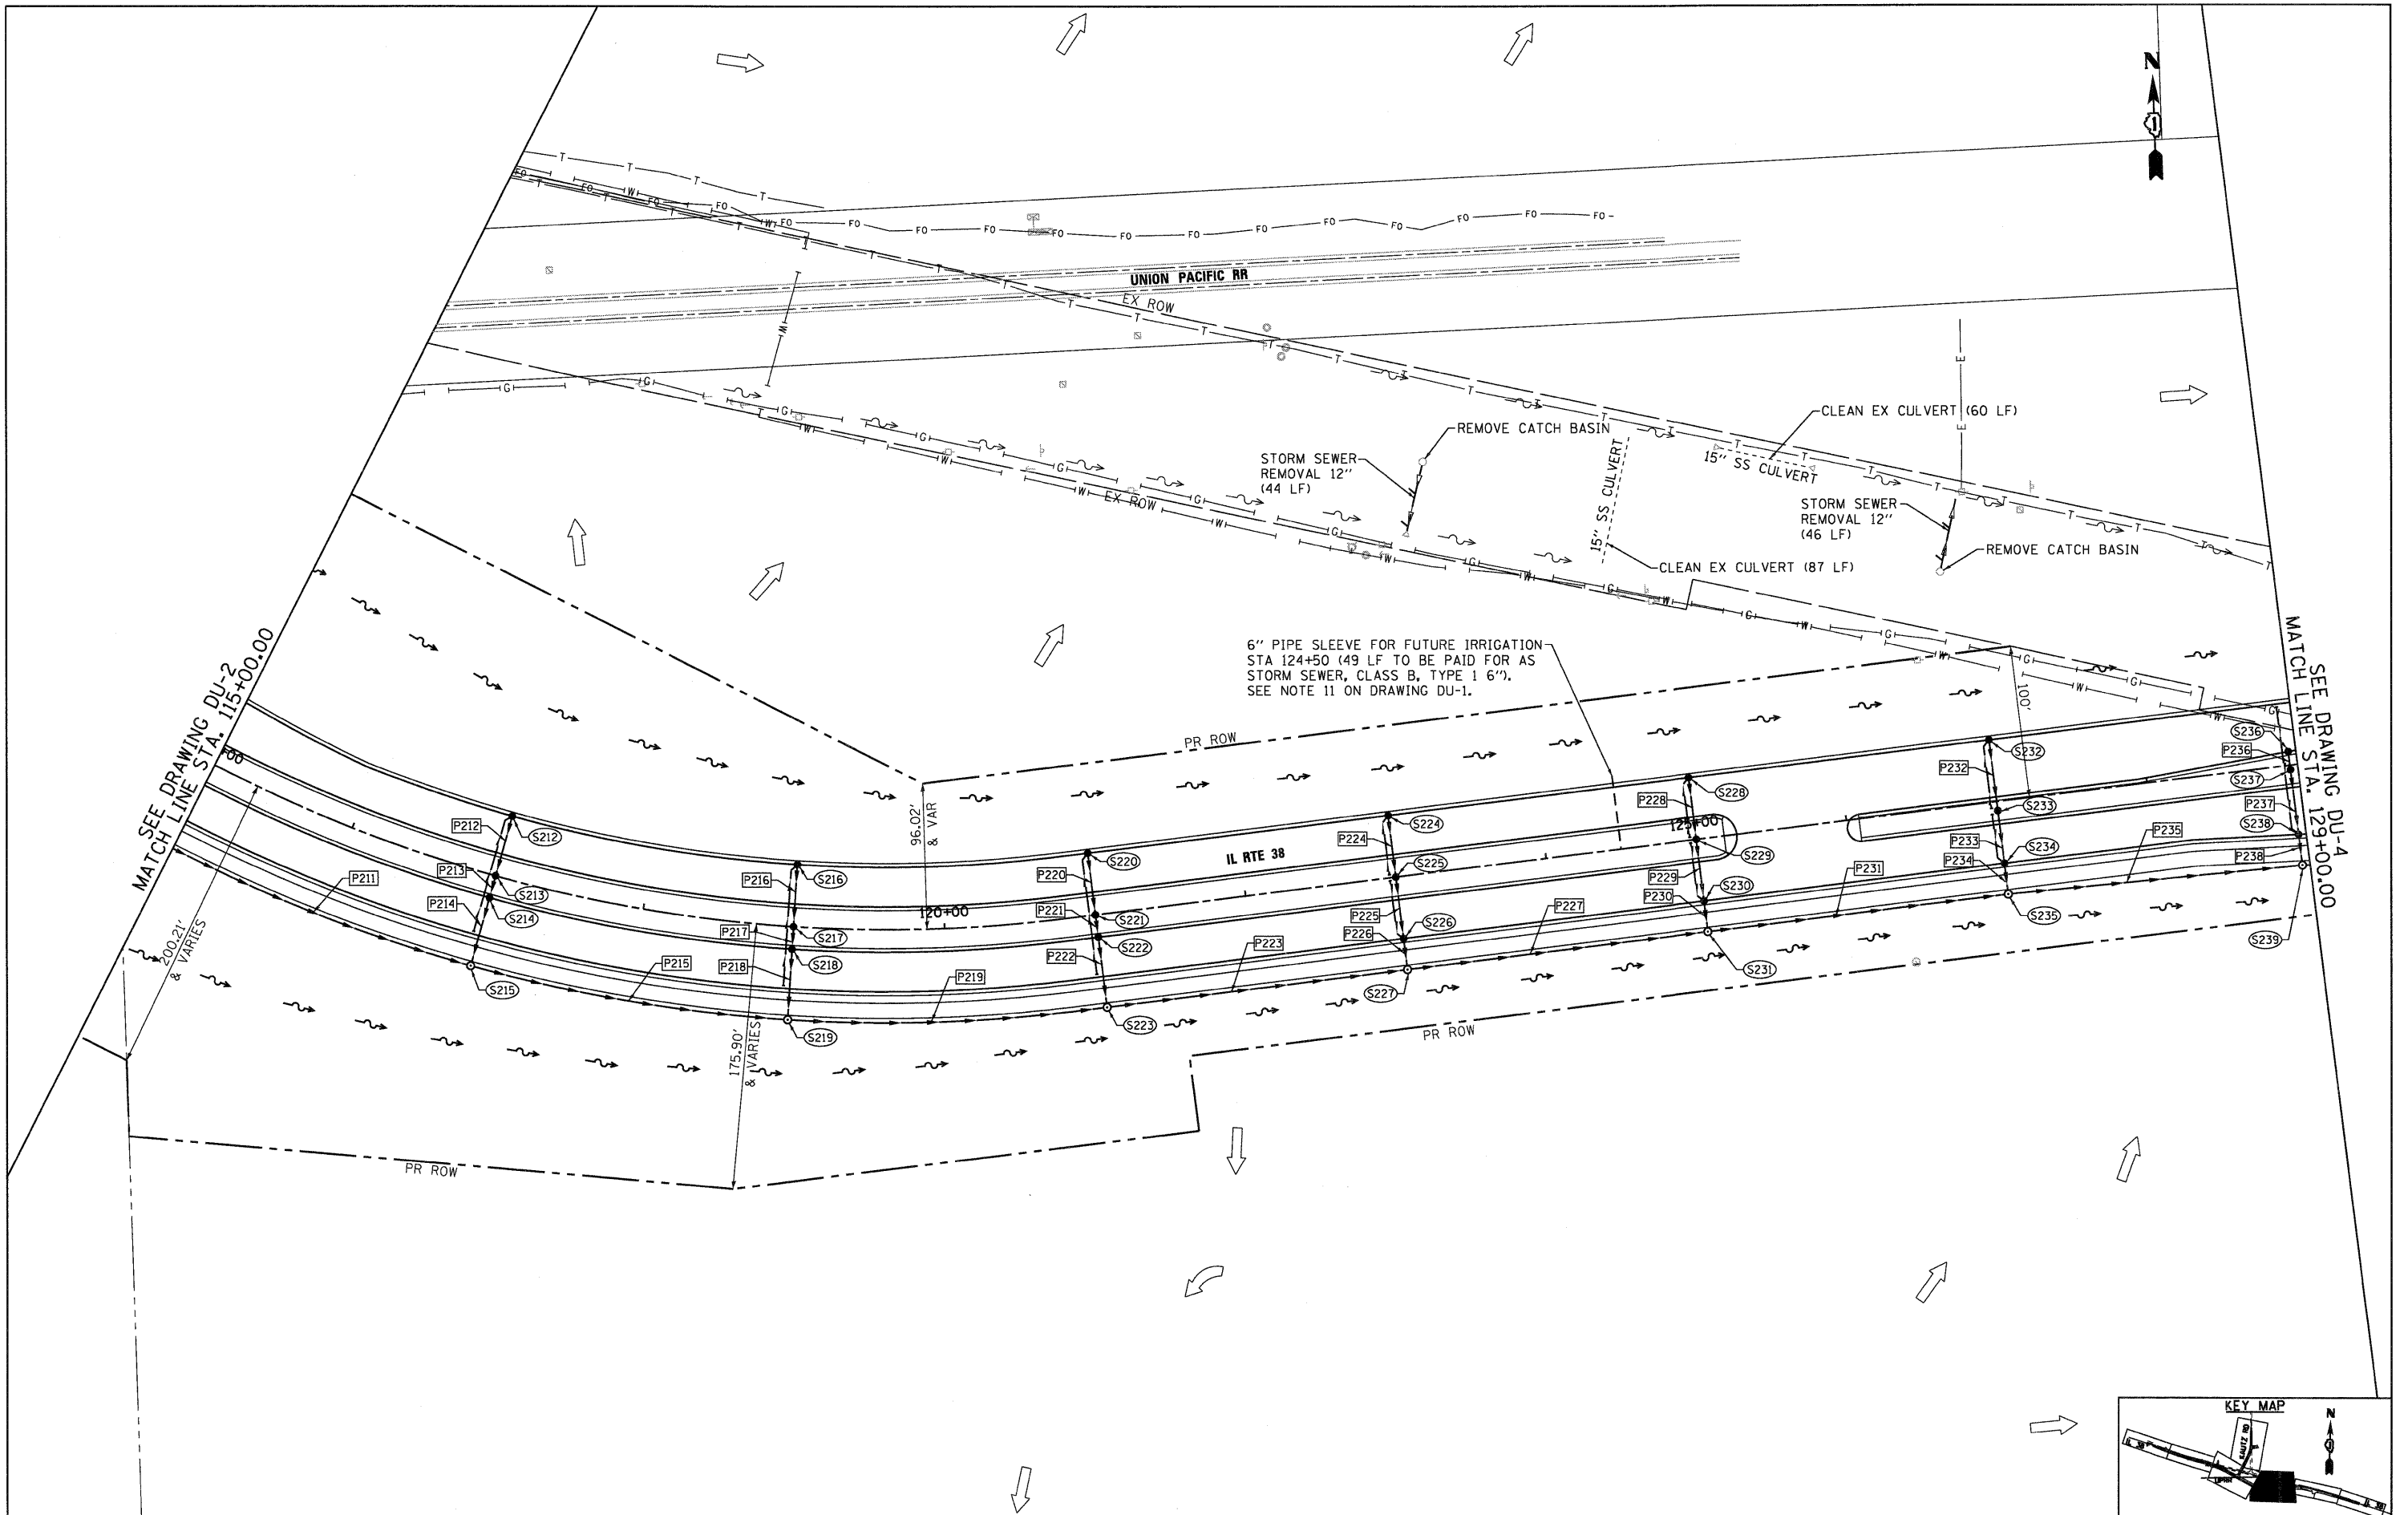

MATCH SEE DRAWING DU-2
 MATCH LINE STA. 115+00.00

SEE DRAWING DU-4
 MATCH LINE STA. 129+00.00

6" PIPE SLEEVE FOR FUTURE IRRIGATION
 STA 124+50 (49 LF TO BE PAID FOR AS
 STORM SEWER, CLASS B, TYPE 1 6").
 SEE NOTE 11 ON DRAWING DU-1.