


INSIDE ELEVATION OF SOUTH PARAPET

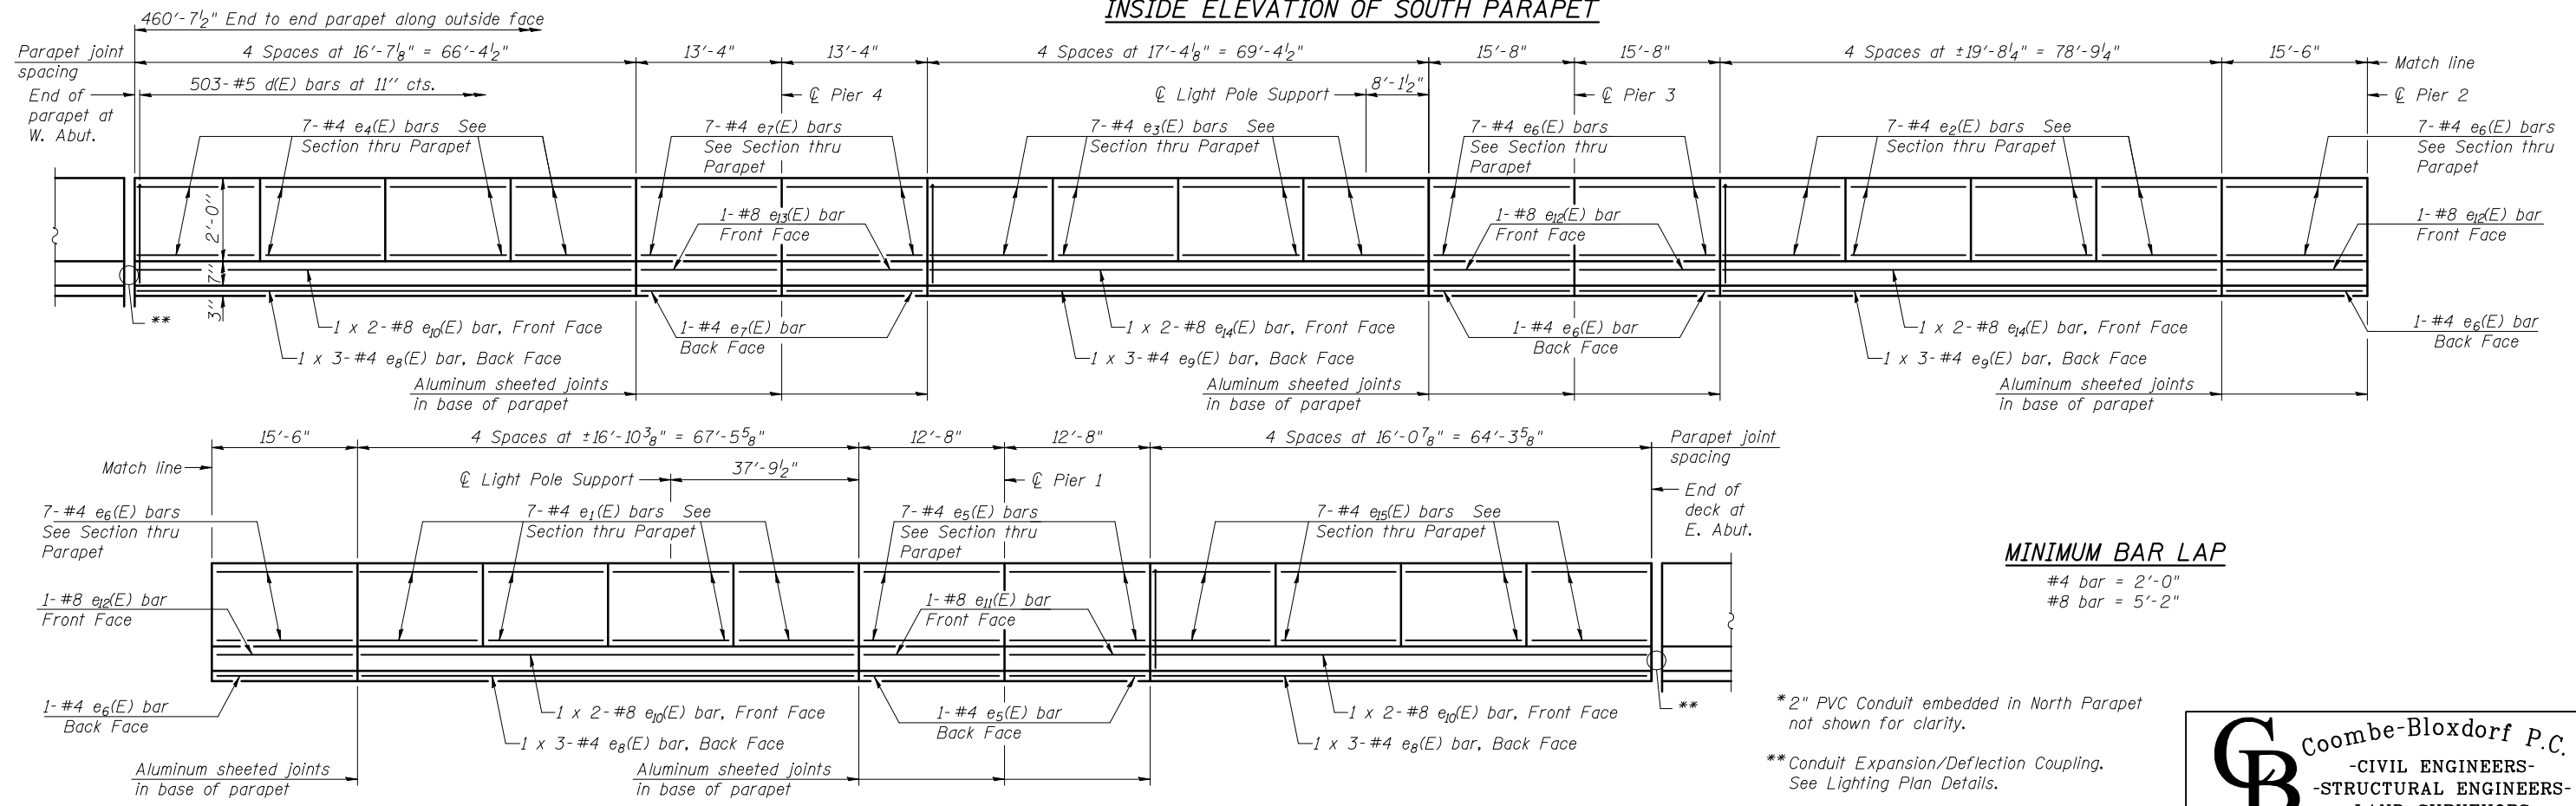

INSIDE ELEVATION OF NORTH PARAPET*

MINIMUM BAR LAP
 #4 bar = 2'-0"
 #8 bar = 5'-2"

*2" PVC Conduit embedded in North Parapet not shown for clarity.
 ** Conduit Expansion/Deflection Coupling. See Lighting Plan Details.

FILE NAME =
 *FILEL#

USER NAME = *USER*
 CHECKED - MCB
 DRAWN - MML
 PLOT DATE = *DATE*

DESIGNED - GB
 CHECKED - MCB
 DRAWN - MML
 CHECKED - MCB

REVISED -
 REVISED -
 REVISED -
 REVISED -

**STATE OF ILLINOIS
 DEPARTMENT OF TRANSPORTATION**

**SUPERSTRUCTURE DETAILS
 STRUCTURE NO. 039-0075 (EB)**

SHEET NO. 16 OF 53 SHEETS

CB Coombe-Bloxdorf P.C.
 - CIVIL ENGINEERS -
 - STRUCTURAL ENGINEERS -
 - LAND SURVEYORS -
 Design Firm License No. 184-002703

F.A.P. RTE.	SECTION	COUNTY	TOTAL SHEETS	SHEET NO.
331	(12-1)B-1	JACKSON	200	75

CONTRACT NO. 78056
 ILLINOIS FED. AID PROJECT