

INDEX OF SHEETS

SHEET NO.	DESCRIPTION
1	TITLE SHEET
2	GENERAL NOTES
3	HIGHWAY STANDARDS AND LEGEND
4	SUMMARY OF QUANTITIES
5-12	LIGHTING PLANS
13-14	PARKING LOT PLANS

**STATE OF ILLINOIS
DEPARTMENT OF TRANSPORTATION
DIVISION OF HIGHWAYS**

**PLANS FOR PROPOSED
STREET IMPROVEMENTS**

PLAN 1 INCH = 20 FEET
 PROFILE HORIZ. 1 INCH = 20 FEET
 PROFILE VERT. 1 INCH = 5 FEET
 CROSS SECTIONS HORIZ. 1 INCH = 10 FEET
 CROSS SECTIONS VERT. 1 INCH = 5 FEET

**TOWN OF NORMAL
MCLEAN COUNTY, ILLINOIS
SECTION: 10-00242-00-LT
PROJECT NO. TE-00D5(095)
JOB NO. C-95-321-11**



FUNDING: ENHANCEMENT & LOCAL MATCH

**COLLEGE AVENUE / MULBERRY STREET
ROADWAY LIGHTING**

F.A.U. RTE.	SECTION	COUNTY	TOTAL SHEETS	SHEET NO.
	10-00242-00-LT	MCLEAN	14	1
		ILLINOIS	CONTRACT NO. 91460	




ILLINOIS HIGHWAY STANDARD DRAWINGS
(SEE SHEET NO. 3)

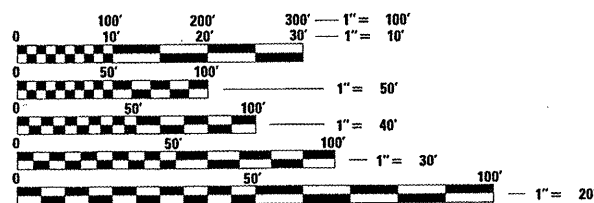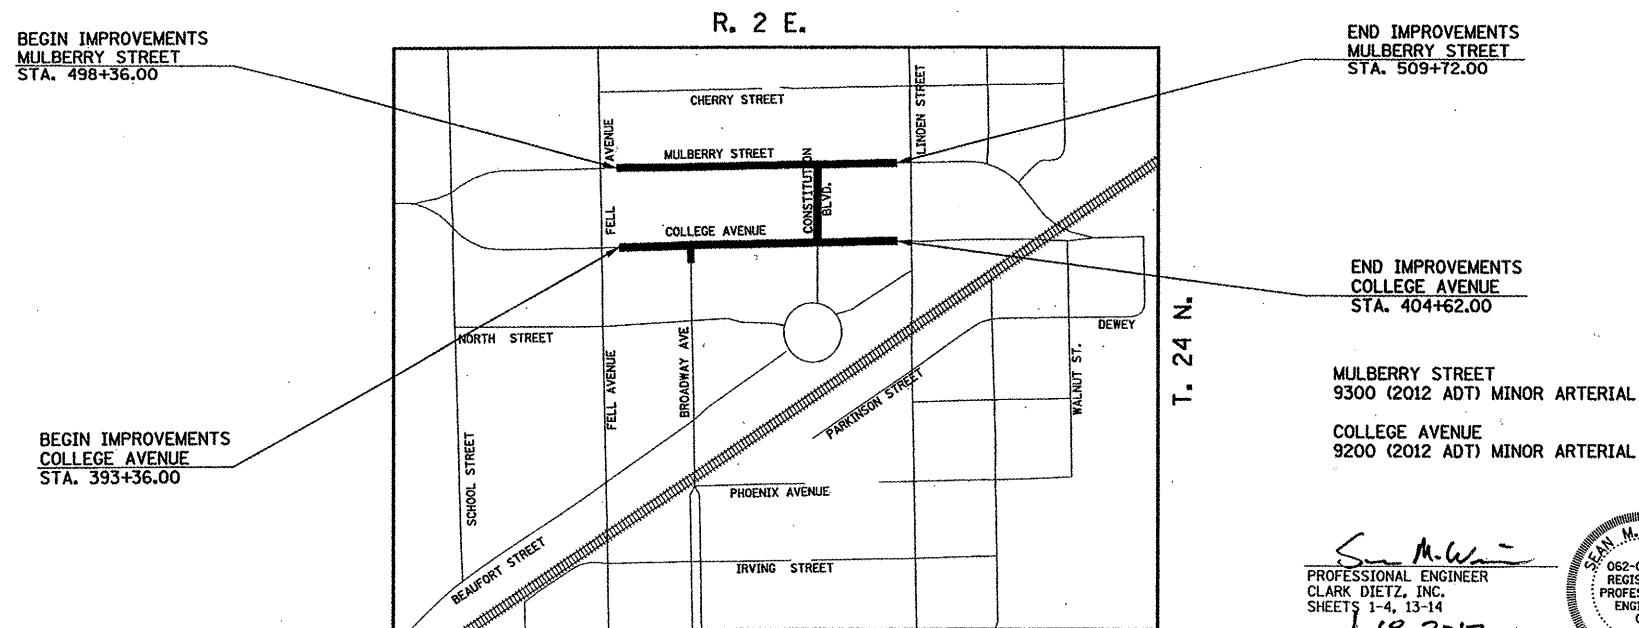

FULL SIZE PLANS HAVE BEEN PREPARED USING STANDARD ENGINEERING SCALES. REDUCED SIZED PLANS WILL NOT CONFORM TO STANDARD SCALES. IN MAKING MEASUREMENTS ON REDUCED PLANS, THE ABOVE SCALES MAY BE USED.

J.U.L.I.E.
JOINT UTILITY LOCATION INFORMATION FOR EXCAVATION
1-800-892-0123 OR 811

CONTRACT NO. 91460

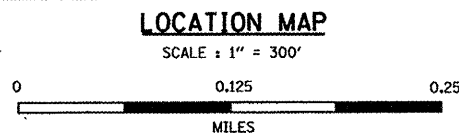

TOTAL LENGTH OF MULBERRY STREET IMPROVEMENT = 1,136 FEET = 0.22 MILES
 TOTAL LENGTH OF COLLEGE AVENUE IMPROVEMENT = 1,126 FEET = 0.21 MILES
 TOTAL LENGTH OF IMPROVEMENTS = 2,262 FEET = 0.43 MILES

TOWN OF NORMAL

APPROVED January 18 2012
[Signature]
 TOWN ENGINEER

PASSED 1/27 2012
[Signature]
 DISTRICT FIVE ENGINEER OF LOCAL ROADS & STREETS

Releasing For Bid Based on Limited Review January 27 2012
[Signature]
 DEPUTY DIRECTOR OF HIGHWAYS, REGION THREE ENGINEER

STATE OF ILLINOIS
DEPARTMENT OF TRANSPORTATION

**PRINTED BY THE AUTHORITY
OF THE STATE OF ILLINOIS**

[Signature]
 PROFESSIONAL ENGINEER
 CLARK DIETZ, INC.
 SHEETS 1-4, 13-14
 DATE: 1.18.2012
 LICENSE EXPIRES 11-30-13

[Signature]
 PROFESSIONAL ENGINEER
 CLARK DIETZ, INC.
 SHEETS 5-12
 DATE: 1/18/2012
 LICENSE EXPIRES 11-30-13

Clark Dietz
ENGINEERS

125 WEST CHURCH STREET
 CHAMPAIGN, IL 61820
 PHONE : 217.373.8900
 FAX : 217.373.8923