


F.A.I. RTE.	SECTION	COUNTY	TOTAL SHEETS	SHEET NO.
80	(32, 47-4)K	KENDALL/GRUNDY	243	138
STA.	TO STA.			
FED. ROAD DIST. NO.	ILLINOIS	FED. AID PROJECT		

CONTRACT NO. 66294

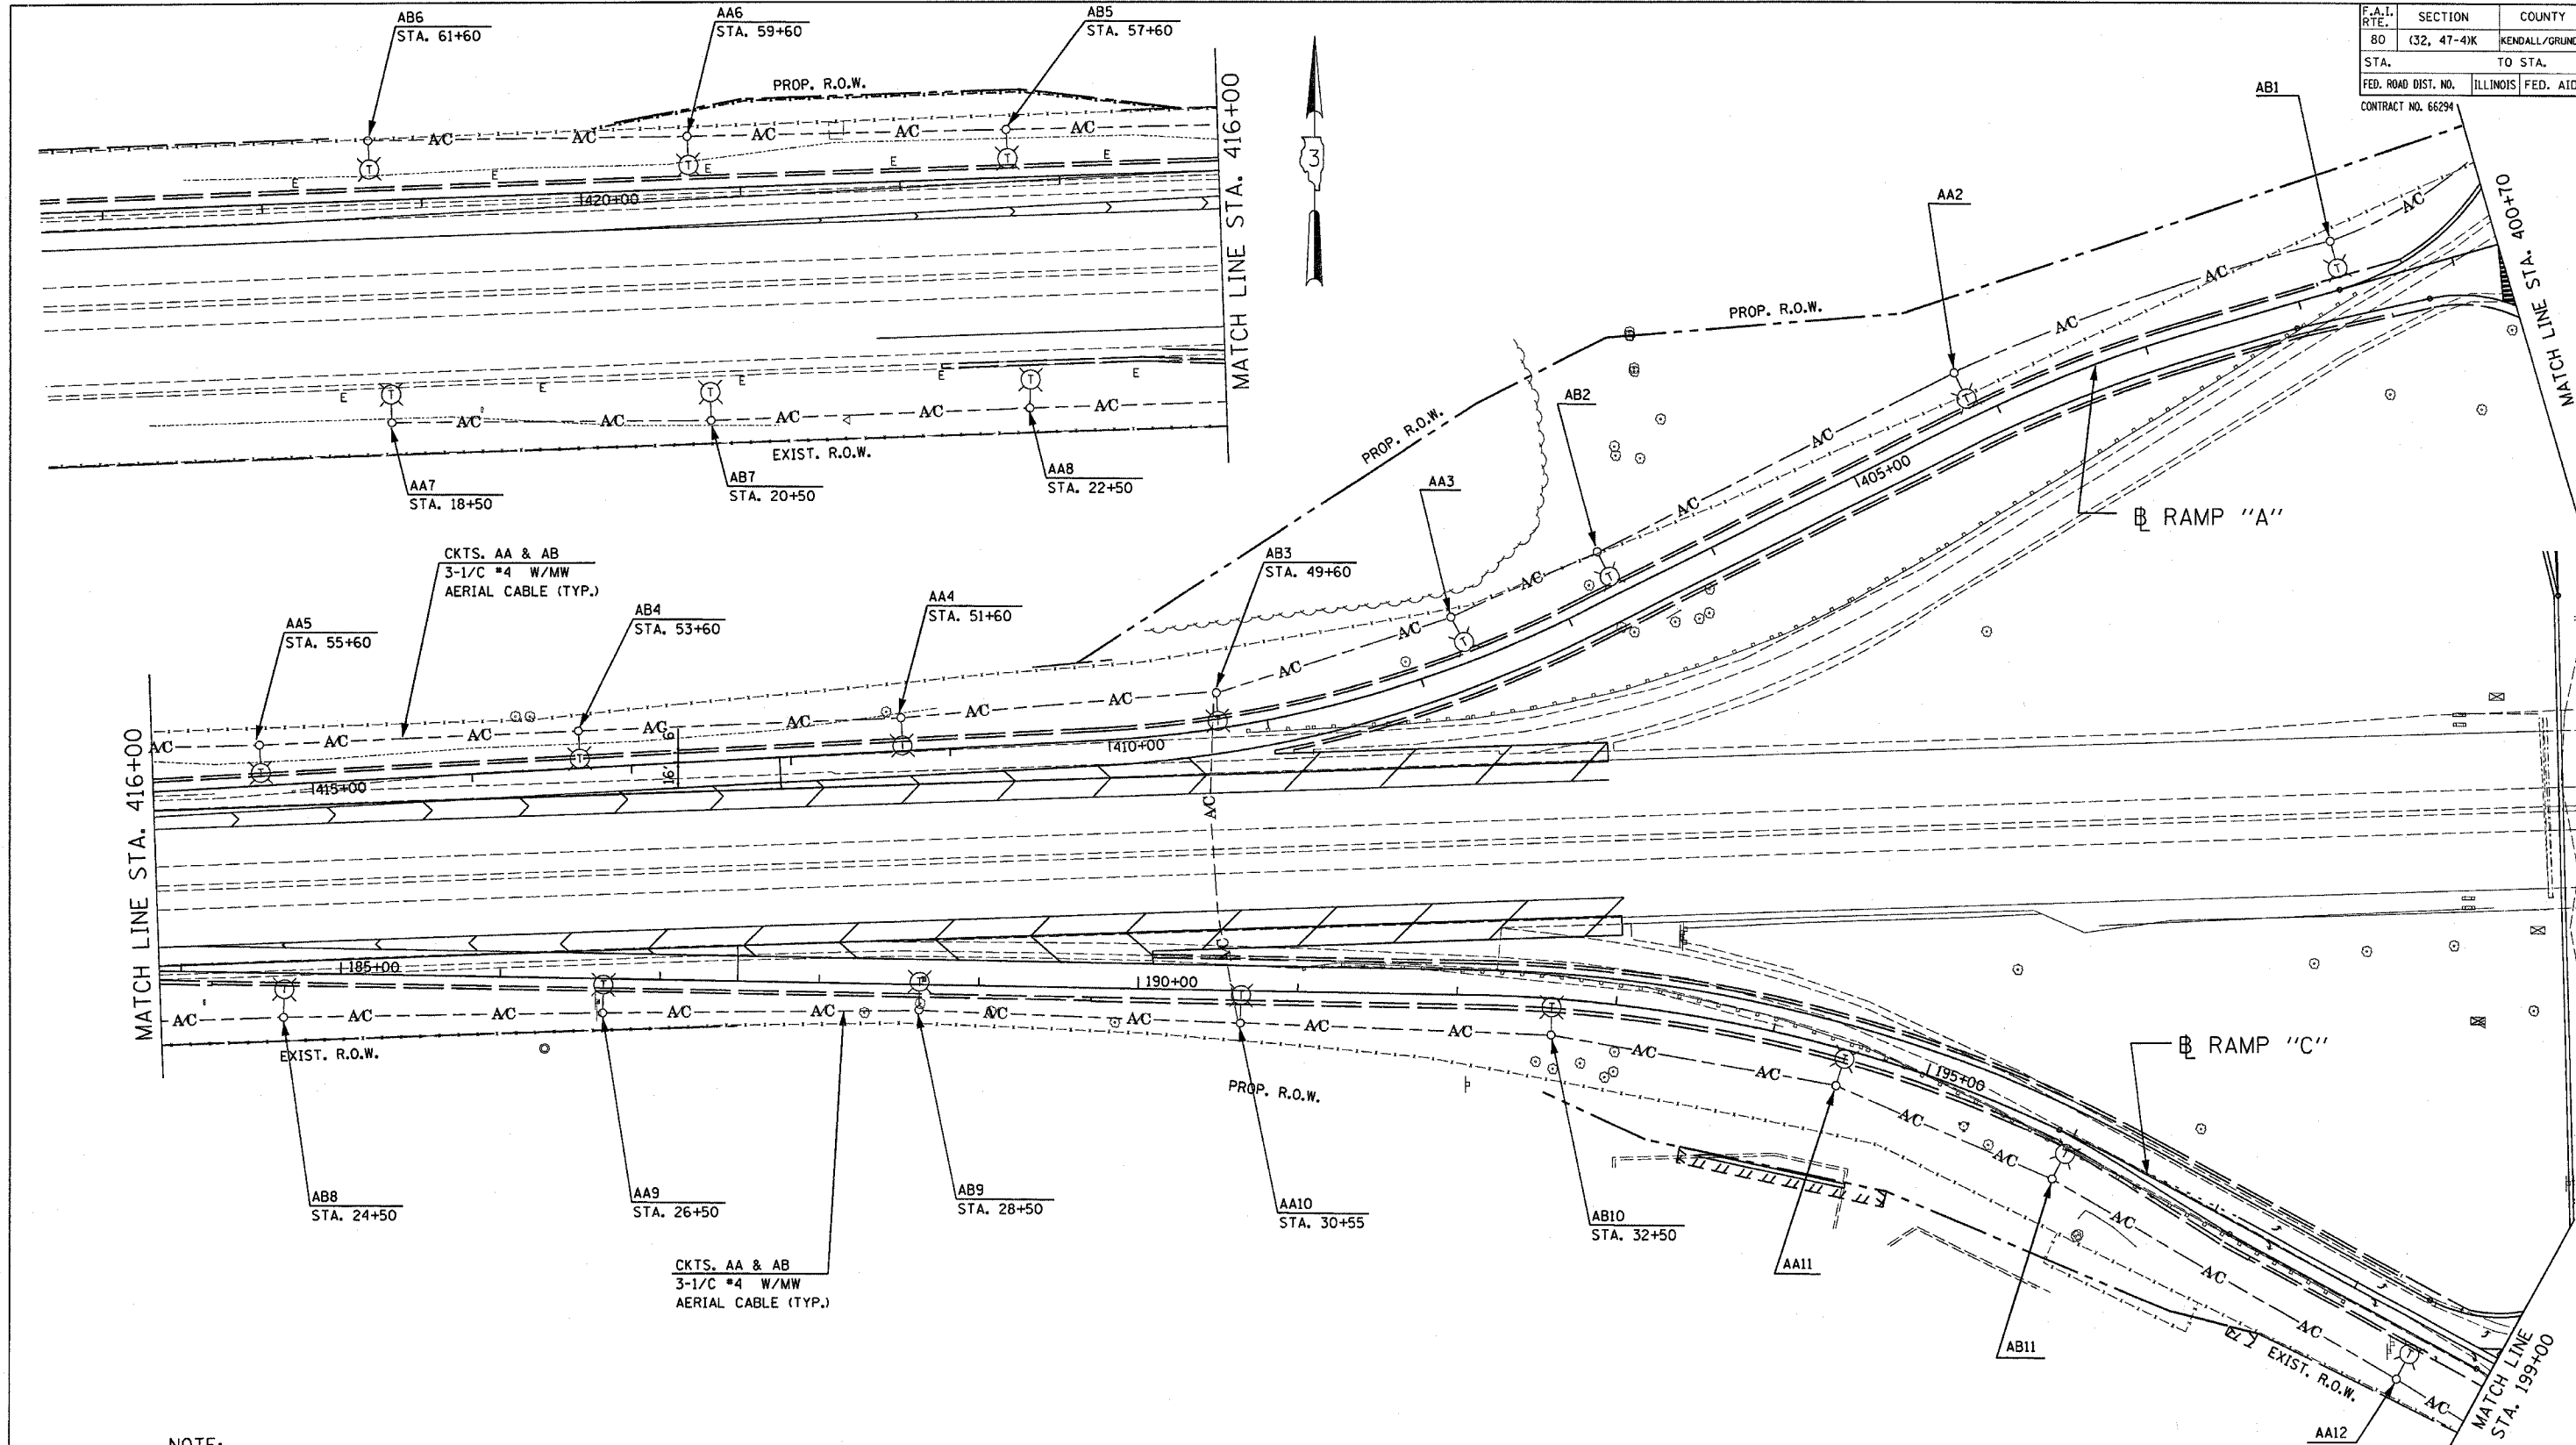

NOTE:
ALL EXISTING LIGHT POLES SHOWN ON THIS DRAWING WERE INSTALLED IN PRIOR CONSTRUCTION STAGES. SEE THE OTHER TEMPORARY LIGHTING PLAN SHEETS FOR MORE INFORMATION.

REVISED BY IDOT

GA GANDHI AND ASSOCIATES, INC.
ENGINEERS AND PLANNERS
6035 N. NORTHWEST HIGHWAY
SUITE 306
CHICAGO, ILLINOIS 60631 TEL. (773) 774-5900

REVISIONS	
NAME	DATE
MJ	4-11-06

ILLINOIS DEPARTMENT OF TRANSPORTATION
FAI ROUTE 80 (I-80 AT MINOOKA INTERCHANGE)
TEMPORARY LIGHTING
RAMP "A" AND RAMP "C"
SHEET 1 OF 2
STAGE 1B, STAGE 2, STAGE 2A, AND STAGE 3
SCALE: 1:50
DATE: 12/9/2005
DRAWN BY: KGP/MAE
CHECKED BY: MAE/PKG

ENTIRE SHEET REVISED 4-11-06 MJ

PER ADDENDUM

PATRICK
ENGINEERING INC.
LISLE, ILLINOIS