


MAR 29, 2006 10:50 AM CAH  
 I:\AIRPORTS\SAVANNA\B26-06RWY\AIRPORT\SHETS\R-14\ELE.DWG - STA. 221+50 TO STA. 229+47.00


TR003

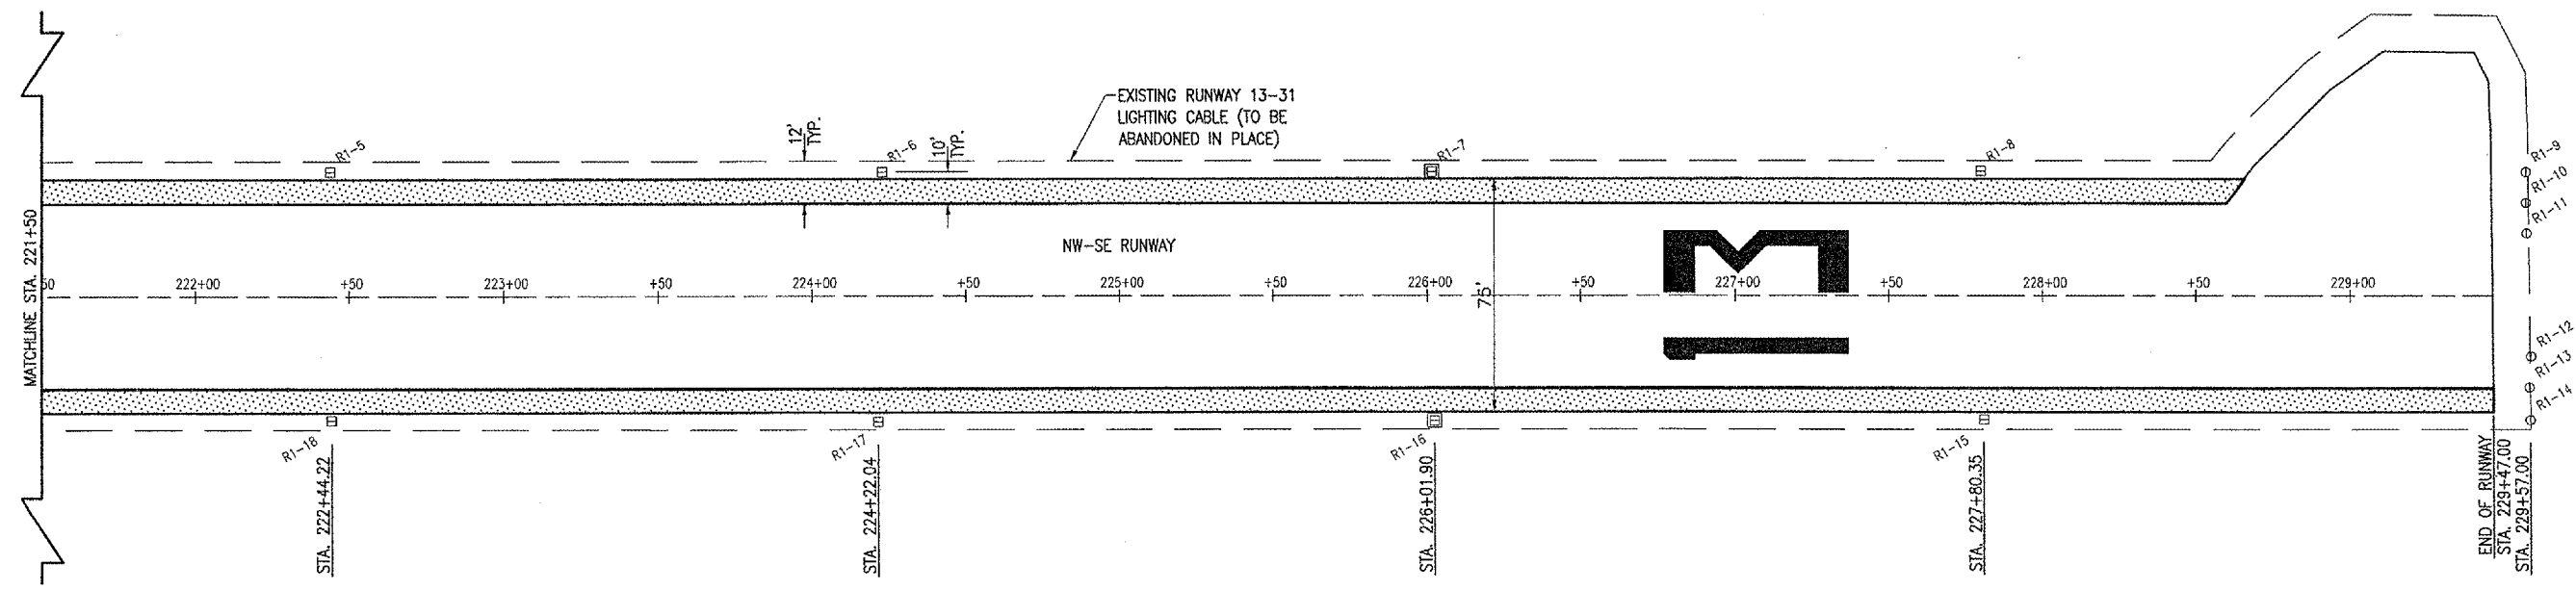

THE LOCATION, SIZE AND TYPE OF MATERIAL OF EXISTING UNDERGROUND UTILITIES INDICATED ON THE PLANS IS NOT REPRESENTED AS BEING ACCURATE, SUFFICIENT OR COMPLETE. IT SHALL BE THE CONTRACTOR'S RESPONSIBILITY TO DETERMINE THE ACTUAL LOCATION OF ALL SUCH FACILITIES, INCLUDING SERVICE CONNECTIONS TO UNDERGROUND UTILITIES. PRIOR TO CONSTRUCTION, THE CONTRACTOR SHALL NOTIFY THE UTILITY COMPANIES OF HIS OPERATIONAL PLANS AND SHALL OBTAIN FROM THE RESPECTIVE UTILITY COMPANIES DETAILED INFORMATION AND ASSISTANCE RELATIVE TO THE LOCATION OF THEIR FACILITIES AND THE WORKING SCHEDULE OF THE COMPANIES FOR REMOVAL OR ADJUSTMENT WHERE REQUIRED. IN THE EVENT AN UNEXPECTED UTILITY INTERFERENCE IS ENCOUNTERED DURING CONSTRUCTION, THE CONTRACTOR SHALL IMMEDIATELY NOTIFY THE UTILITY COMPANY OF JURISDICTION. THE ENGINEER SHALL ALSO BE IMMEDIATELY NOTIFIED. ANY SUCH MAINS AND SERVICES SHALL BE RESTORED TO SERVICE AT ONCE AND PAID FOR BY THE CONTRACTOR AT NO ADDITIONAL COST TO THE CONTRACT.

CALL J.U.L.I.E. FOR UTILITY INFORMATION AT 1-800-892-0123.

- LEGEND**
- EXISTING PAVEMENT
  - PROPOSED PAVEMENT WIDENING
  - EXISTING ELECTRICAL CABLE
  - EXISTING STAKE MOUNTED RUNWAY THRESHOLD LIGHT
  - EXISTING STAKE MOUNTED RUNWAY LIGHT
  - EXISTING BASE MOUNTED RUNWAY LIGHT

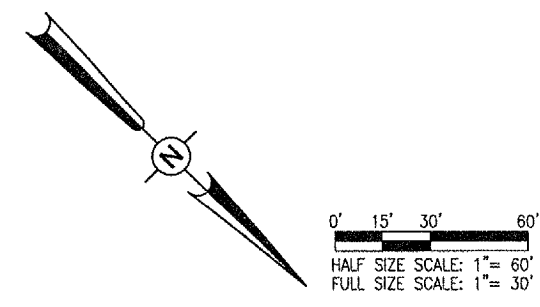

DATE	REVISION	BY

TRI-TOWNSHIP AIRPORT  
 SAVANNA, CARROLL COUNTY  
 ILLINOIS

IL. PROJ.: SF7-3538 A.I.P. PROJ.: 3-17-0091-B12

H&J Project No. 826-08RWYD_0800	
Drawn	R-14.1ELE.DWG
Scale	1" = 30'
Date	10/31/05
LAYOUT	B.A.K. 10/31/05
DRAWN	B.A.K. 10/31/05
REVIEWED	C.A.H. 01/12/06

**HANSON**

Hanson Professional Services Inc.  
 1525 South Sixth Street  
 Springfield, Illinois 62705-2896  
 Offices Nationwide

PROPOSED WIDENING  
 OF RUNWAY 13/31

EXISTING  
 ELECTRICAL PLAN

STA. 221+50 TO STA. 229+47.00