




ROUTE NO.	SECT.	COUNTY	SHEET NO.	TOTAL SHEETS
F.A.I. 74	(72-7) R-3	PEORIA	525	1360
FED. ROAD DIST. NO. 7	ILLINOIS	FED. AID PROJECT	CONTRACT NO. 68200	

Date: 11/22/2004 Time: 09:21:44 AM


File name: P:\643399E\str\structural\072-0190\sheet\Tracings\480005-1A0720190.DGN

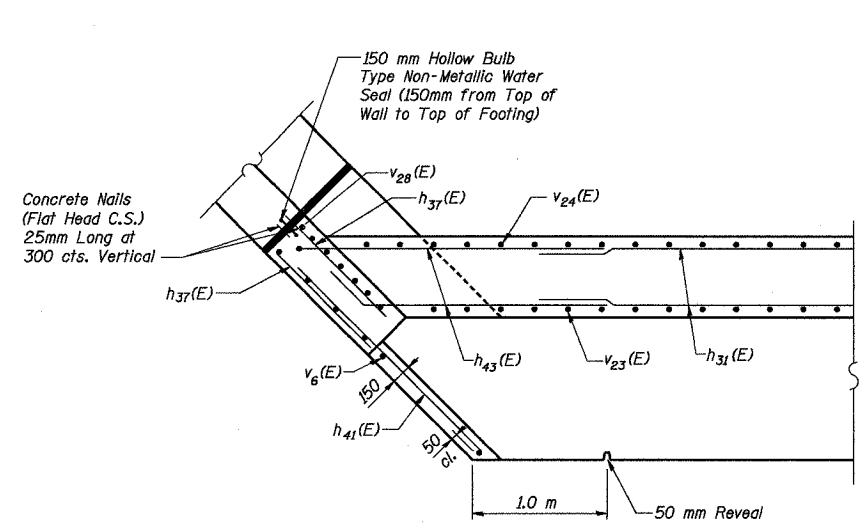

SECTION A-A

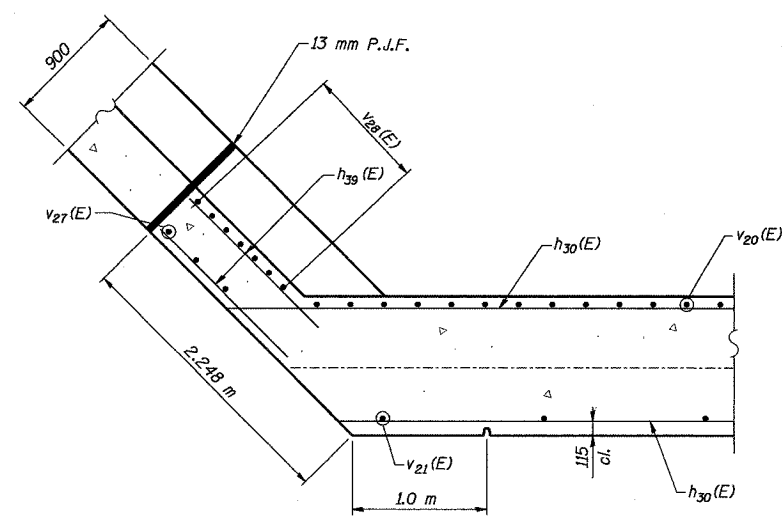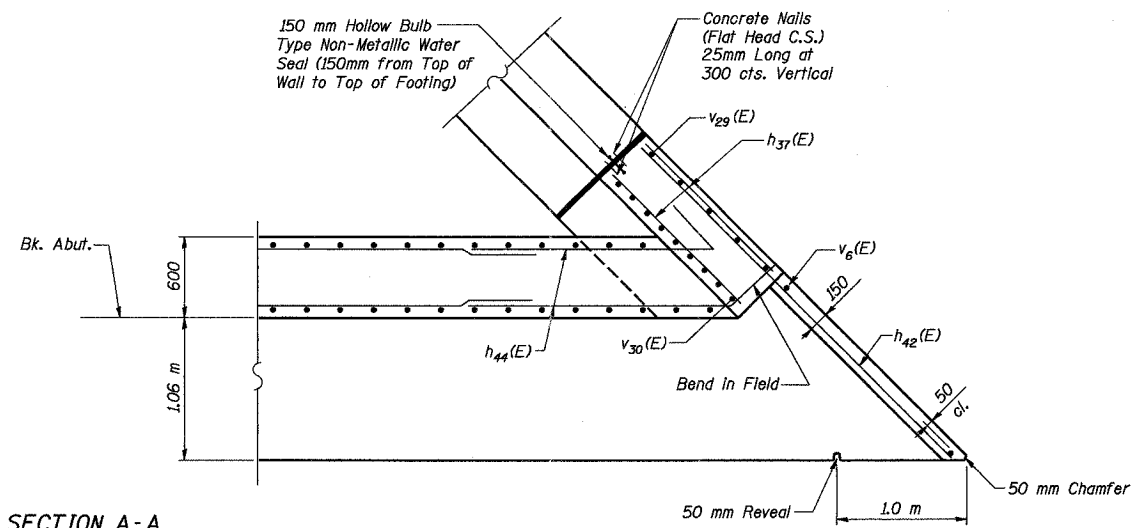


SECTION B-B

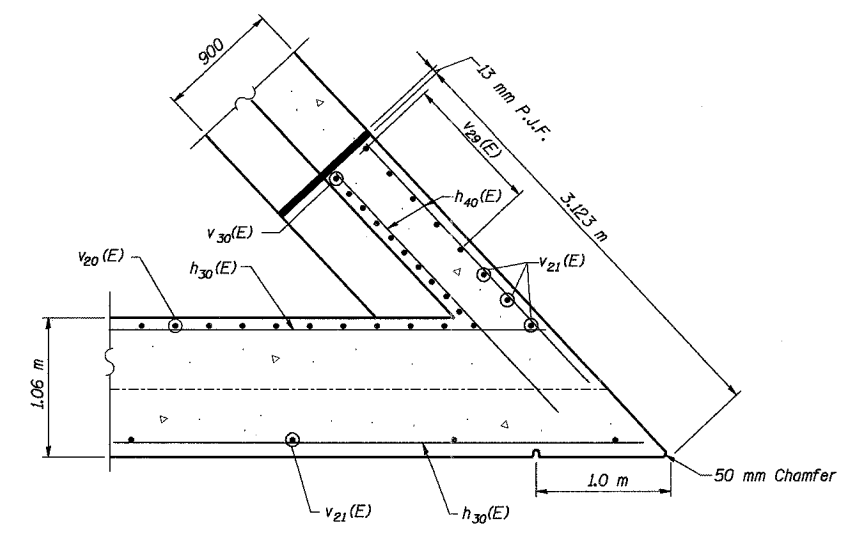

Note A:
See Lighting and Electrical plans for embedded conduit and junction box details.

MIN. BAR LAP
#15 bar = 640
#30 bar = 1.85 m

Notes:
Space reinforcement in cap to miss anchor bolts.
For Bill of Material and reinforcement details, see sheet 29.
Work this sheet with sheet 25.
Pour steps monolithically with cap.
For Rustication on face of abutment and wingwall, see sheet 30.
Hatched area to be poured after superstructure forms have been removed. Quantity of concrete included with Concrete Superstructure.
All dimensions are in millimeters (mm) except as noted.

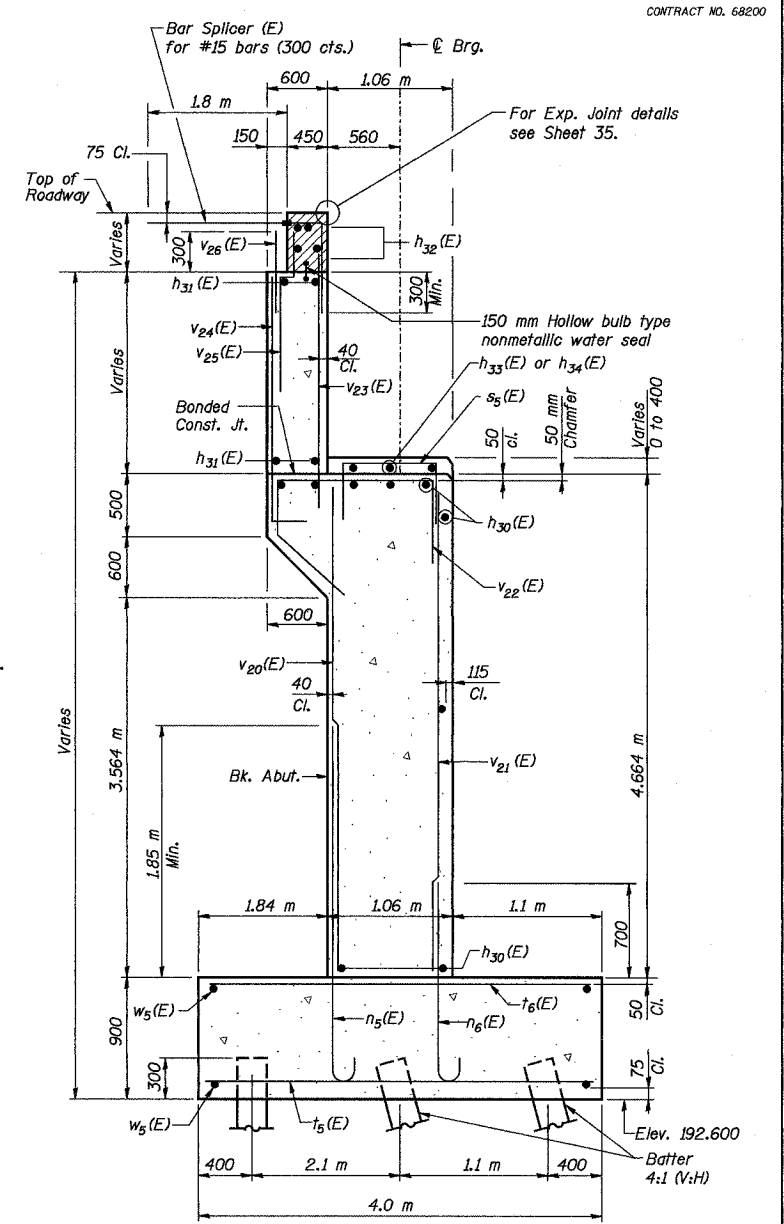

SECTION THRU ABUTMENT

REVISION	DATE	DESCRIPTION
STATE OF ILLINOIS DEPARTMENT OF TRANSPORTATION		
SOUTH ABUTMENT DETAILS I		
RAMPS B-3 AND B-5 OVER WAR MEMORIAL DR. AND RAMP B-6 F.A.I. ROUTE 74 SECTION (72-7) R-3 PEORIA COUNTY STA. 10+618.61 (RAMP B-3) STA. 10+472.60 (RAMP B-5) STRUCTURE NUMBER 072-0190		
PARSONS TRANSPORTATION GROUP CHICAGO, ILLINOIS		
DRAWING NO. 26	SCALE N.T.S.	DATE 2-21-03
		SHEET NO. 26

Designed by:	DL
Checked by:	AK
Drafted by:	JV
Checked by:	AK