


|                     |            |          |                  |           |
|---------------------|------------|----------|------------------|-----------|
| F.A.I. RTE.         | SECTION    | COUNTY   | TOTAL SHEETS     | SHEET NO. |
| 74                  | (72-71R-3) | PEORIA   | 1360             | 1191      |
| STA.                |            | TO STA.  |                  |           |
| FED. ROAD DIST. NO. |            | ILLINOIS | FED. AID PROJECT |           |

CONTRACT NO. 68200

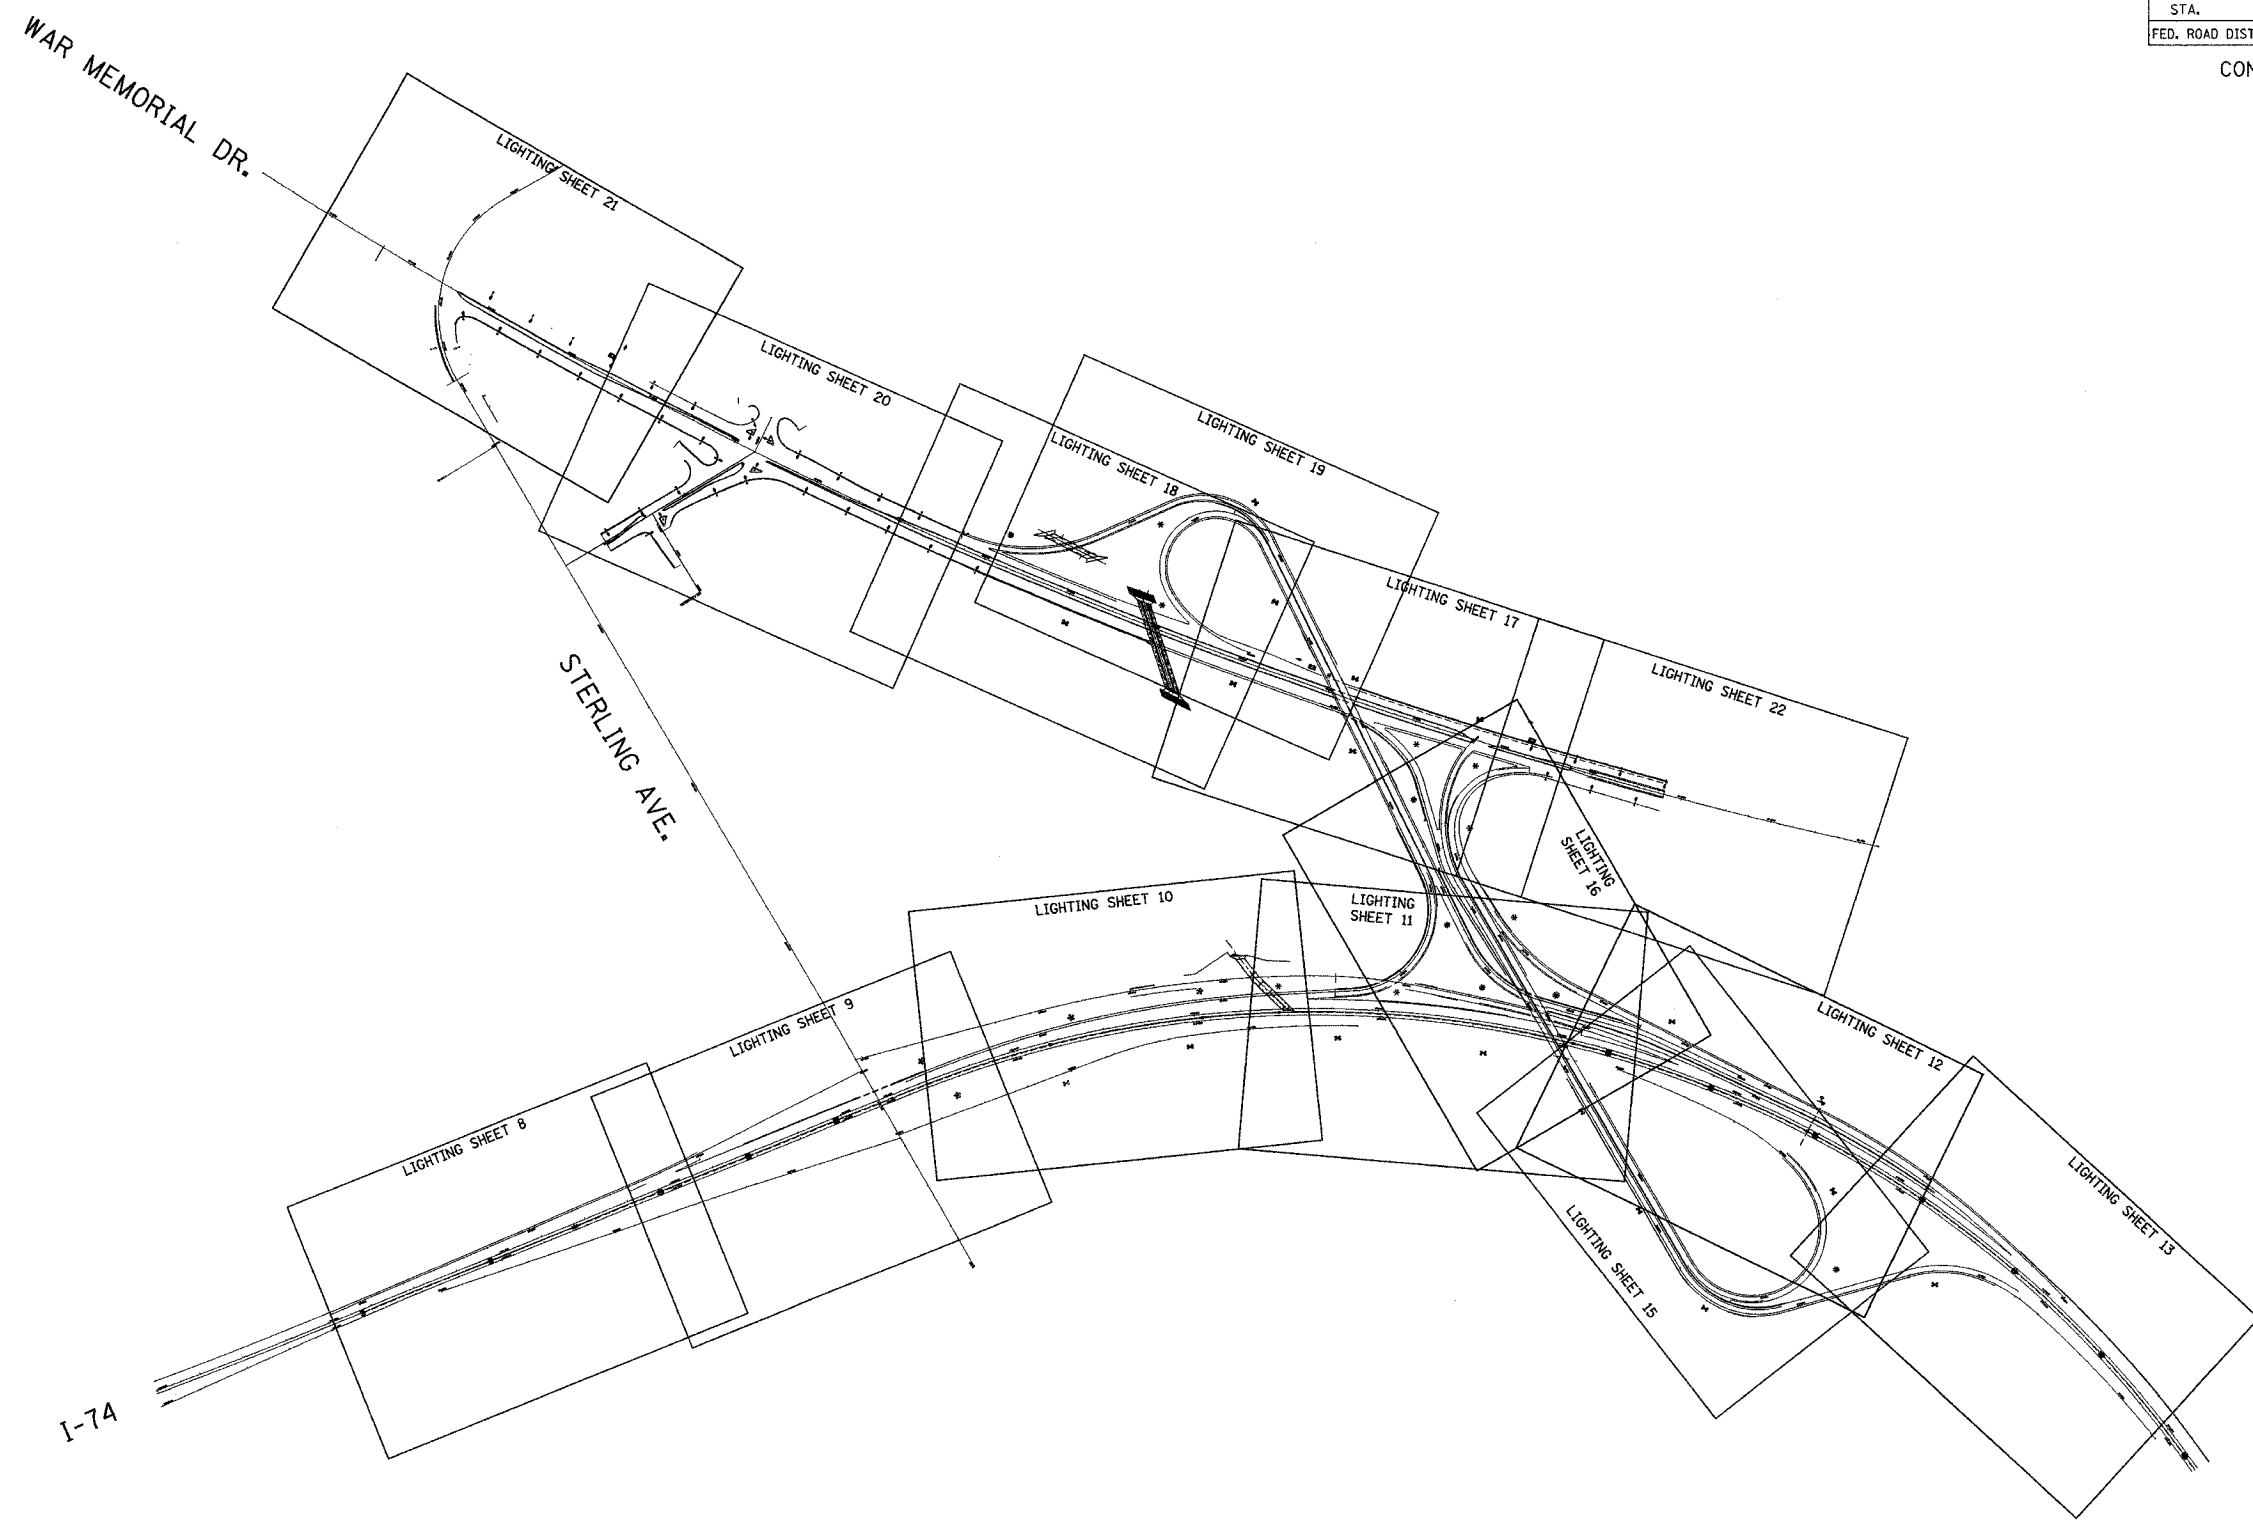

m:\proj\3573\lighting\74\contract\0\11000-7ash\indx.dgn

4/13/03 PM

11/12/2004

LIGHTING SHEET 7 OF 64

| REVISIONS |      |
|-----------|------|
| NAME      | DATE |
|           |      |
|           |      |
ILLINOIS DEPARTMENT OF TRANSPORTATION

PROPOSED LIGHTING PLAN  
PLAN SHEET OVERVIEW

**ab** **alfred benesch & company**  
CONSULTING ENGINEERS  
205 NORTH MICHIGAN AVENUE, CHICAGO, ILLINOIS 60601

DATE: 11/12/04  
DRAWN BY DJK  
CHECKED BY MKR