


F.A.I. RTE.	SECTION	COUNTY	TOTAL SHEETS	SHEET NO.
74	(72-7R-3)	PEORIA	1360	1195
STA.	TO STA.			
FED. ROAD DIST. NO.	ILLINOIS	FED. AID PROJECT		

CONTRACT NO. 68200

NOTE:
 1. USE CONDUIT COUPLING TO CONNECT PROPOSED CONDUIT TO EXISTING CONDUIT. COST OF CONNECTION SHALL BE INCLUDED IN "CONDUIT EMBEDDED IN STRUCTURE, 75mm DIA. PVC" PAY ITEM.

 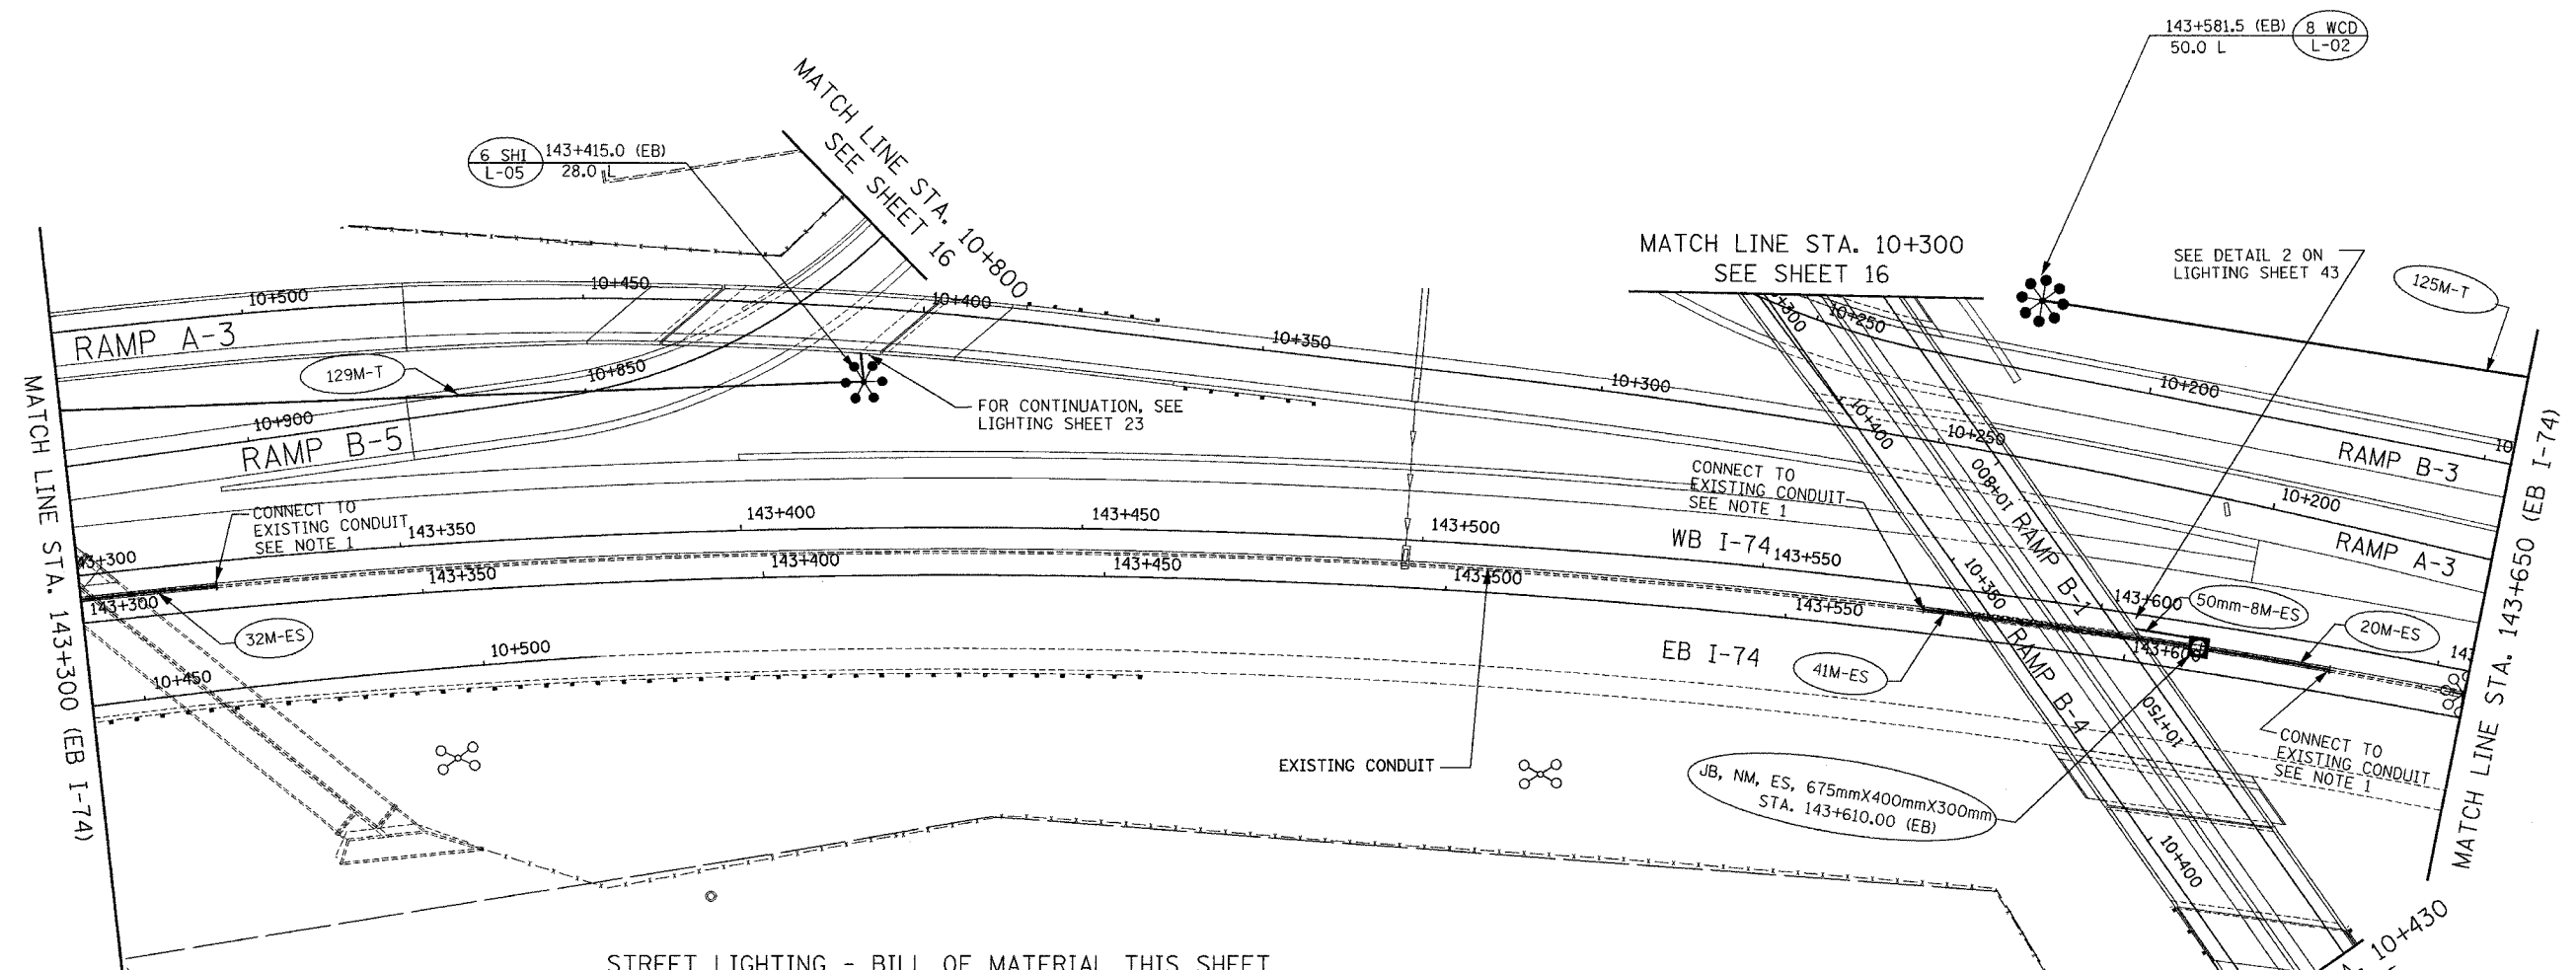


STREET LIGHTING - BILL OF MATERIAL THIS SHEET

PAY ITEM	UNIT	QUANTITY
CONDUIT IN TRENCH, 75MM DIA., PVC	METER	254.0
CONDUIT EMBEDDED IN STRUCTURE, 50MM DIA. PVC	METER	8.0
CONDUIT EMBEDDED IN STRUCTURE, 75MM DIA. PVC	METER	93.0
JUNCTION BOX, NON-METALLIC, EMBEDDED IN STRUCTURE, 675MM X 400MM X 300MM	EACH	1
TRENCH AND BACKFILL FOR ELECTRICAL WORK	METER	254.0
LIGHT TOWER FOUNDATION	METER	13.3
HIGH MAST LUMINAIRE, (INSTALL ONLY)	EACH	14
LIGHT TOWER, INSTALL ONLY	EACH	2

LENGTH IN METERS
 ES: EMBEDDED IN STRUCTURE
 T: TRENCH
 P: PUSHED
 CT: COMMON TRENCH
 CTT: COMMON TRENCH WITH TRAFFIC SIGNAL CONDUIT (TRENCH AND BACKFILL BY TRAFFIC SIGNAL CONTRACTOR)

PROPOSED CONDUIT CALL-OUT



ab alfred benesch & company
 CONSULTING ENGINEERS
 205 NORTH MICHIGAN AVENUE, CHICAGO, ILLINOIS 60601

REVISIONS	
NAME	DATE

LIGHTING SHEET 11 OF 64
 ILLINOIS DEPARTMENT OF TRANSPORTATION
 PROPOSED LIGHTING PLAN
 I-74
 STA. 143+300 TO STA. 143+650
 DATE: 11/12/04
 DRAWN BY DJK
 CHECKED BY MKR

m:\proj\3573\LIGHTING\74-Contract\01\11004-7a74.dgn

10:44:45 AM

11/15/2004