

STREET LIGHTING - BILL OF MATERIAL THIS SHEET

PAY ITEM	UNIT	QUANTITY
CONDUIT IN TRENCH, 75MM DIA., PVC	METER	110.0
TRENCH AND BACKFILL FOR ELECTRICAL WORK	METER	110.0
LIGHT TOWER FOUNDATION	METER	5.5
HIGH MAST LUMINAIRE, (INSTALL ONLY)	EACH	4
LIGHT TOWER, INSTALL ONLY	EACH	1

F.A.I. RTE.	SECTION	COUNTY	TOTAL SHEETS	SHEET NO.
74	(72-7)R-3	PEORIA	1360	1197
STA.		TO STA.		
FED. ROAD DIST. NO.	ILLINOIS	FED. AID PROJECT		


CONTRACT NO. 68200




m:\proj\3573\LIGHTING\74-Contract\01\11006-7.dgn

10:49:07 AM

11/15/2004

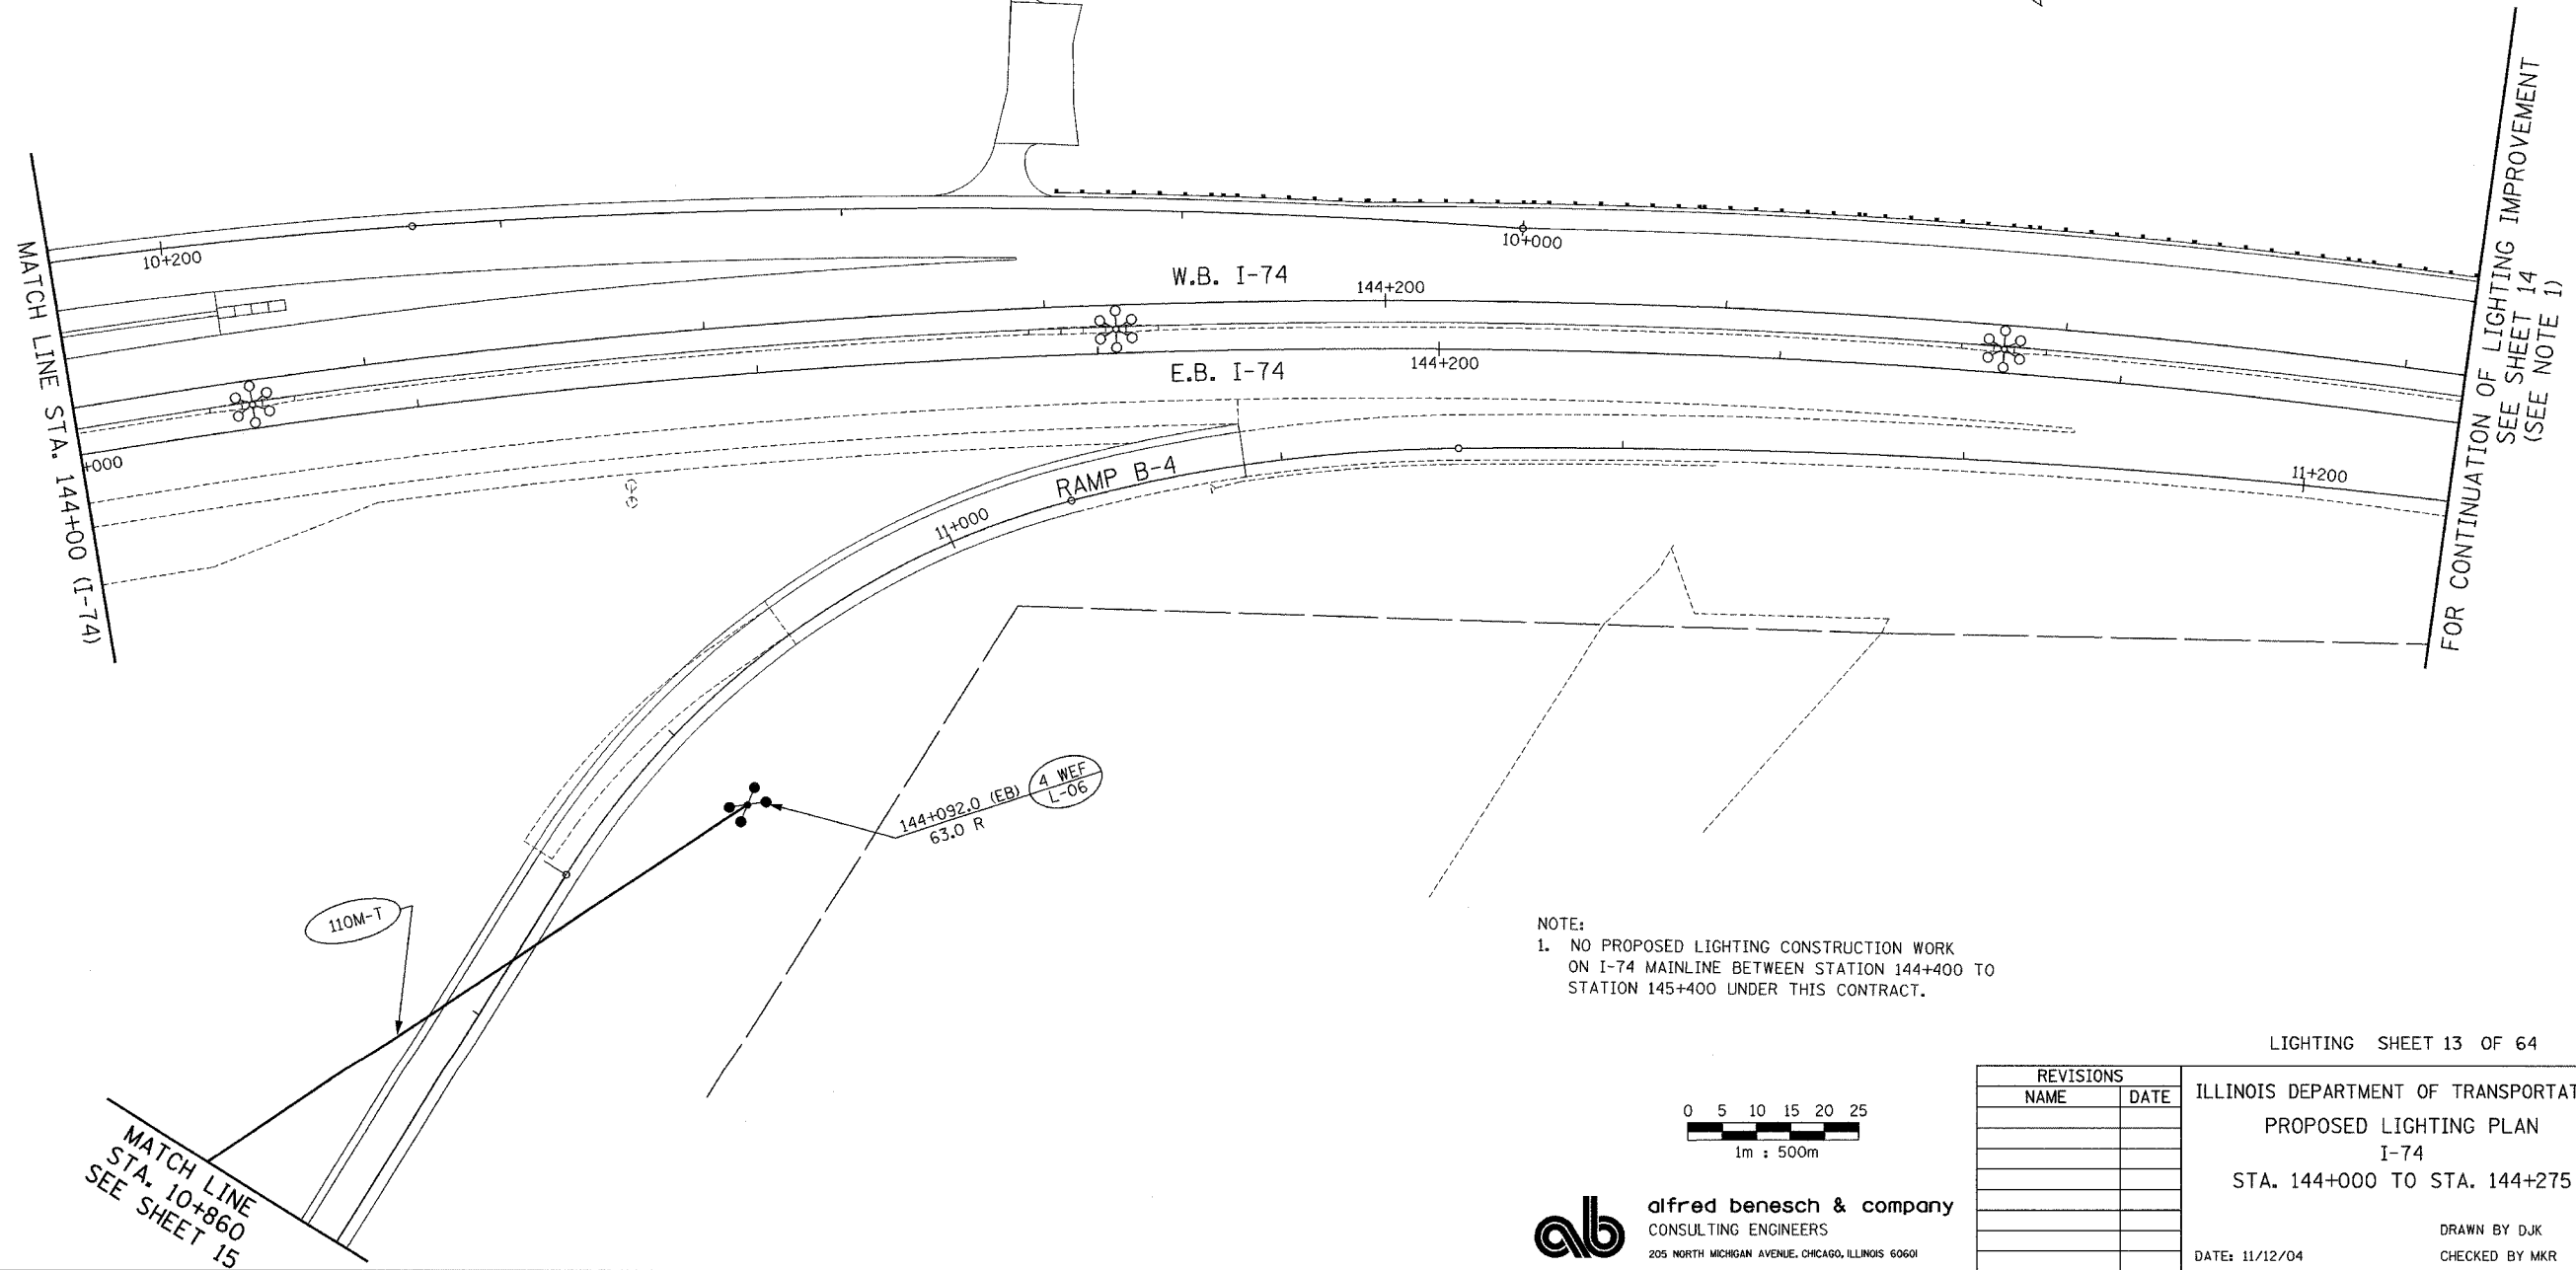

 NOTE:  
 1. NO PROPOSED LIGHTING CONSTRUCTION WORK ON I-74 MAINLINE BETWEEN STATION 144+400 TO STATION 145+400 UNDER THIS CONTRACT.



**ab** **alfred benesch & company**  
 CONSULTING ENGINEERS  
 205 NORTH MICHIGAN AVENUE, CHICAGO, ILLINOIS 60601

REVISIONS	
NAME	DATE

LIGHTING SHEET 13 OF 64  
 ILLINOIS DEPARTMENT OF TRANSPORTATION  
 PROPOSED LIGHTING PLAN  
 I-74  
 STA. 144+000 TO STA. 144+275  
 DRAWN BY DJK  
 CHECKED BY MKR  
 DATE: 11/12/04