


STREET LIGHTING - BILL OF MATERIAL THIS SHEET

PAY ITEM	UNIT	QUANTITY
CONDUIT IN TRENCH, 75MM DIA., PVC	METER	562.0
TRENCH AND BACKFILL FOR ELECTRICAL WORK	METER	562.0
LIGHT TOWER FOUNDATION	METER	33.3
HIGH MAST LUMINAIRE, (INSTALL ONLY)	EACH	24
LIGHT TOWER, INSTALL ONLY	EACH	5

F.A.I. RTE.	SECTION	COUNTY	TOTAL SHEETS	SHEET NO.
74	(72-7R-3)	PEORIA	1360	1199
STA.	TO STA.			
FED. ROAD DIST. NO.	ILLINOIS	FED. AID PROJECT		

CONTRACT NO. 68200

11/15/2004 10:51:36 AM m:\proj\3573\LIGHTING\74-Contract ID\11008-7awm.dgn

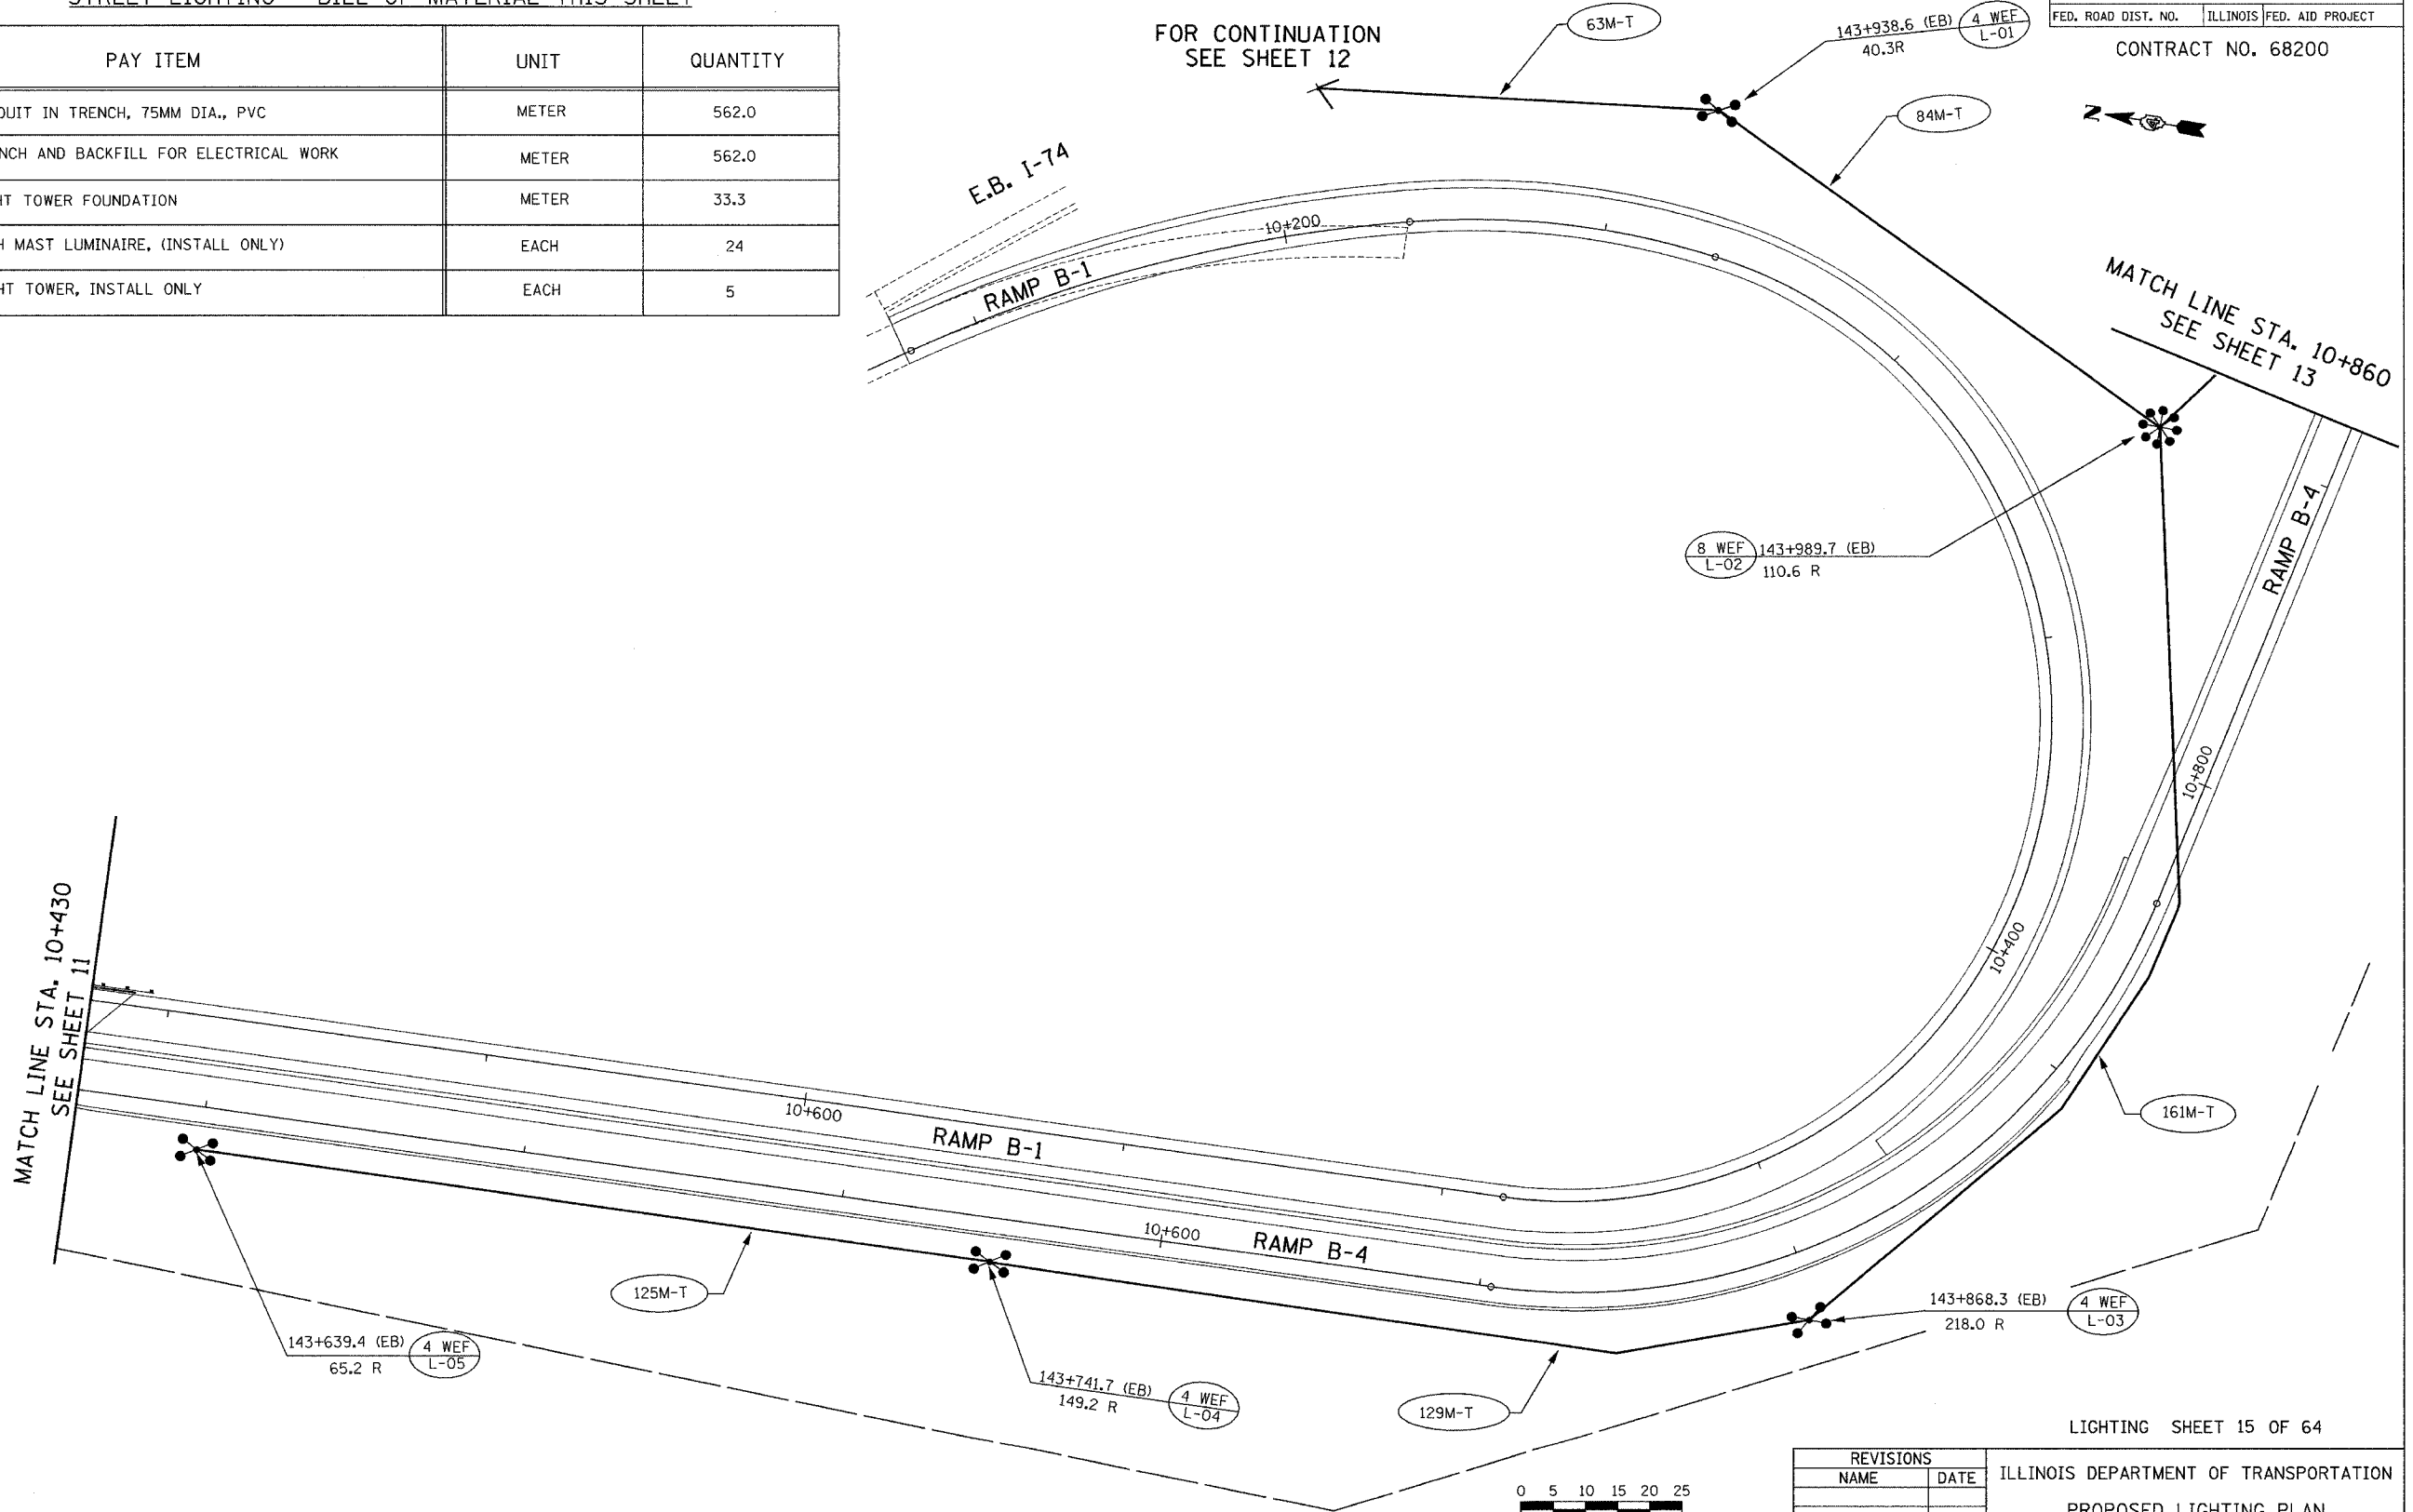

FOR CONTINUATION
SEE SHEET 12

MATCH LINE STA. 10+860
SEE SHEET 13

MATCH LINE STA. 10+430
SEE SHEET 11

LIGHTING SHEET 15 OF 64

ab **alfred benesch & company**
CONSULTING ENGINEERS
205 NORTH MICHIGAN AVENUE, CHICAGO, ILLINOIS 60601

REVISIONS	
NAME	DATE

ILLINOIS DEPARTMENT OF TRANSPORTATION
PROPOSED LIGHTING PLAN
WAR MEMORIAL DR. INTERCHANGE
RAMPS B-1 & B-4
DRAWN BY DJK
CHECKED BY MKR
DATE: 11/12/04