

STREET LIGHTING - BILL OF MATERIAL THIS SHEET

PAY ITEM	UNIT	QUANTITY
LUMINAIRE, SODIUM VAPOR, HORIZONTAL MOUNT, 400 WATT	EACH	3
CONDUIT IN TRENCH, 50MM DIA., PVC	METER	107.0
CONDUIT IN TRENCH, 75MM DIA., PVC	METER	408.0
TRENCH AND BACKFILL FOR ELECTRICAL WORK	METER	515.0
LIGHT POLE, ALUMINUM, TRANSFORMER BASE, 13.5M M.H., 2.4M DAVIT ARM	EACH	3
LIGHT POLE FOUNDATION, 600mm DIAMETER	METER	7.5
LIGHT TOWER FOUNDATION	METER	23.9
HIGH MAST LUMINAIRE, (INSTALL ONLY)	EACH	22
LIGHT TOWER, INSTALL ONLY	EACH	4


F.A.I. RTE.	SECTION	COUNTY	TOTAL SHEETS	SHEET NO.
74	(72-71R-3	PEORIA	1360	1302
STA.		TO STA.		
FED. ROAD DIST. NO.		ILLINOIS	FED. AID PROJECT	

CONTRACT NO. 68200


m:\proj\3573\LIGHTING\4-Contract ID\11003-7awm.dgn

10:43:35 AM

11/15/2004

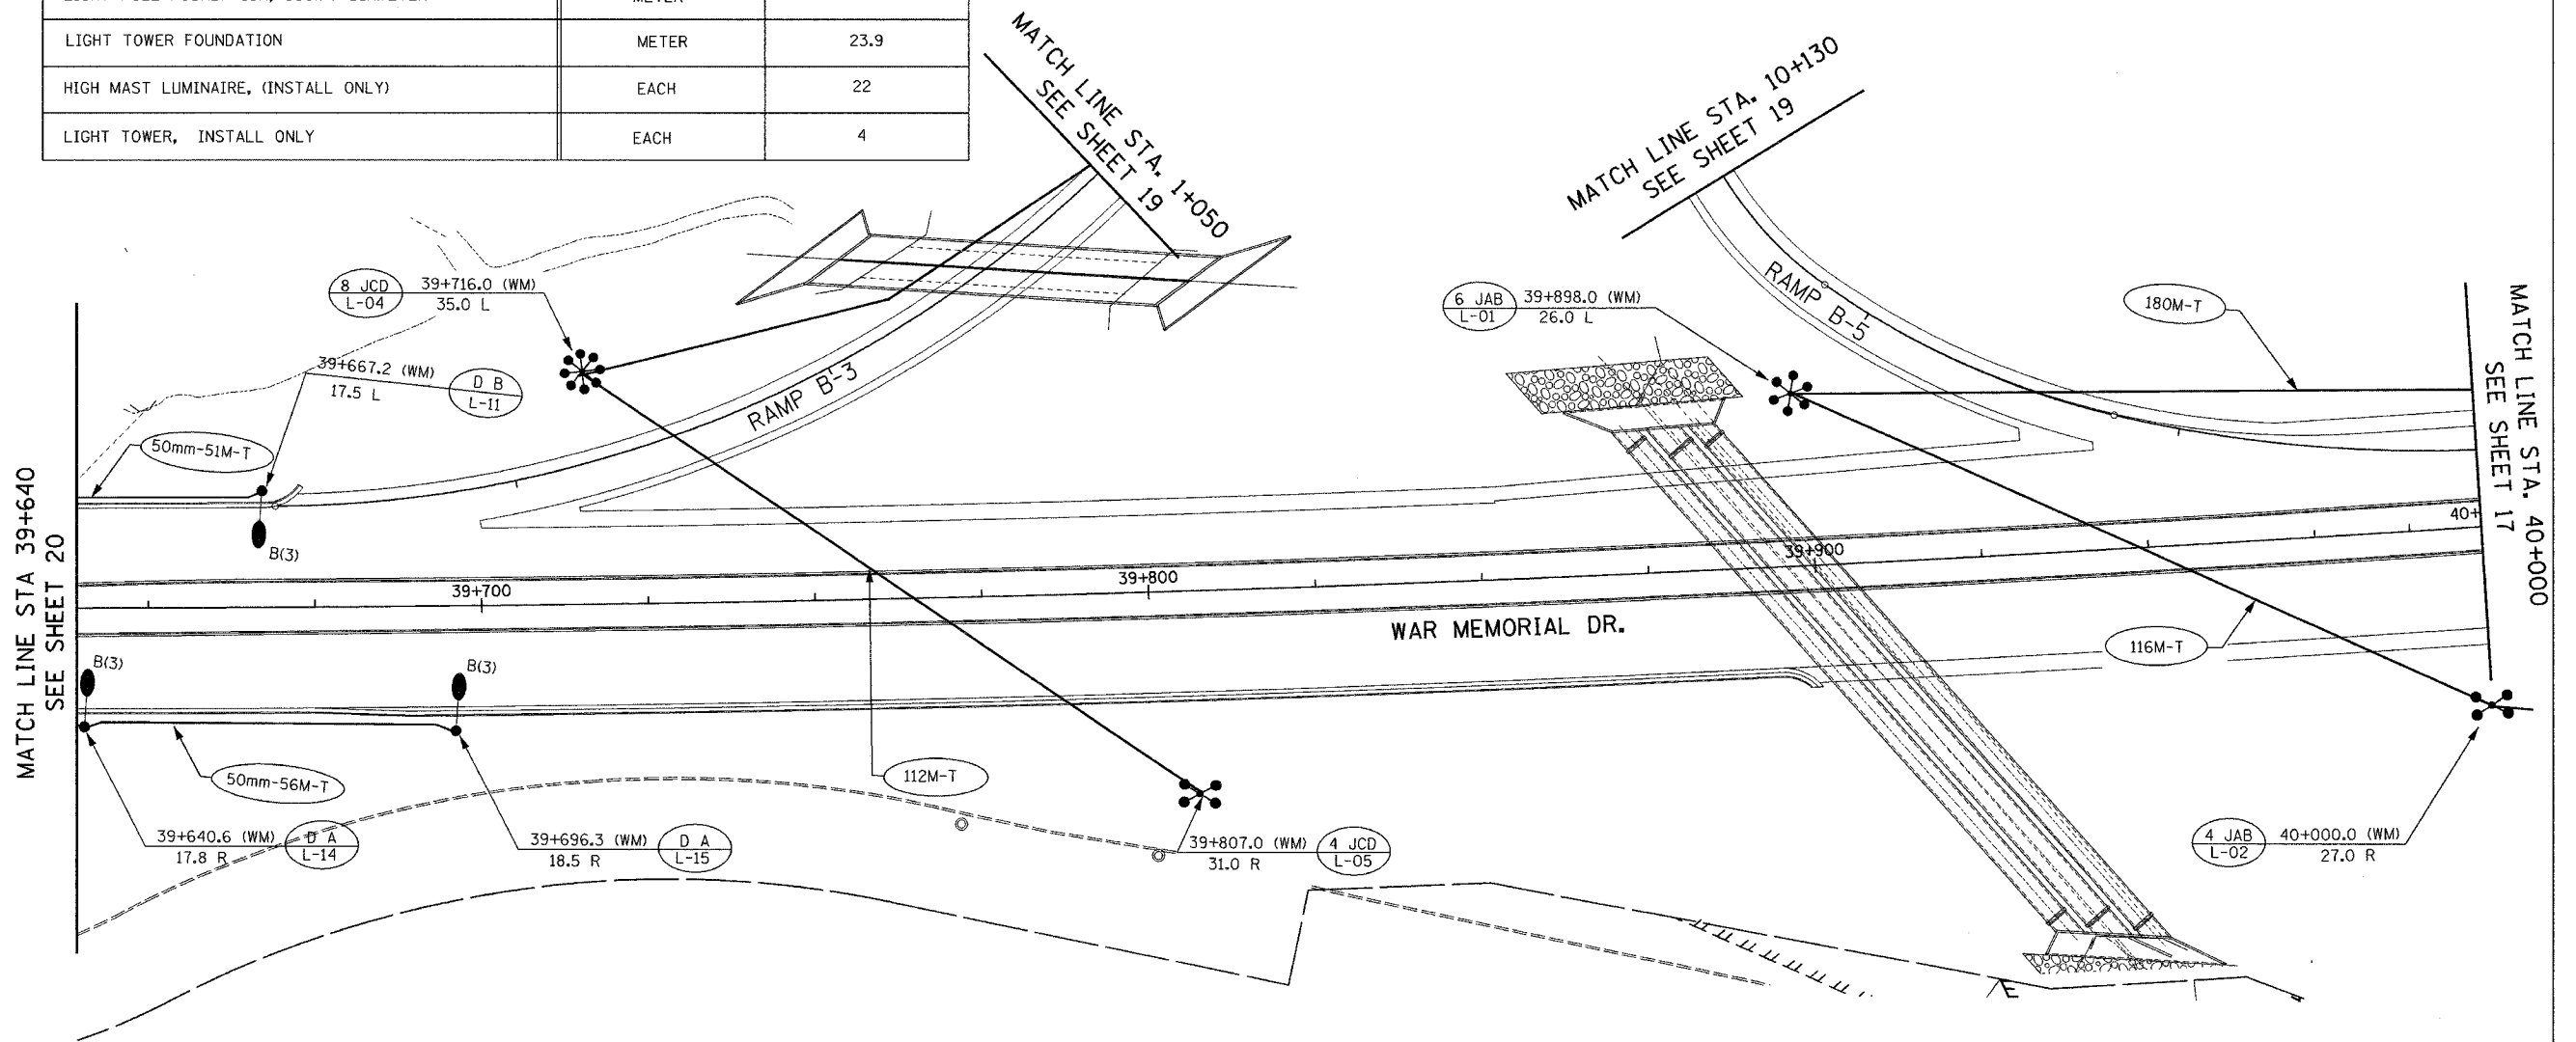

LIGHTING SHEET 18 OF 64

 

ab **alfred benesch & company**
CONSULTING ENGINEERS
205 NORTH MICHIGAN AVENUE, CHICAGO, ILLINOIS 60601

REVISIONS	
NAME	DATE

ILLINOIS DEPARTMENT OF TRANSPORTATION
PROPOSED LIGHTING PLAN
WAR MEMORIAL DR.
STA. 39+640 TO STA. 40+000
DRAWN BY DJK
CHECKED BY MKR
DATE: 11/12/04