 


F.A.I. RTE.	SECTION	COUNTY	TOTAL SHEETS	SHEET NO.
74	(72-7)R-3	PEORIA	1360	1305
STA.	TO STA.			
FED. ROAD DIST. NO.	ILLINOIS	FED. AID PROJECT		


STREET LIGHTING - BILL OF MATERIAL THIS SHEET

PAY ITEM	UNIT	QUANTITY
ELECTRIC SERVICE INSTALLATION	EACH	1
CONCRETE HANDHOLE	EACH	2
LUMINAIRE, SODIUM VAPOR, HORIZONTAL MOUNT, 400 WATT	EACH	9
CONDUIT IN TRENCH, 50MM DIA., PVC	METER	465.0
TRENCH AND BACKFILL FOR ELECTRICAL WORK	METER	455.0
LIGHT POLE, ALUMINUM, TRANSFORMER BASE, 13.5M M.H., 2.4M DAVIT ARM	EACH	9
LIGHT POLE FOUNDATION, 600MM DIAMETER	METER	22.5
INSTALL CONTROLLER	EACH	1

CONTRACT NO. 68200



11/15/2004 10:40:20 AM m:\proj\3573\LIGHTING\Contract ID\10017\awmudgn

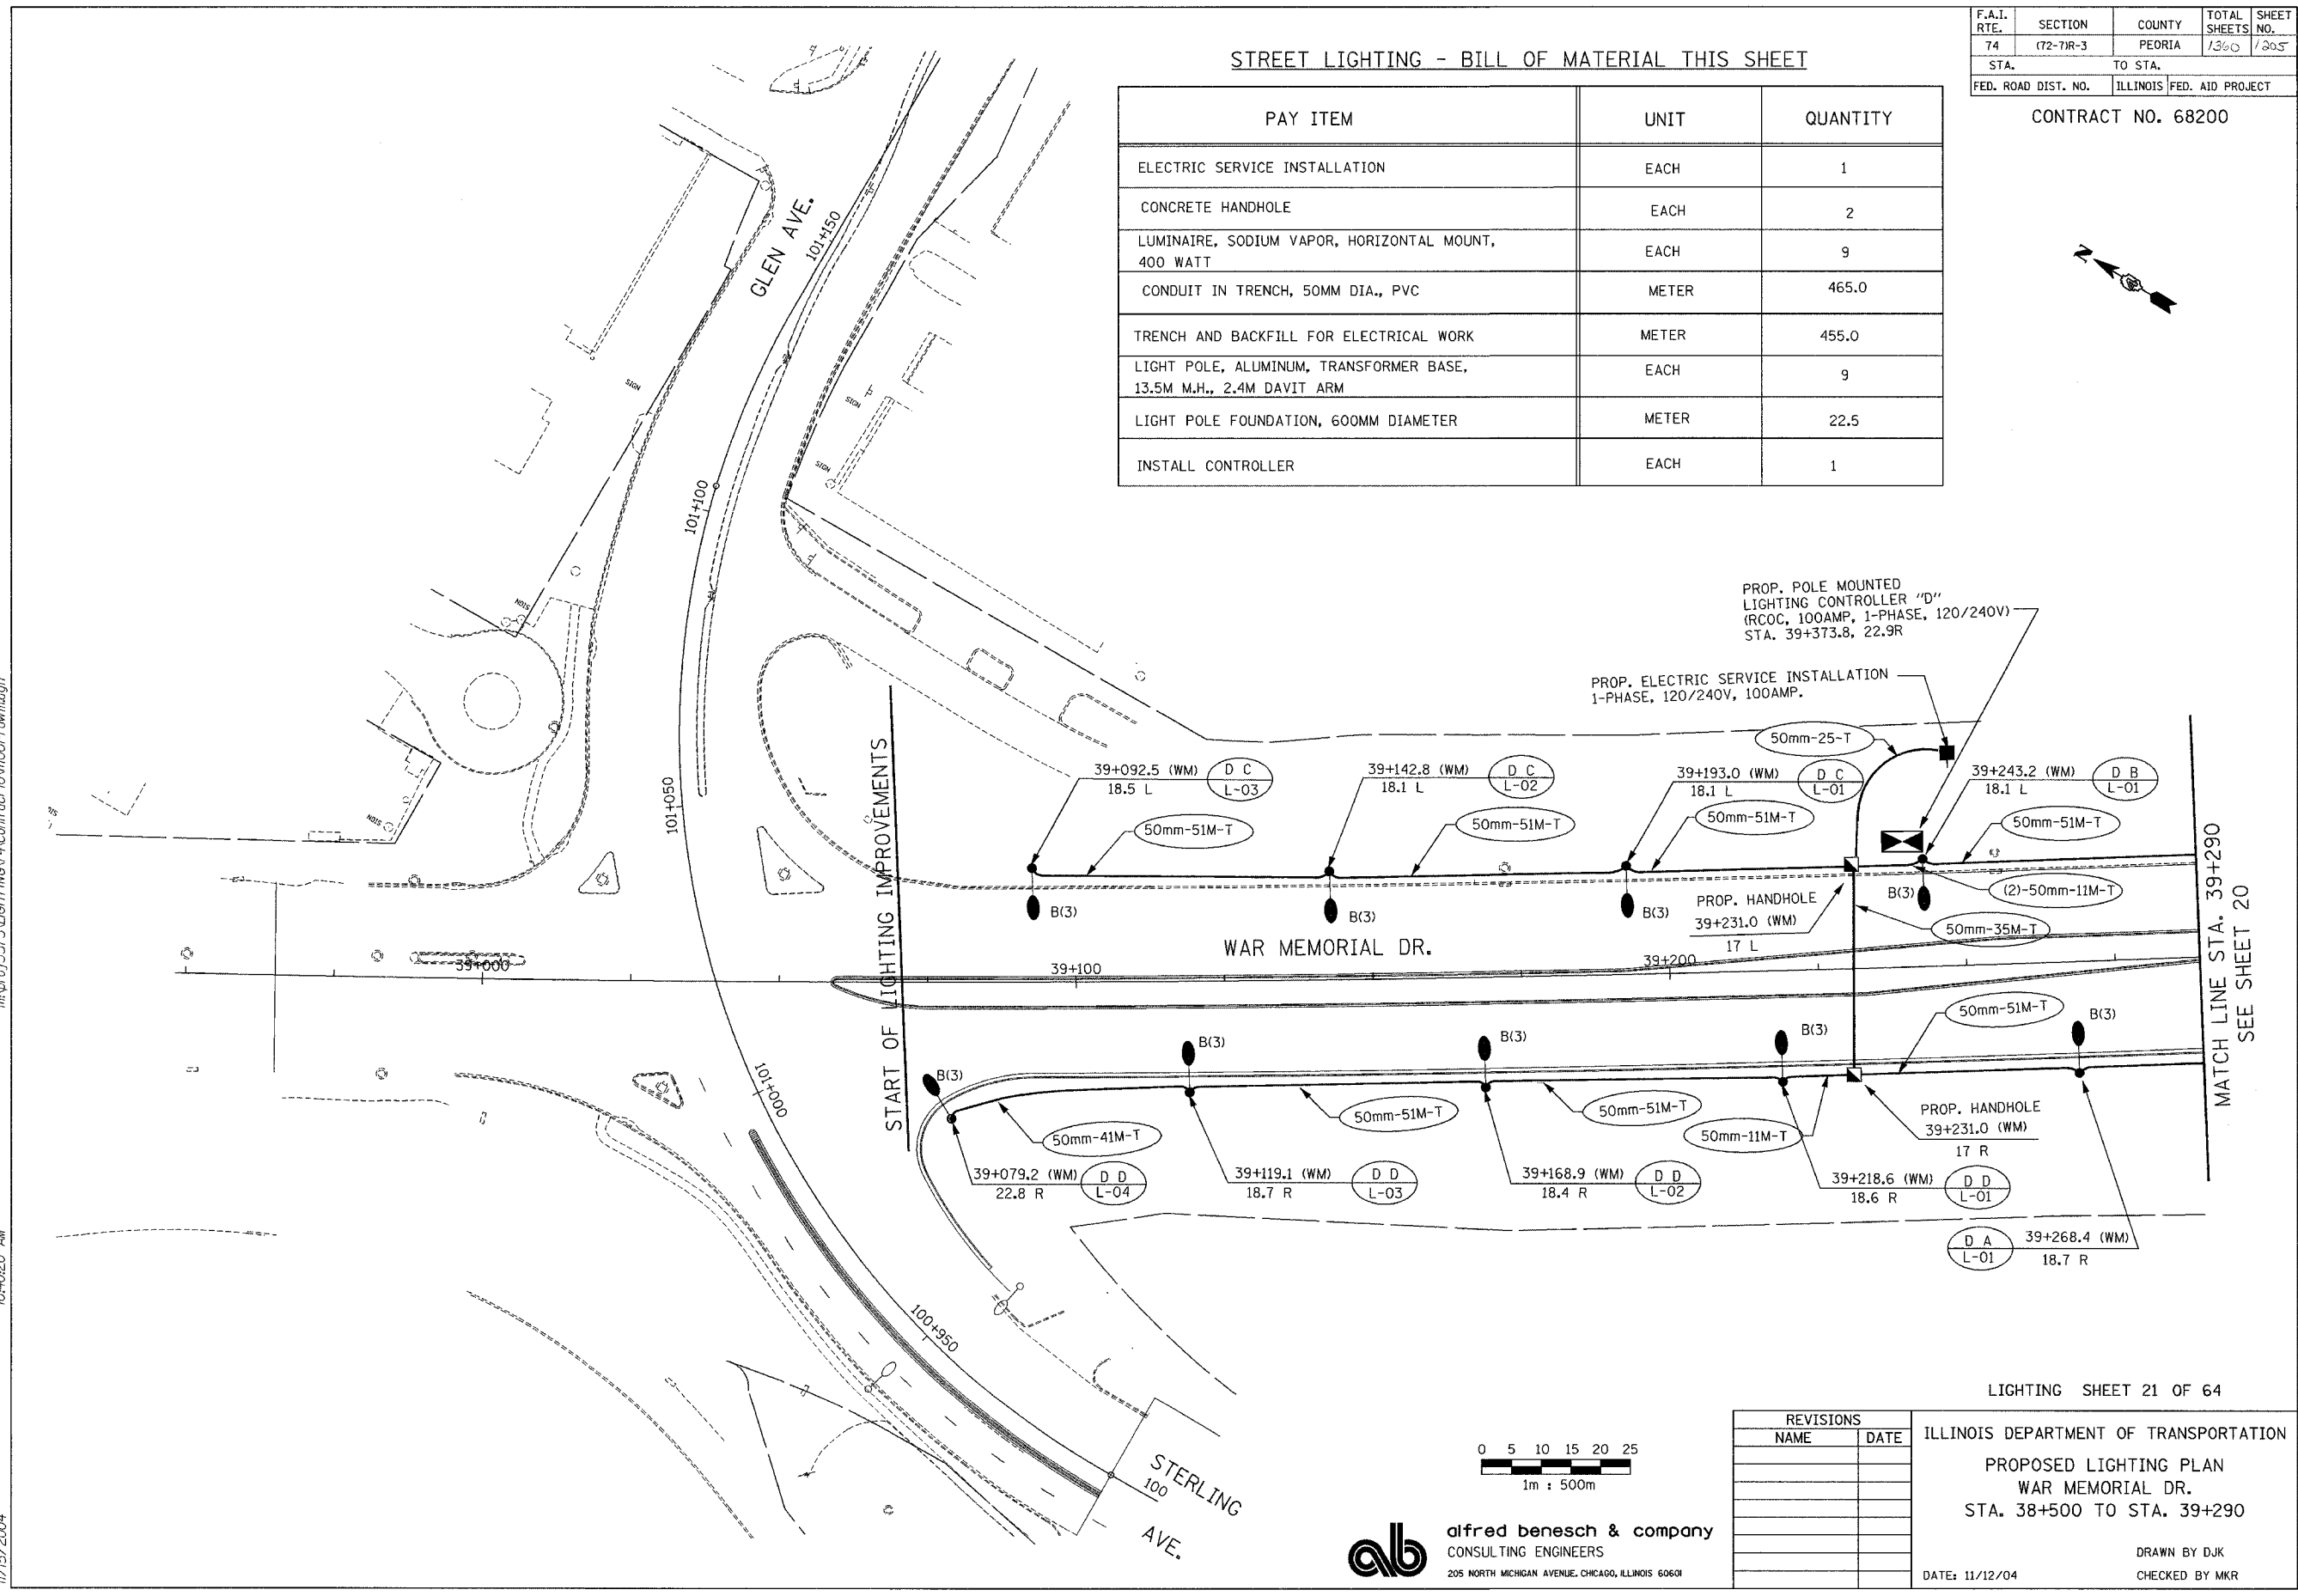

LIGHTING SHEET 21 OF 64

REVISIONS	
NAME	DATE

ILLINOIS DEPARTMENT OF TRANSPORTATION
 PROPOSED LIGHTING PLAN
 WAR MEMORIAL DR.
 STA. 38+500 TO STA. 39+290

DRAWN BY DJK
 CHECKED BY MKR

DATE: 11/12/04

ab **alfred benesch & company**
 CONSULTING ENGINEERS
 205 NORTH MICHIGAN AVENUE, CHICAGO, ILLINOIS 60601