



PARTIAL PLAN - WASTE PIPE

3/8"=1'-0"

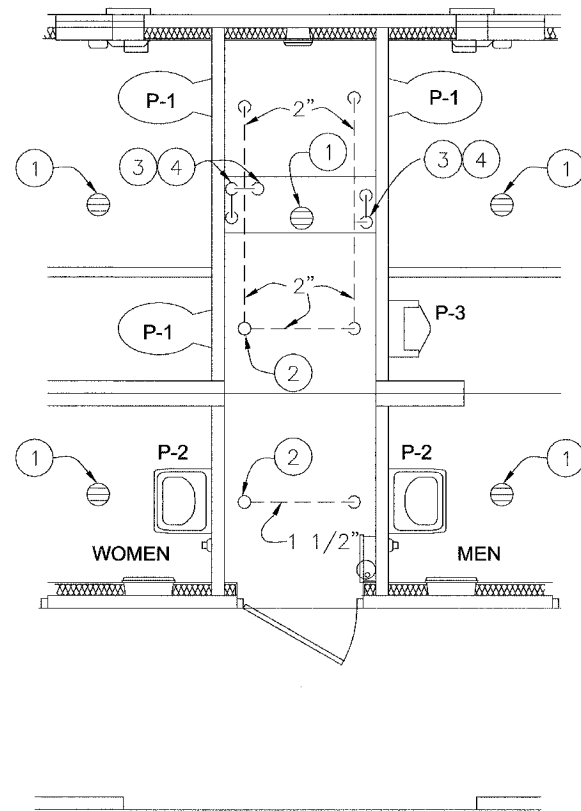

PARTIAL PLAN - VENT PIPE

3/8"=1'-0"

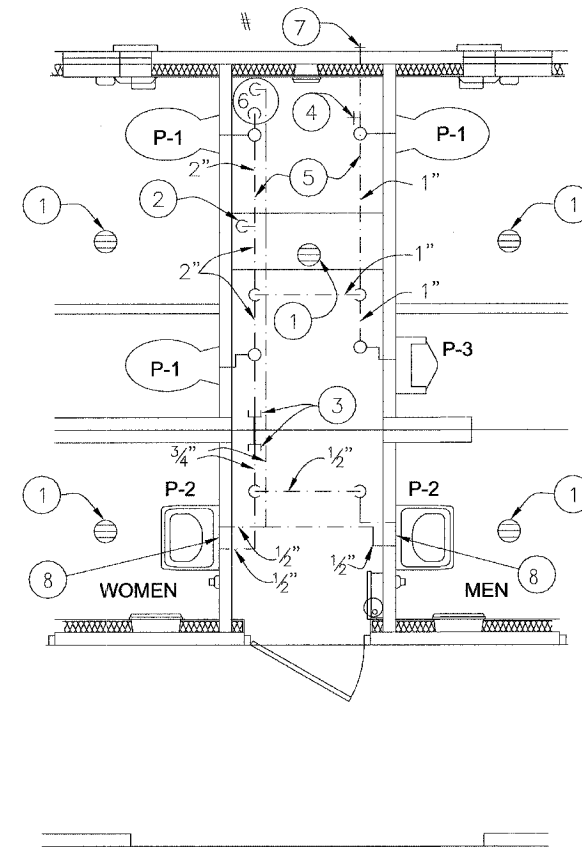

PARTIAL PLAN - HOT & COLD WATER PIPE

3/8"=1'-0"

WASTE PIPING - KEY NOTES

- 2" FLOOR DRAIN, FIELD INSTALLED
- 4" WASTE THROUGH FLOOR, FIELD INSTALLED
- PROVIDE TEST PLUG IN END OF WASTE PIPE. CONTINUATION OF PIPING IS FIELD INSTALLED
- CAPPED 2" WASTE CONNECTION BETWEEN UNITS

VENT PIPING - KEY NOTES

- 2" FLOOR DRAIN, FIELD INSTALLED
- 4" VENT THROUGH ROOF.
- 2" VENT WITH TEST PLUG.
- FIELD INSTALLED 2" VENT PIPING FROM FLOOR DRAINS.

WATER PIPING - KEY NOTES

- 2" FLOOR DRAIN, FIELD INSTALLED
- FIELD INSTALLED 2" WATER SUPPLY WITH SHUT-OFF VALVE NEAR FLOOR.
- 3/4" CAPPED CW LINE. CONNECTION BETWEEN SIDES IS TO BE FIELD INSTALLED.
- 3/4" HOSE BIBB WITH VACUUM BREAKER AND WHEEL HANDLE
- WATER PIPING ALONG WALL
- 30 GAL. HOT WATER HEATER
- 3/4" WALL HYDRANT WITH VACUUM BREAKER AND TEE KEY
- HOT & COLD WALL FAUCET WITH VACUUM BREAKER AND TEE KEY BELOW LAVATORY

NOTE: PLUMBING COMPONENTS ARE SHOWN FOR GENERAL ARRANGEMENT ONLY. CONTRACTOR SHALL SUBMIT DETAILED PLANS FOR APPROVAL PRIOR TO ORDERING BUILDING

PRODUCT OR BRAND NAMES ARE SHOWN TO ESTABLISH MINIMUM QUALITY REQUIREMENT, PRODUCTS OR BRANDS OF EQUAL QUALITY ARE ACCEPTABLE.

PIPING LEGEND

----- WATER	----- WASTE PIPE: PVC, ASTM D2665, SCH 40 OR ABS, ASTM D2661, SCH 40
----- VENT PIPING SCH 40 ABS TYPE DWV	----- FIELD PIPING

REVISIONS		ILLINOIS DEPARTMENT OF TRANSPORTATION	
NAME	DATE		
		<b>CLIFTON TERRACE PARK COMFORT STATION PARTIAL PLUMBING PLANS</b>	
SCALE: VERT. 3/8" = 1'-0"		DRAWN BY DWH	
HORIZ. 3/8" = 1'-0"		CHECKED BY DWH	
DATE FEBRUARY 9, 2005			