
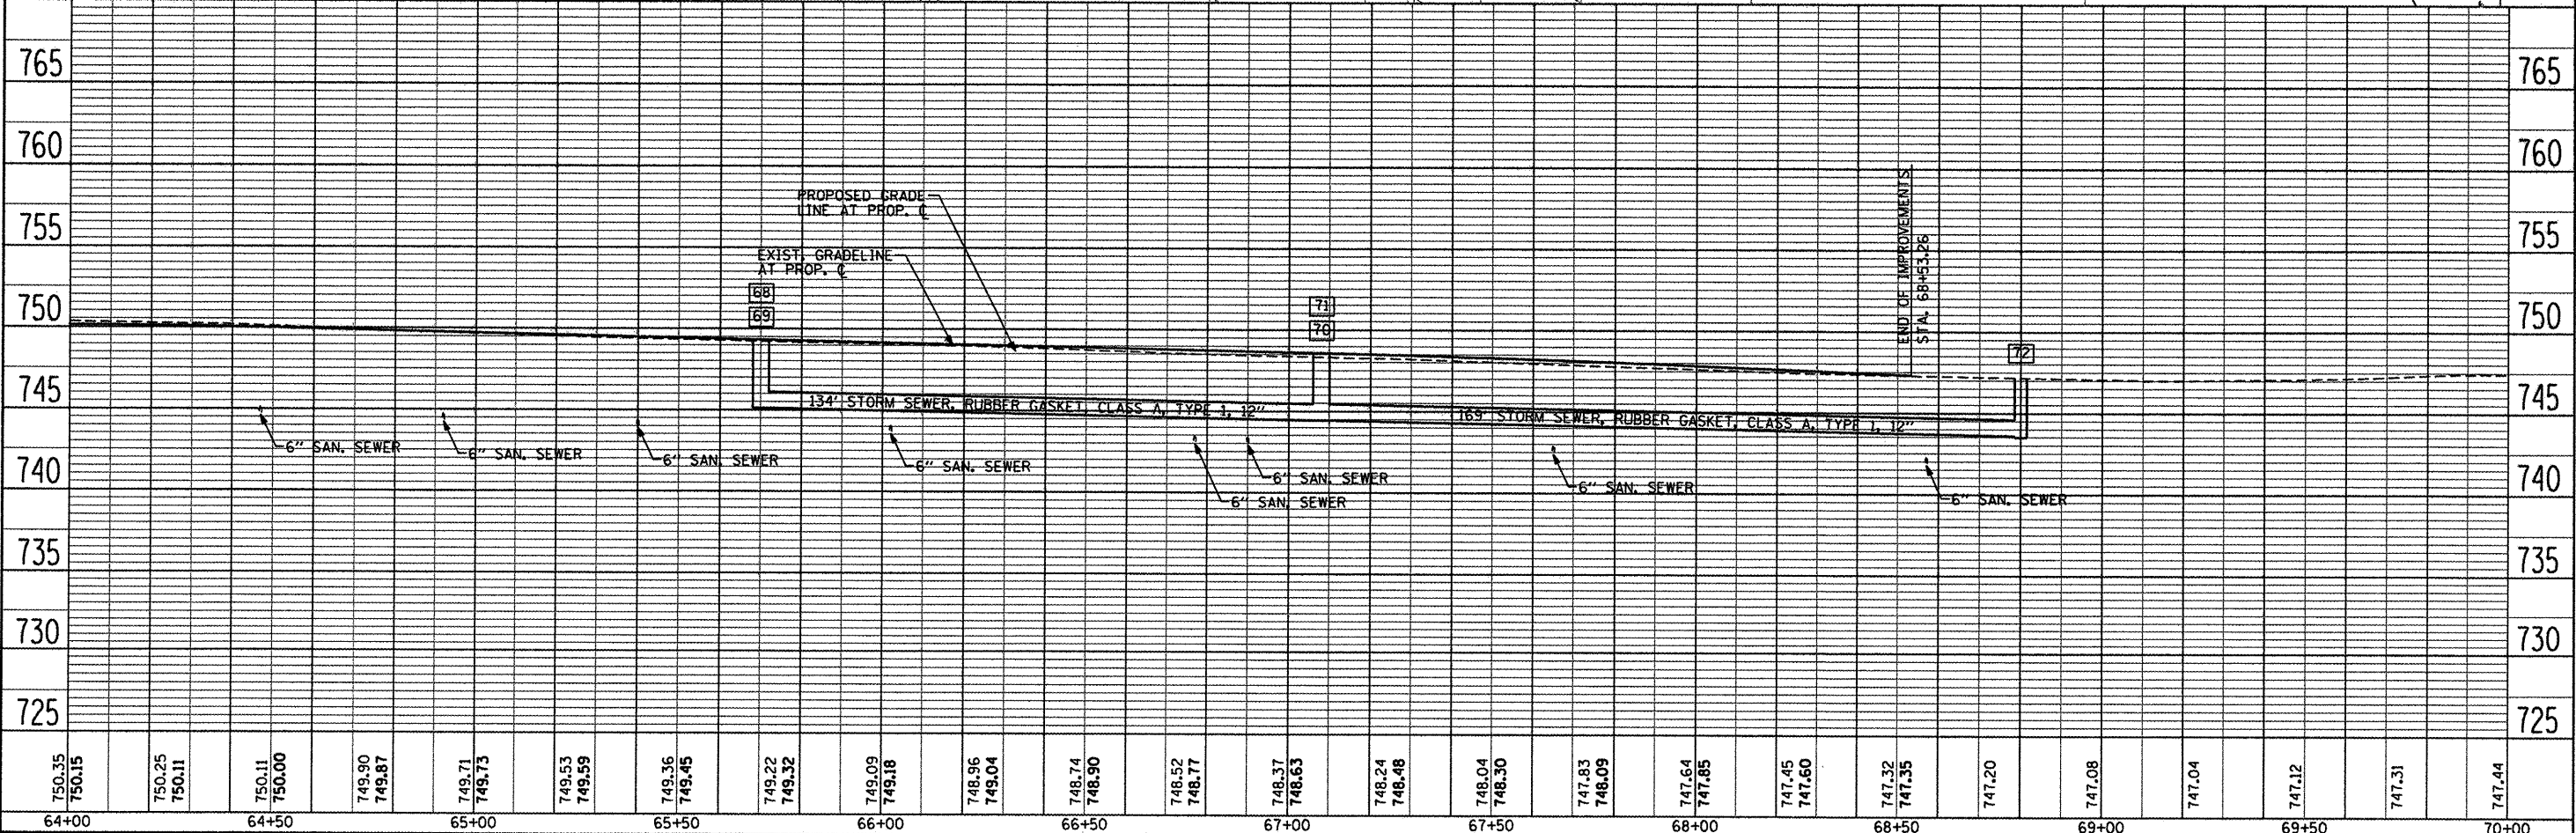


PLAN	DATE
BY	
CHECKED	
DESIGNED	
DRAWN	
NOTED	
NO.	

PROFILE	DATE
BY	
CHECKED	
DESIGNED	
DRAWN	
NOTED	
NO.	

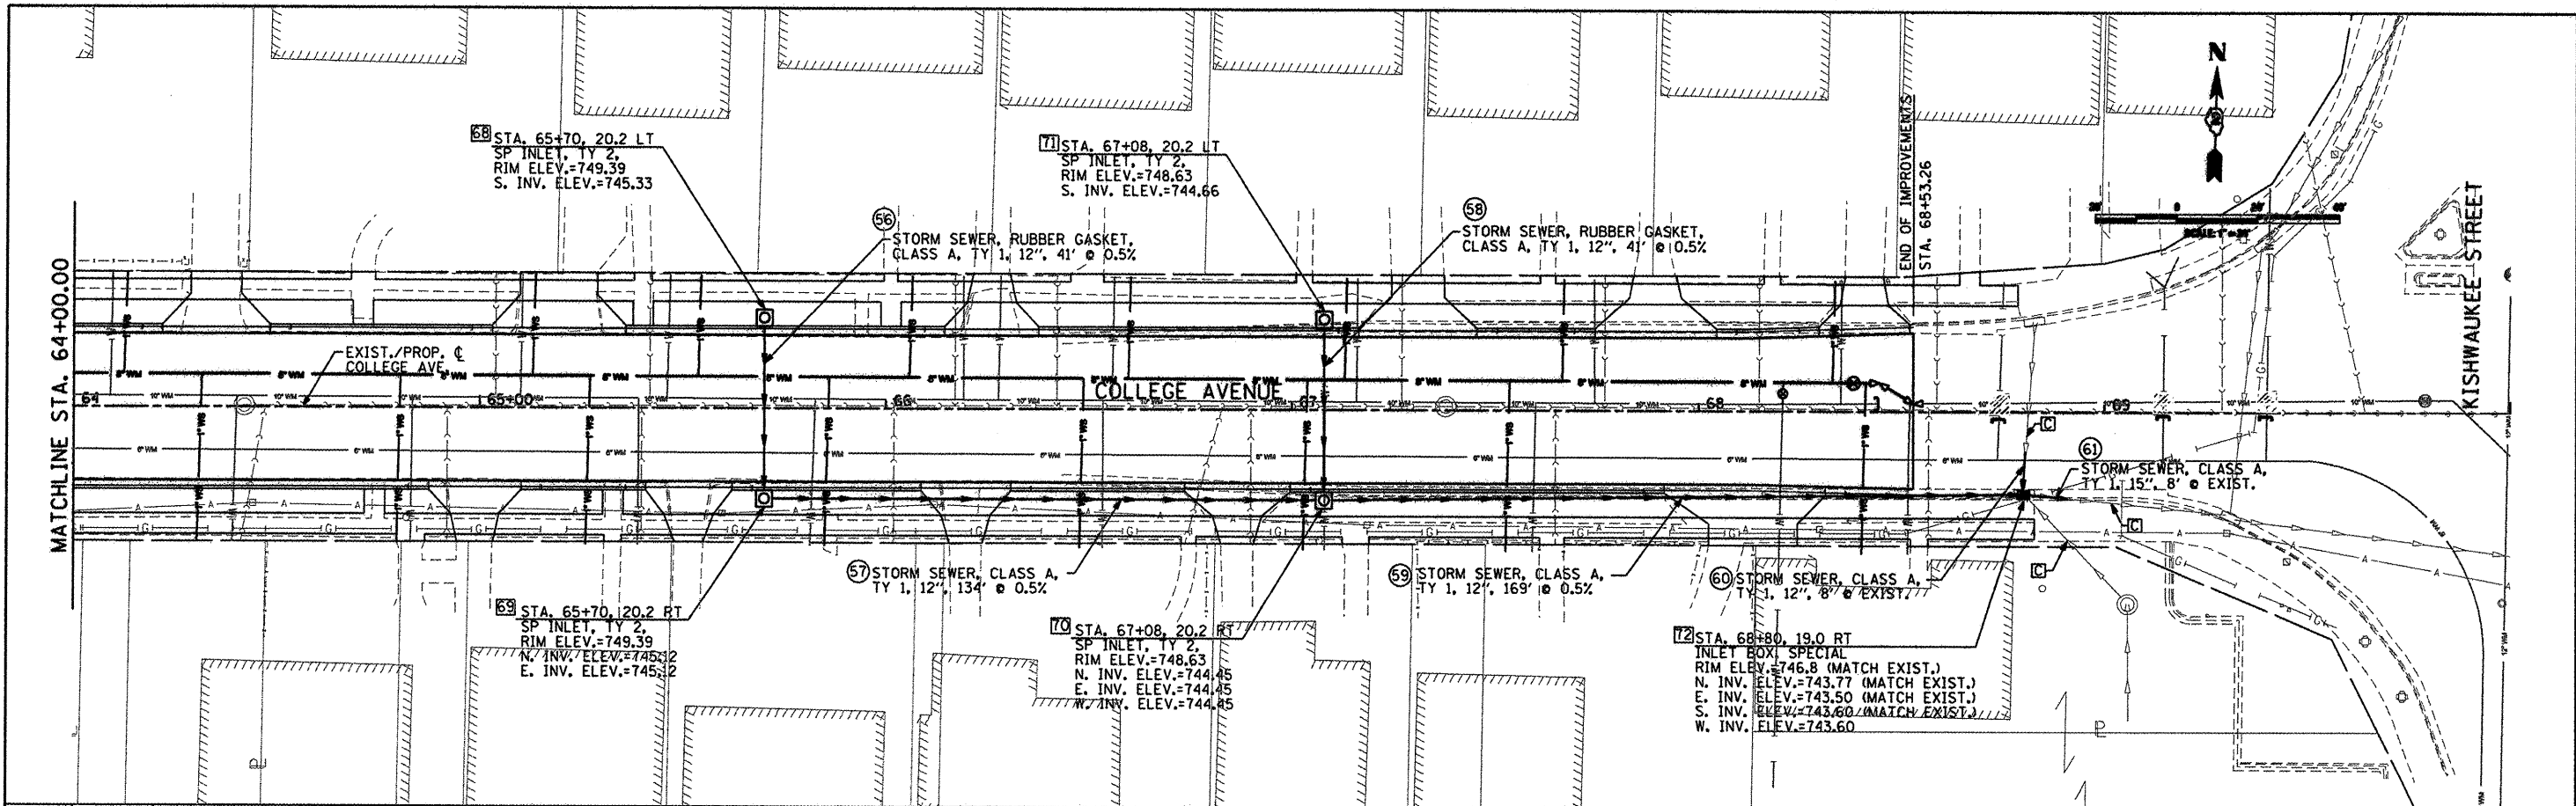

750.35 750.15	750.25 750.11	750.11 750.00	749.90 749.87	749.71 749.73	749.53 749.59	749.36 749.45	749.22 749.32	749.09 749.18	748.96 749.04	748.74 748.90	748.52 748.77	748.37 748.63	748.24 748.48	748.04 748.30	747.83 748.09	747.64 747.85	747.45 747.60	747.32 747.35	747.20	747.08	747.04	747.12	747.31	747.44
64+00	64+50	65+00	65+50	66+00	66+50	67+00	67+50	68+00	68+50	69+00	69+50	70+00												

CMT CONSULTING ENGINEERS License No. 184-000613

USER NAME	Steve Prange
DESIGNED	SJP / MNB
DRAWN	ERD
CHECKED	SJP
DATE	02/04/2011

REVISED	-
REVISED	-
REVISED	-
REVISED	-

**CITY OF ROCKFORD
MORGAN STREET BRIDGE**

SCALE:	1" = 20'
SHEET NO.	6 OF 11 SHEETS
STA.	64+00 TO STA. 70+00

**PROPOSED DRAINAGE PLAN & PROFILE
MORGAN STREET / COLLEGE AVENUE**

F.A. RTE.	SECTION	COUNTY	TOTAL SHEETS
5077	99-00493-00-BR	WINNEBAGO	253
CONTRACT NO. 85529			47
FED. ROAD DIST. NO. 2 [ILLINOIS]			FED. AID PROJECT BRN-5099659