

CONTRACT NO. 76D61	
F.A. ROUTE	SECTION
999	82-1B-2
FED. AID PROJECT	ILLINOIS
COUNTY	ST. CLAIR
USER NAME = jcolliff	
PLOT SCALE = #SCALE#	
PLOT DATE = 4/14/2010	
DESIGNED -	HNTB
CHECKED -	CMT
DRAWN -	CMT / HNTB
REVISED -	
REVISED -	
REVISED -	
REVISED -	



ILLINOIS APPROACH STRUCTURE  
FOR NEW I-70 MISSISSIPPI RIVER BRIDGE

STATE OF ILLINOIS  
DEPARTMENT OF TRANSPORTATION

MISSOURI HIGHWAYS  
AND TRANSPORTATION COMMISSION

**HNTB**  
715 KIRK DRIVE  
KANSAS CITY, MO 64105  
TELEPHONE (816) 472-1201  
CERTIFICATE OF AUTHORITY  
NO. 001270

**CMT**  
CRANFORD, MURPHY & TILLY, INC.  
2750 WEST WASHINGTON STREET  
SPRINGFIELD, IL 62702  
TELEPHONE (217) 787-8050  
ENGINEERING CORPORATION - 000631

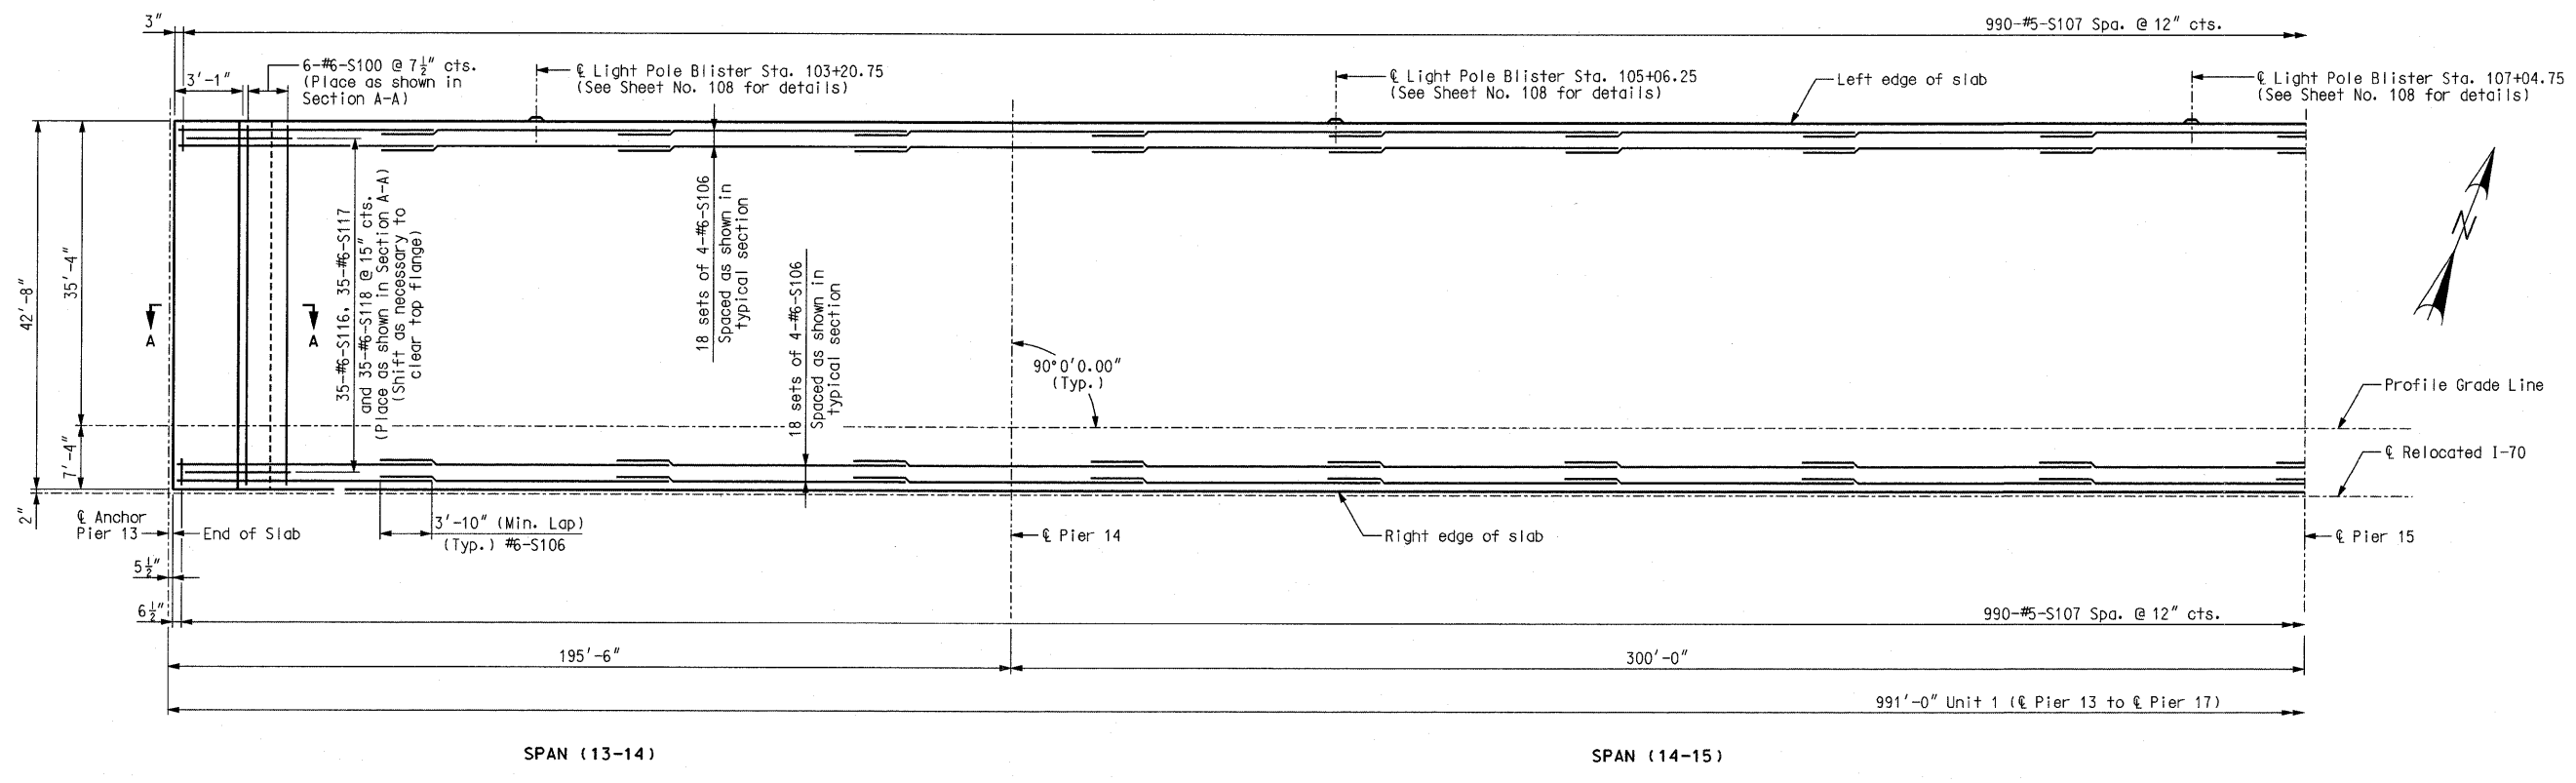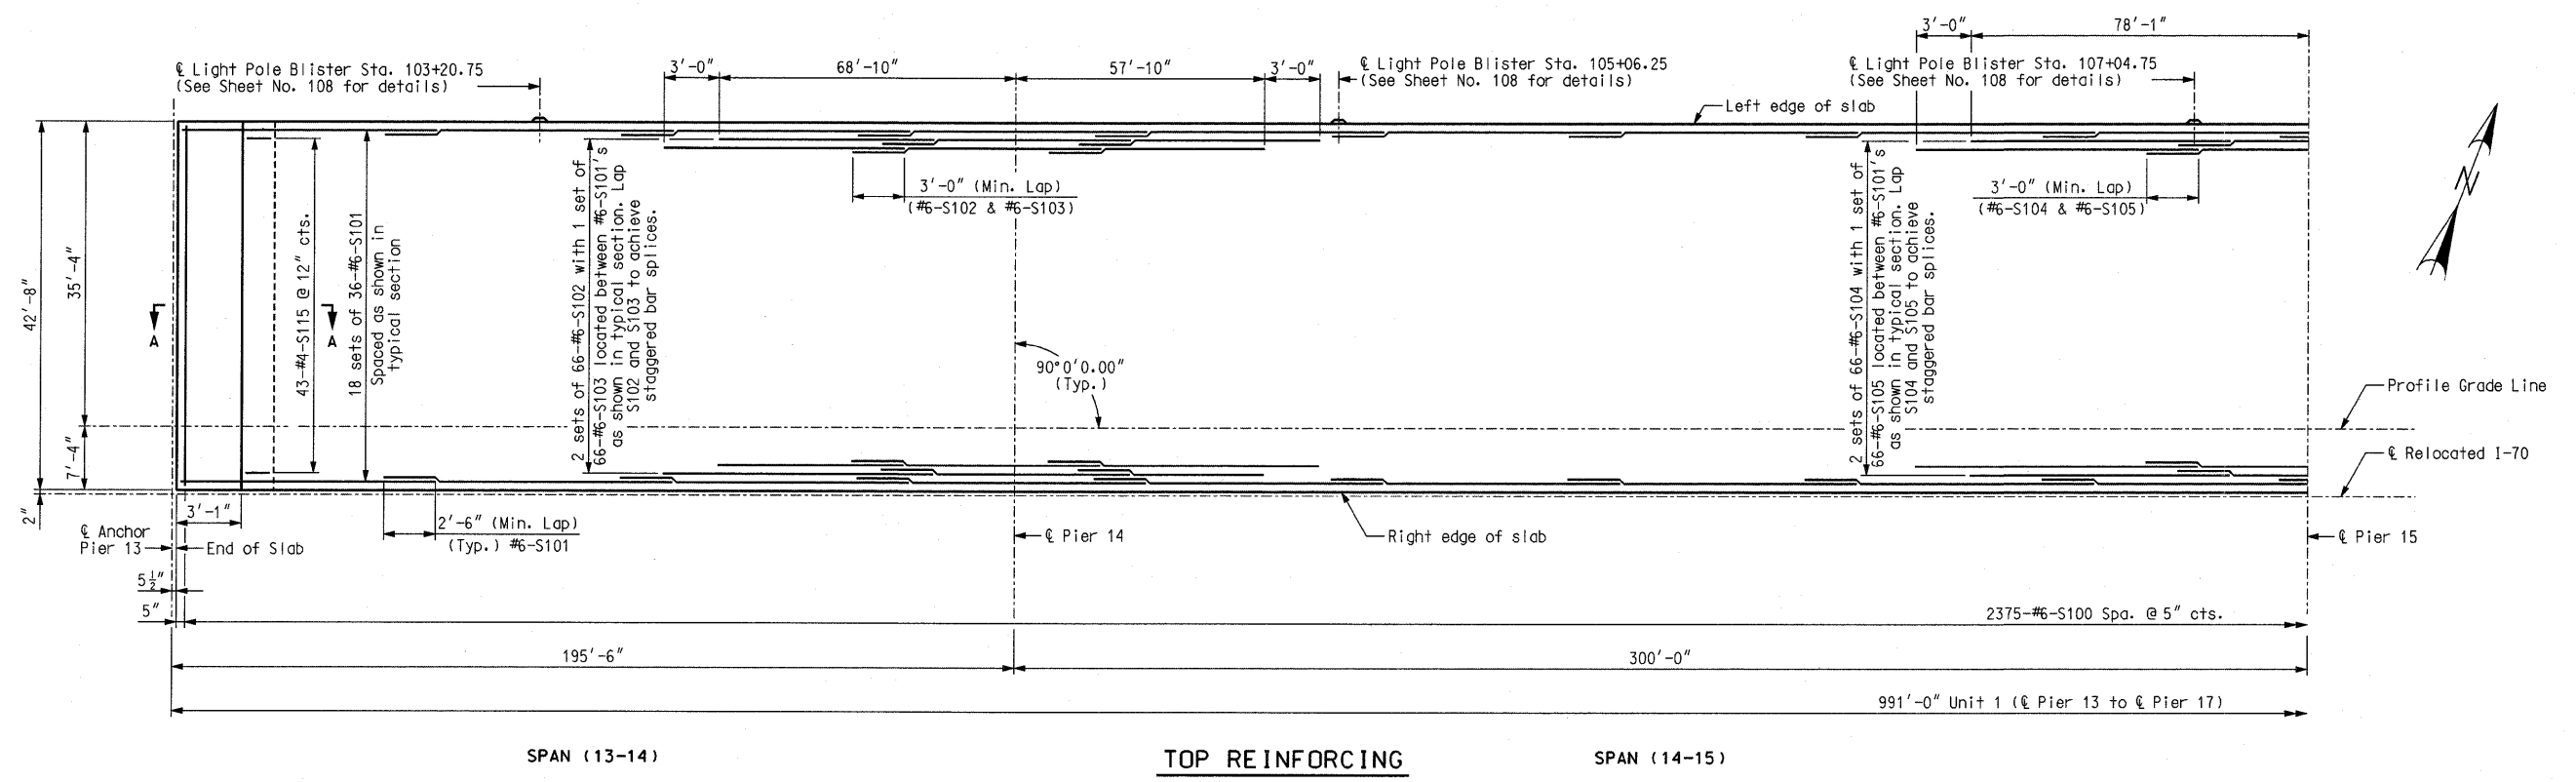

Notes:  
For typical bridge section and reinforcing, see Sheet No. 102.  
For location of slab drains, see Sheet No. 127.  
For details and reinforcing of barrier curbs, see Sheet Nos. 109 thru 117.  
For slab pouring sequence, see Sheet No. 106.  
Longitudinal slab dimensions are measured horizontally. See Sheet No. 100 for Section A-A.  
Light poles, lights and other electrical appurtenances are by others. See electrical details in contract J610984 - MoDOT.

Detailed JUL 2009  
Checked JUL 2009

Note: This drawing is not to scale. Follow dimensions.

Sheet No. 90 of 152

SLAB PLAN SHOWING REINFORCING WB - UNIT 1 (1 OF 2)