 


PE086

REVISIONS		
NUMBER	BY	DATE

0 1 2
 THIS BAR IS EQUAL TO 2"
 AT FULL SCALE (34X22).
 PLOT 1



- LEGEND**
- ⊙ EXISTING TAXIWAY EDGE LIGHT
 - PROPOSED BASE MOUNTED TAXIWAY EDGE LIGHT
 - PROPOSED IN-PAVEMENT TAXIWAY EDGE LIGHT
 - ▬ PROPOSED DIRECTIONAL BORE
 - PROPOSED 1 EACH, 1/8" #8 L-824, TYPE C 5VK CABLE, IN UNIT DUCT

CLOSED TAXIWAY

EXISTING FUEL FARM


PROPOSED PERIMETER ROAD

PROPOSED PERIMETER ROAD

EXISTING EDGE LIGHTS TO BE REMOVED. EXISTING CABLE TO REMAIN IN PLACE.

EXISTING EDGE LIGHTS TO BE REMOVED. EXISTING CABLE TO REMAIN IN PLACE.

PROPOSED CABLE 1-EACH, 1/8" #8, L-824, TYPE C, 5VK CABLE, IN UNIT DUCT

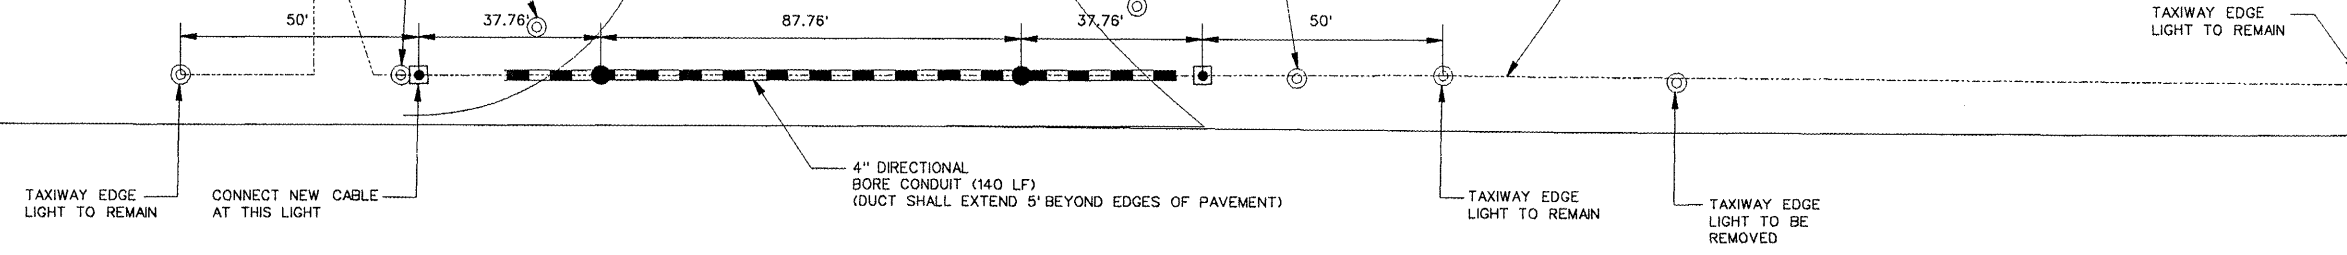

TAXIWAY A

GREATER Peoria REGIONAL Airport

CONSTRUCT NEW PERIMETER ROAD AND PERIMETER FENCE - PROJECT 1

CMT CRAWFORD, MURPHY, & TILLY, INC. CONSULTING ENGINEERS

IL PROJECT: PIA-3343 AIP PROJ: 3-17-0080-XX
FILE: ... \031_electrical_plan_01.dgn
DESIGN BY: TWM, RBL
DRAWN BY: CAG
CHECKED BY: RBL
APPROVED BY: GET
DATE: APRIL 24, 2008
JOB No: 0706104
AIRFIELD ELECTRICAL LAYOUT PLAN
SHEET 31 OF 140 SHEETS

4/23/2008 K:\Peoria\0706104\Draw\Sheets\031_electrical_plan_01.dgn