
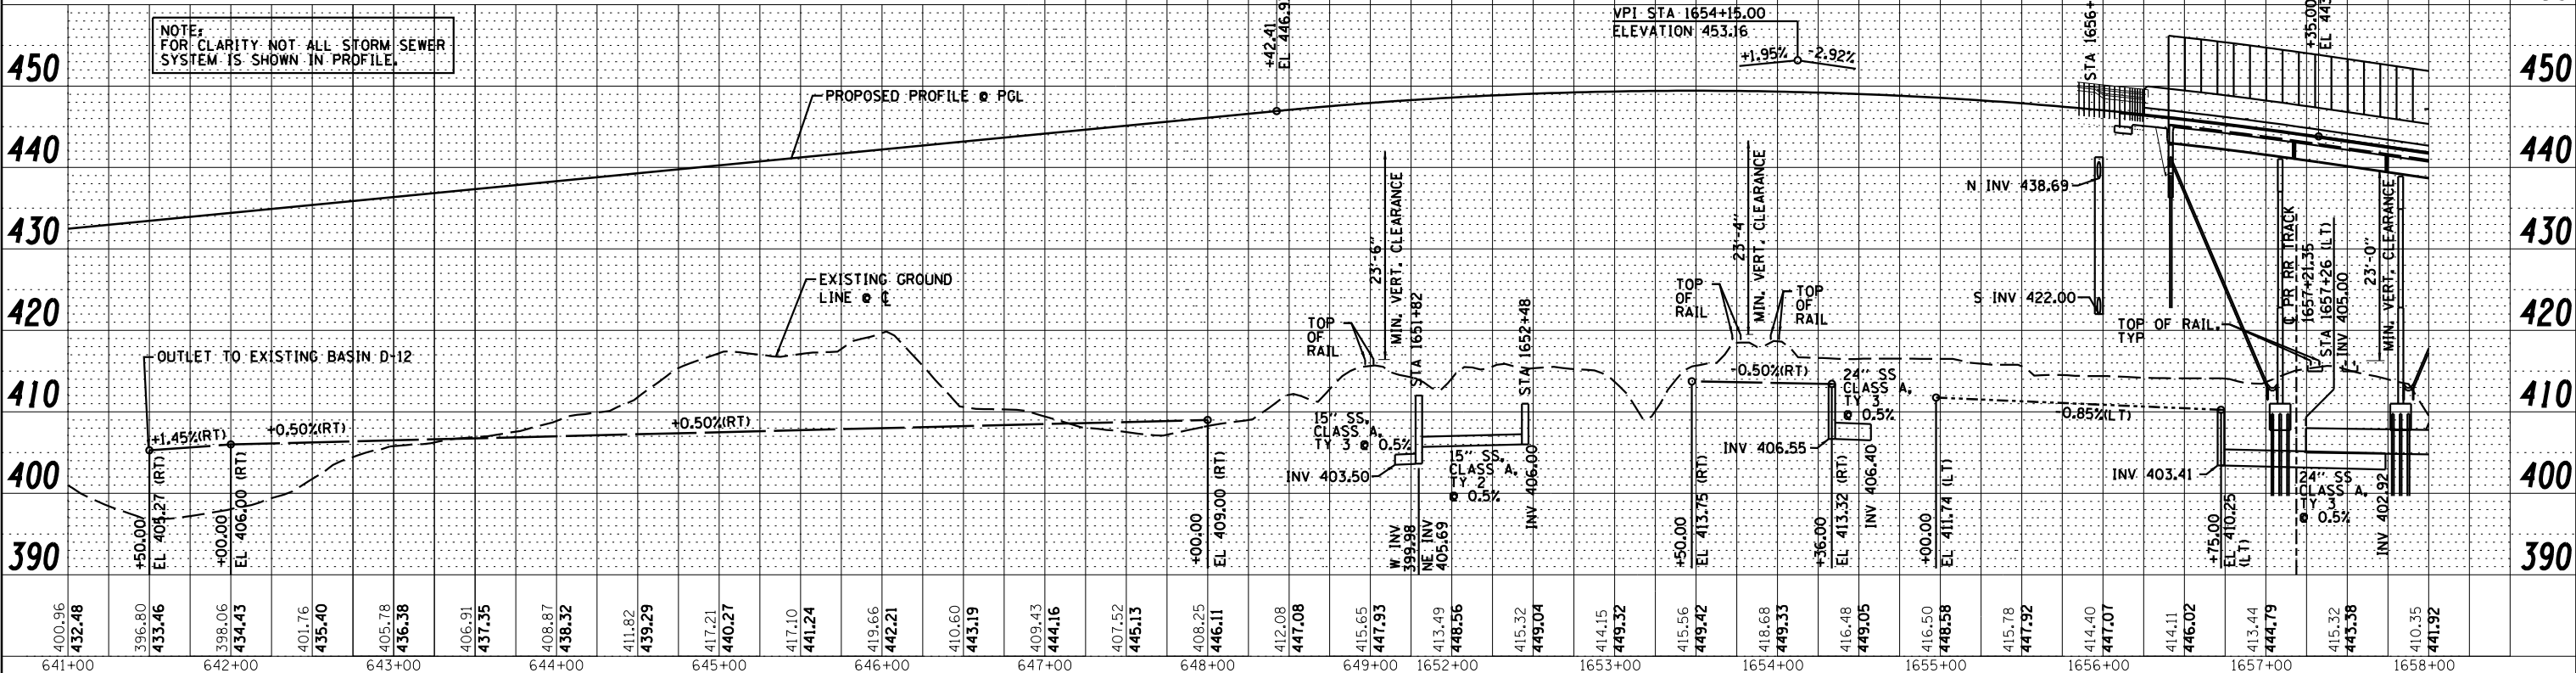


| | | |
|------|-----------------|------|
| PLAN | SURVEYED | DATE |
| | PLOTTED | BY |
| | GRADES CHECKED | |
| | STRUCTURE NOTED | |
| | NO. 1 | |

| | | |
|---------|-----------------|------|
| PROFILE | SURVEYED | DATE |
| | PLOTTED | BY |
| | GRADES CHECKED | |
| | STRUCTURE NOTED | |
| | NO. 1 | |

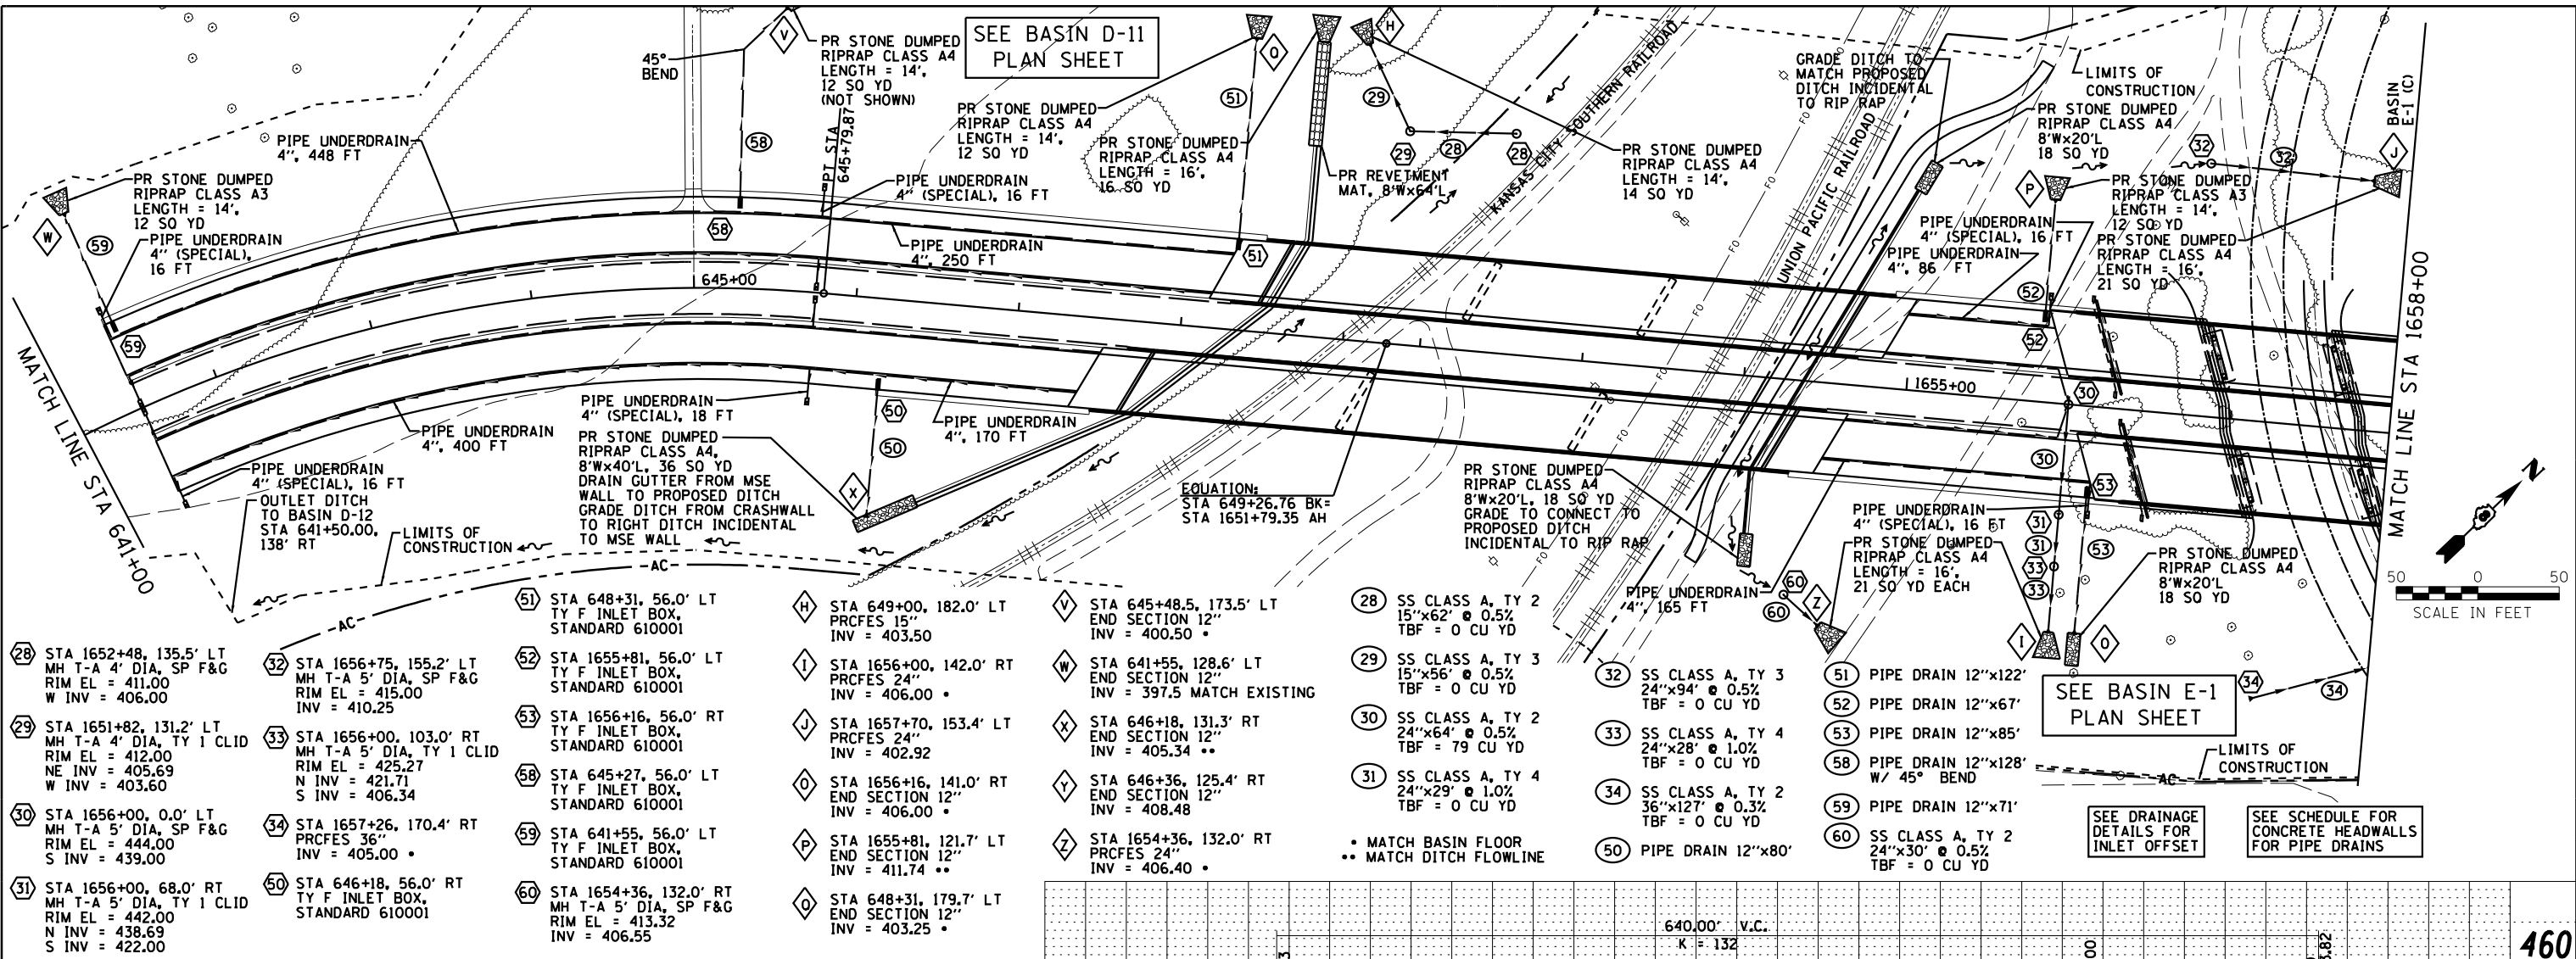

| | | | | | | | | |
|---|--|---|--|---|---------------------------|------------------------------------|------|---|
| Farnsworth GROUP, INC. 2705 McGraw Drive Bloomington, Illinois 61704 309/663-8435, 309/663-1571 fax | USER NAME = dmeyer DESIGNED - JJO DRAWN - JJO PLOT SCALE = 100.0000' / 1" | DESIGNED - JJO DRAWN - JJO CHECKED - PJM DATE - 12/10/12 | REVISED - 02/06/13 REVISED - 03/15/13 REVISED - REVISED - | STATE OF ILLINOIS DEPARTMENT OF TRANSPORTATION | | DRAINAGE PLAN & PROFILE | | F.A.P. R.T.E. 788 SECTION 520-1-2HVB, 520-1-2HVB-1 COUNTY ST. CLAIR TOTAL SHEETS 237 SHEET NO. 33 CONTRACT NO. 76848 |
| | SCALE: SHEET NO. OF SHEETS STA. TO STA. | | | | ILLINOIS FED. AID PROJECT | | PP-2 | |