

F.A.I. RTE.	SECTION	COUNTY	TOTAL SHEETS	SHEET NO.
94	*	COOK	36	21
STA. 89+90		TO STA. 103+00		
FED. ROAD DIST. NO.	ILLINOIS FED. AID PROJECT			
* 2005-014L				62937

J:\75-Dgn\RD2753B-EL-01-02.Dwg




LEGEND

- EXISTING LIGHTING UNIT TO REMAIN
- EXISTING ELECTRIC HANDHOLE (PROVIDED UNDER SEPARATE CONTRACT)
- UNDERGROUND REINFORCED CONCRETE ENCASED CNC DUCTBANK. (PROVIDED UNDER SEPARATE CONTRACT).
- EXISTING LIGHTING CIRCUIT
- AERIAL CABLE TO BE REMOVED
- TEMPORARY LIGHTING UNIT TO BE REMOVED
- EXISTING LIGHTING UNIT TO BE REMOVED

NOTES:

1. UNLESS NOTED OTHERWISE, ALL ITEMS AND WORK SHOWN IN HEAVY LINE WEIGHT ON THIS DRAWING ARE PROPOSED NEW ITEMS OF WORK.
2. COORDINATE ALL WORK WITH IDOT ELECTRICAL CONTRACT 62583 AND CIVIL CONTRACTS 62694, 62695, 62304 AND 62593.
3. REMOVAL OF LIGHT POLES, WOOD POLES AND LUMINAIRES ARE PART OF CONTRACT 62937. FOUNDATION REMOVAL WILL BE DONE UNDER SEPARATE CONTRACT.

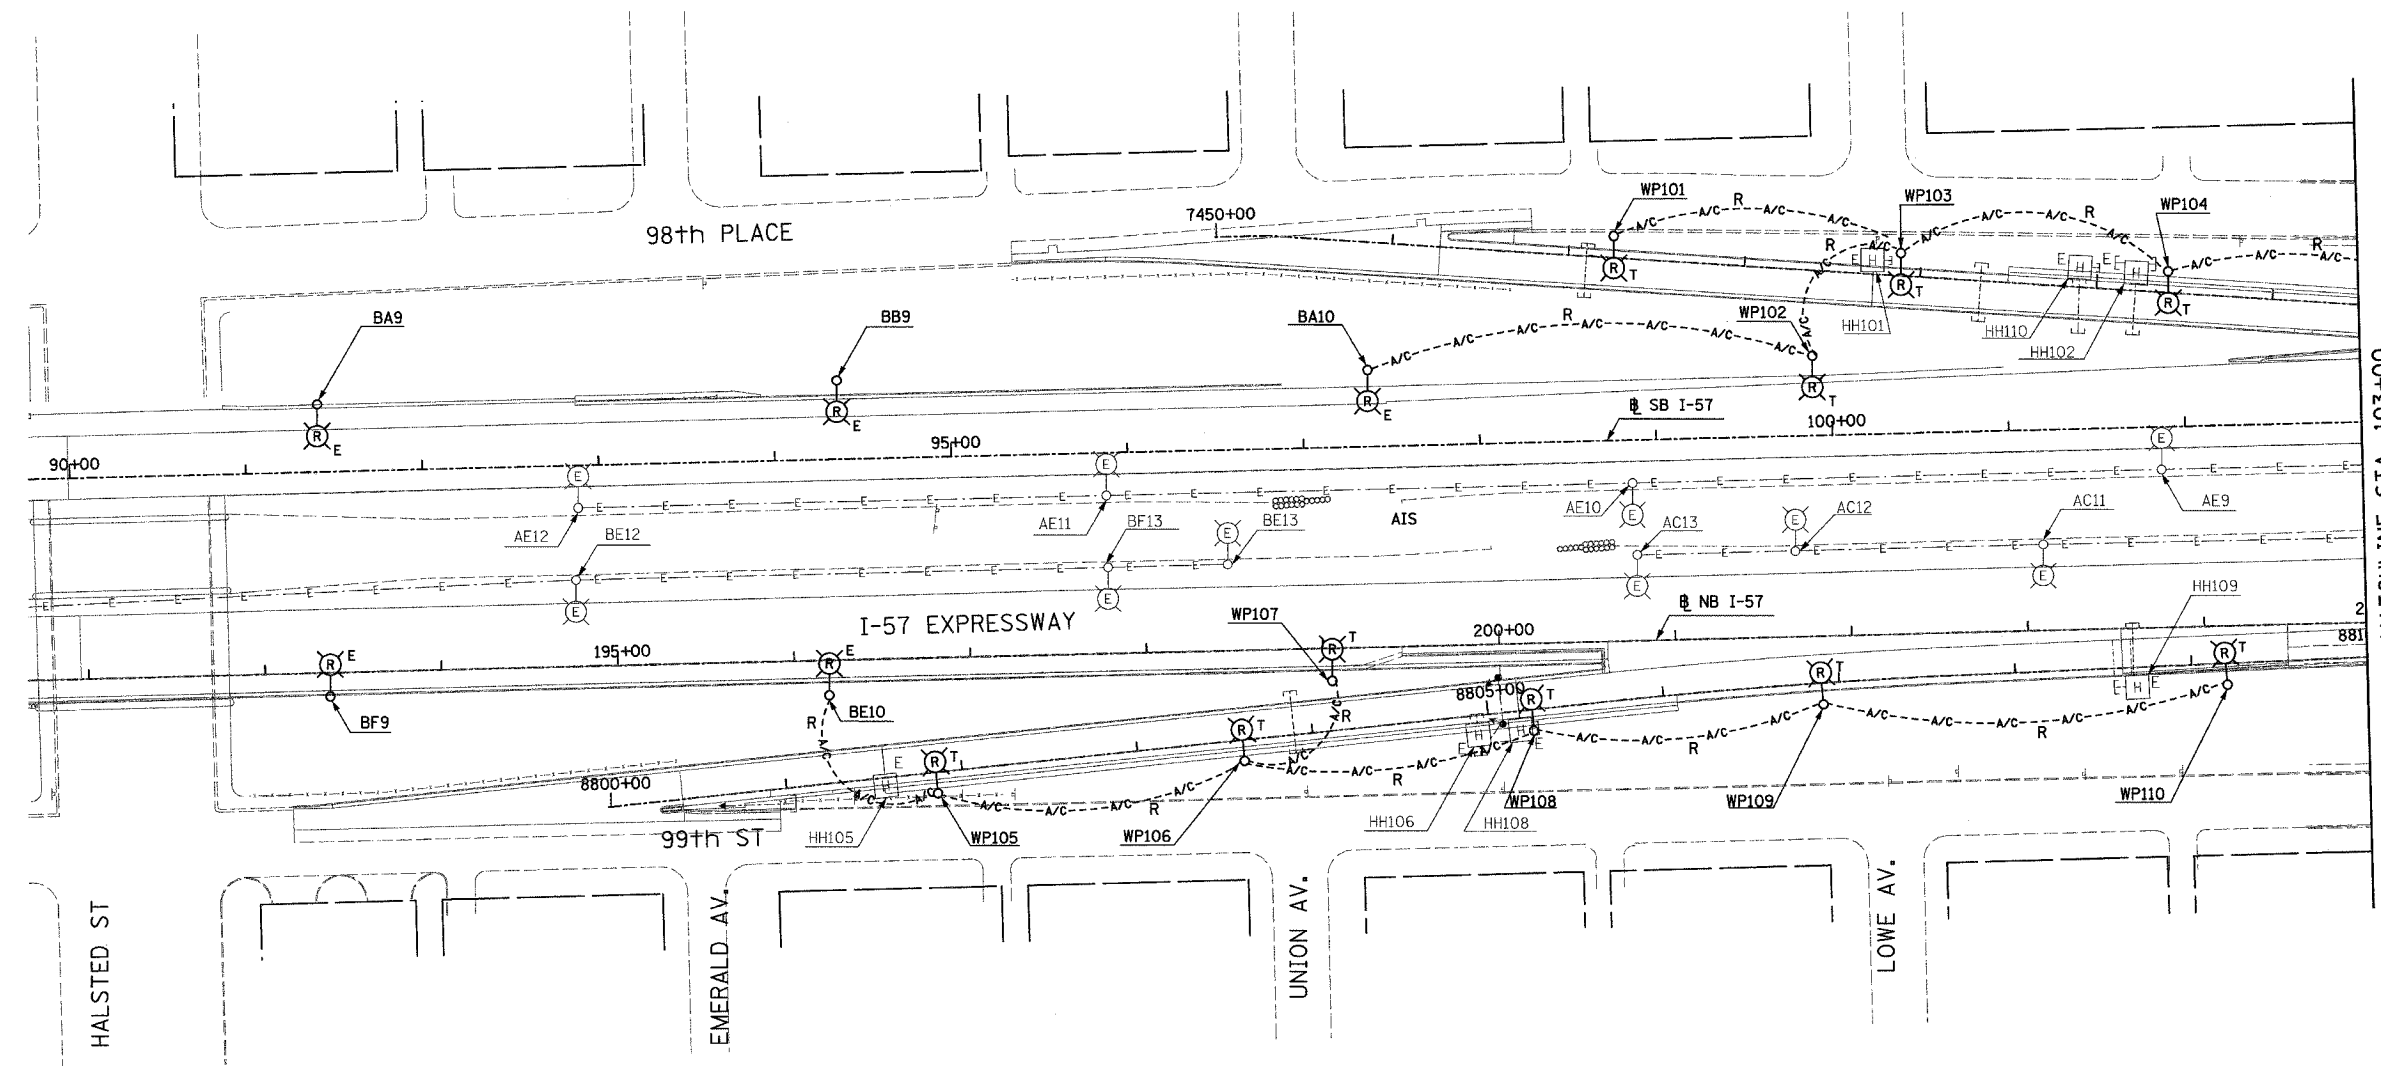

MATCHLINE STA. 103+00
SEE SHEET EL-02



2D/EL-01

SINGH 300 W. ADAMS ST.
CHICAGO, IL 60606
SINGH & ASSOCIATES, INC. TEL: (312) 629-0240
CONSULTING ENGINEERS FAX: (312) 629-8449

REVISIONS	
NAME	DATE

ILLINOIS DEPARTMENT OF TRANSPORTATION
F.A.I. 94 (DAN RYAN EXPRESSWAY)

ROADWAY LIGHTING PLANS
EXISTING AND REMOVAL

SCALE: 1"=50' DRAWN BY: VG
DATE: JANUARY 13, 2006 CHECKED BY: TM

12/23/06 PM 17/11/2006