


F.A.I. RTE.	SECTION	COUNTY	TOTAL SHEETS	SHEET NO.
94		COOK	36	24
STA. 1124+50		TO STA. 1112+50		
FED. ROAD DIST. NO.	ILLINOIS	FED. AID PROJECT		
• 2005-014L		62937		

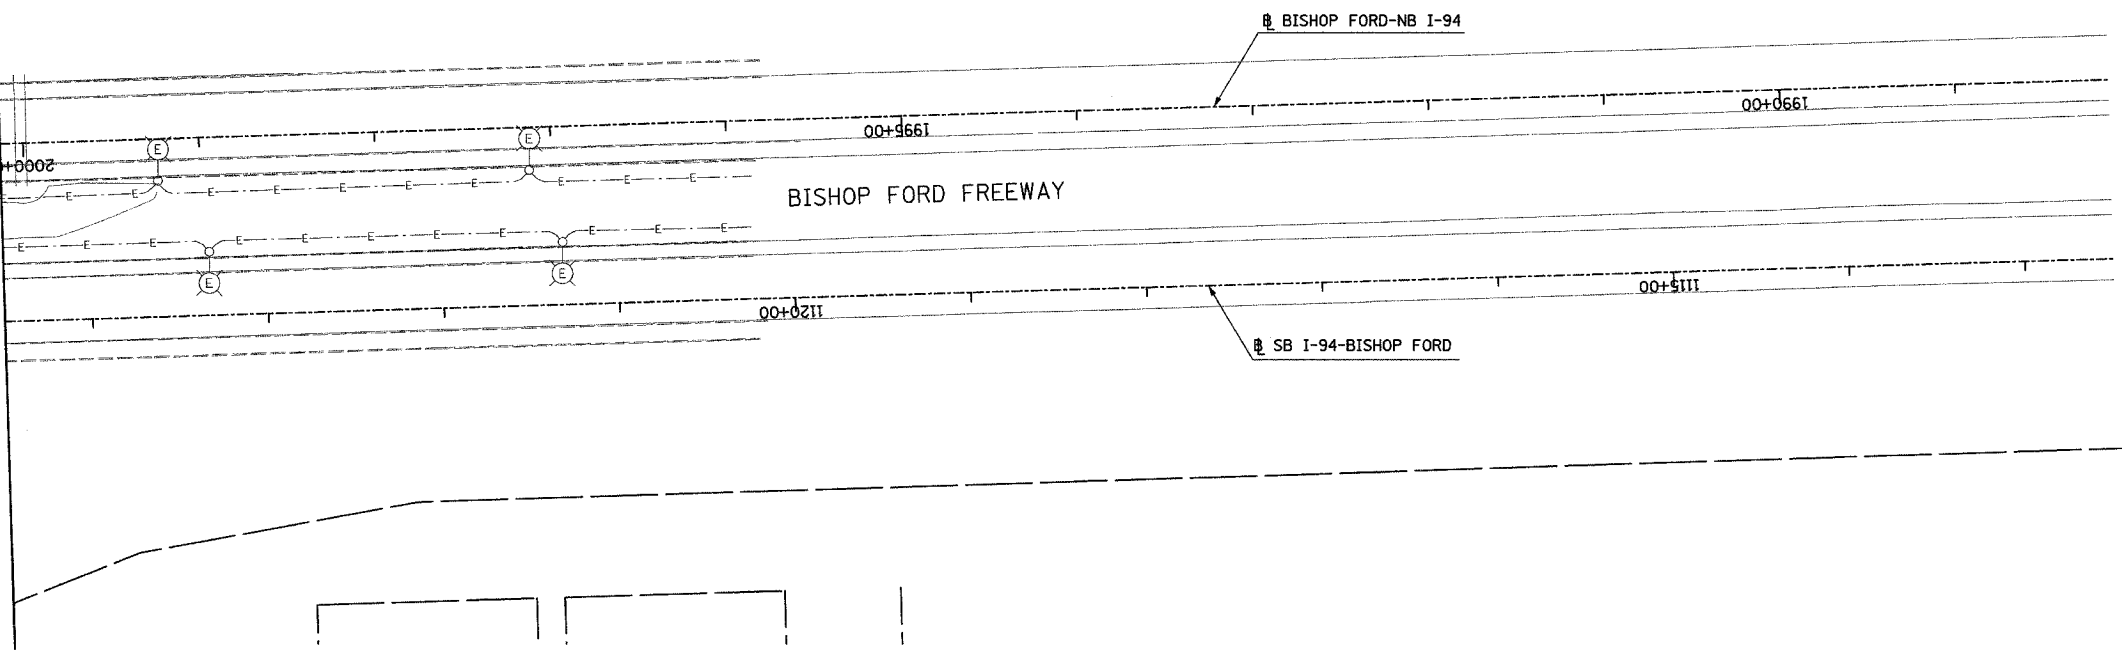

MATCH LINE STA. 1124+50
SEE SHEET EL-08

 


LEGEND

EXISTING LIGHTING UNIT TO REMAIN

EXISTING LIGHTING CIRCUIT

NO ELECTRICAL WORK ON THIS SHEET
FOR REFERENCE ONLY



2D/EL-08A

SINGH 300 W. ADAMS ST.
CHICAGO, IL 60606
SINGH & ASSOCIATES, INC. TEL: (312) 629-0240
CONSULTING ENGINEERS FAX: (312) 629-8449

REVISIONS	
NAME	DATE

ILLINOIS DEPARTMENT OF TRANSPORTATION
F.A.I. 94 (DAN RYAN EXPRESSWAY)

ROADWAY LIGHTING PLANS
EXISTING AND REMOVAL

SCALE: 1"=50' DRAWN BY: VG
DATE: JANUARY 13, 2006 CHECKED BY: TM

12:58:06 PM 1/11/2006