


F.A.P. RTE.	SECTION	COUNTY	TOTAL SHEETS	SHEET NO.
80/94	1999-161-1	COOK	75	44
STA.		TO STA.		
FED. ROAD DIST. NO.	ILLINOIS	FED. AID PROJECT		
D-91-411-99				

IDOT PS26 ELECTRICAL SYSTEM ONE LINE DIAGRAM

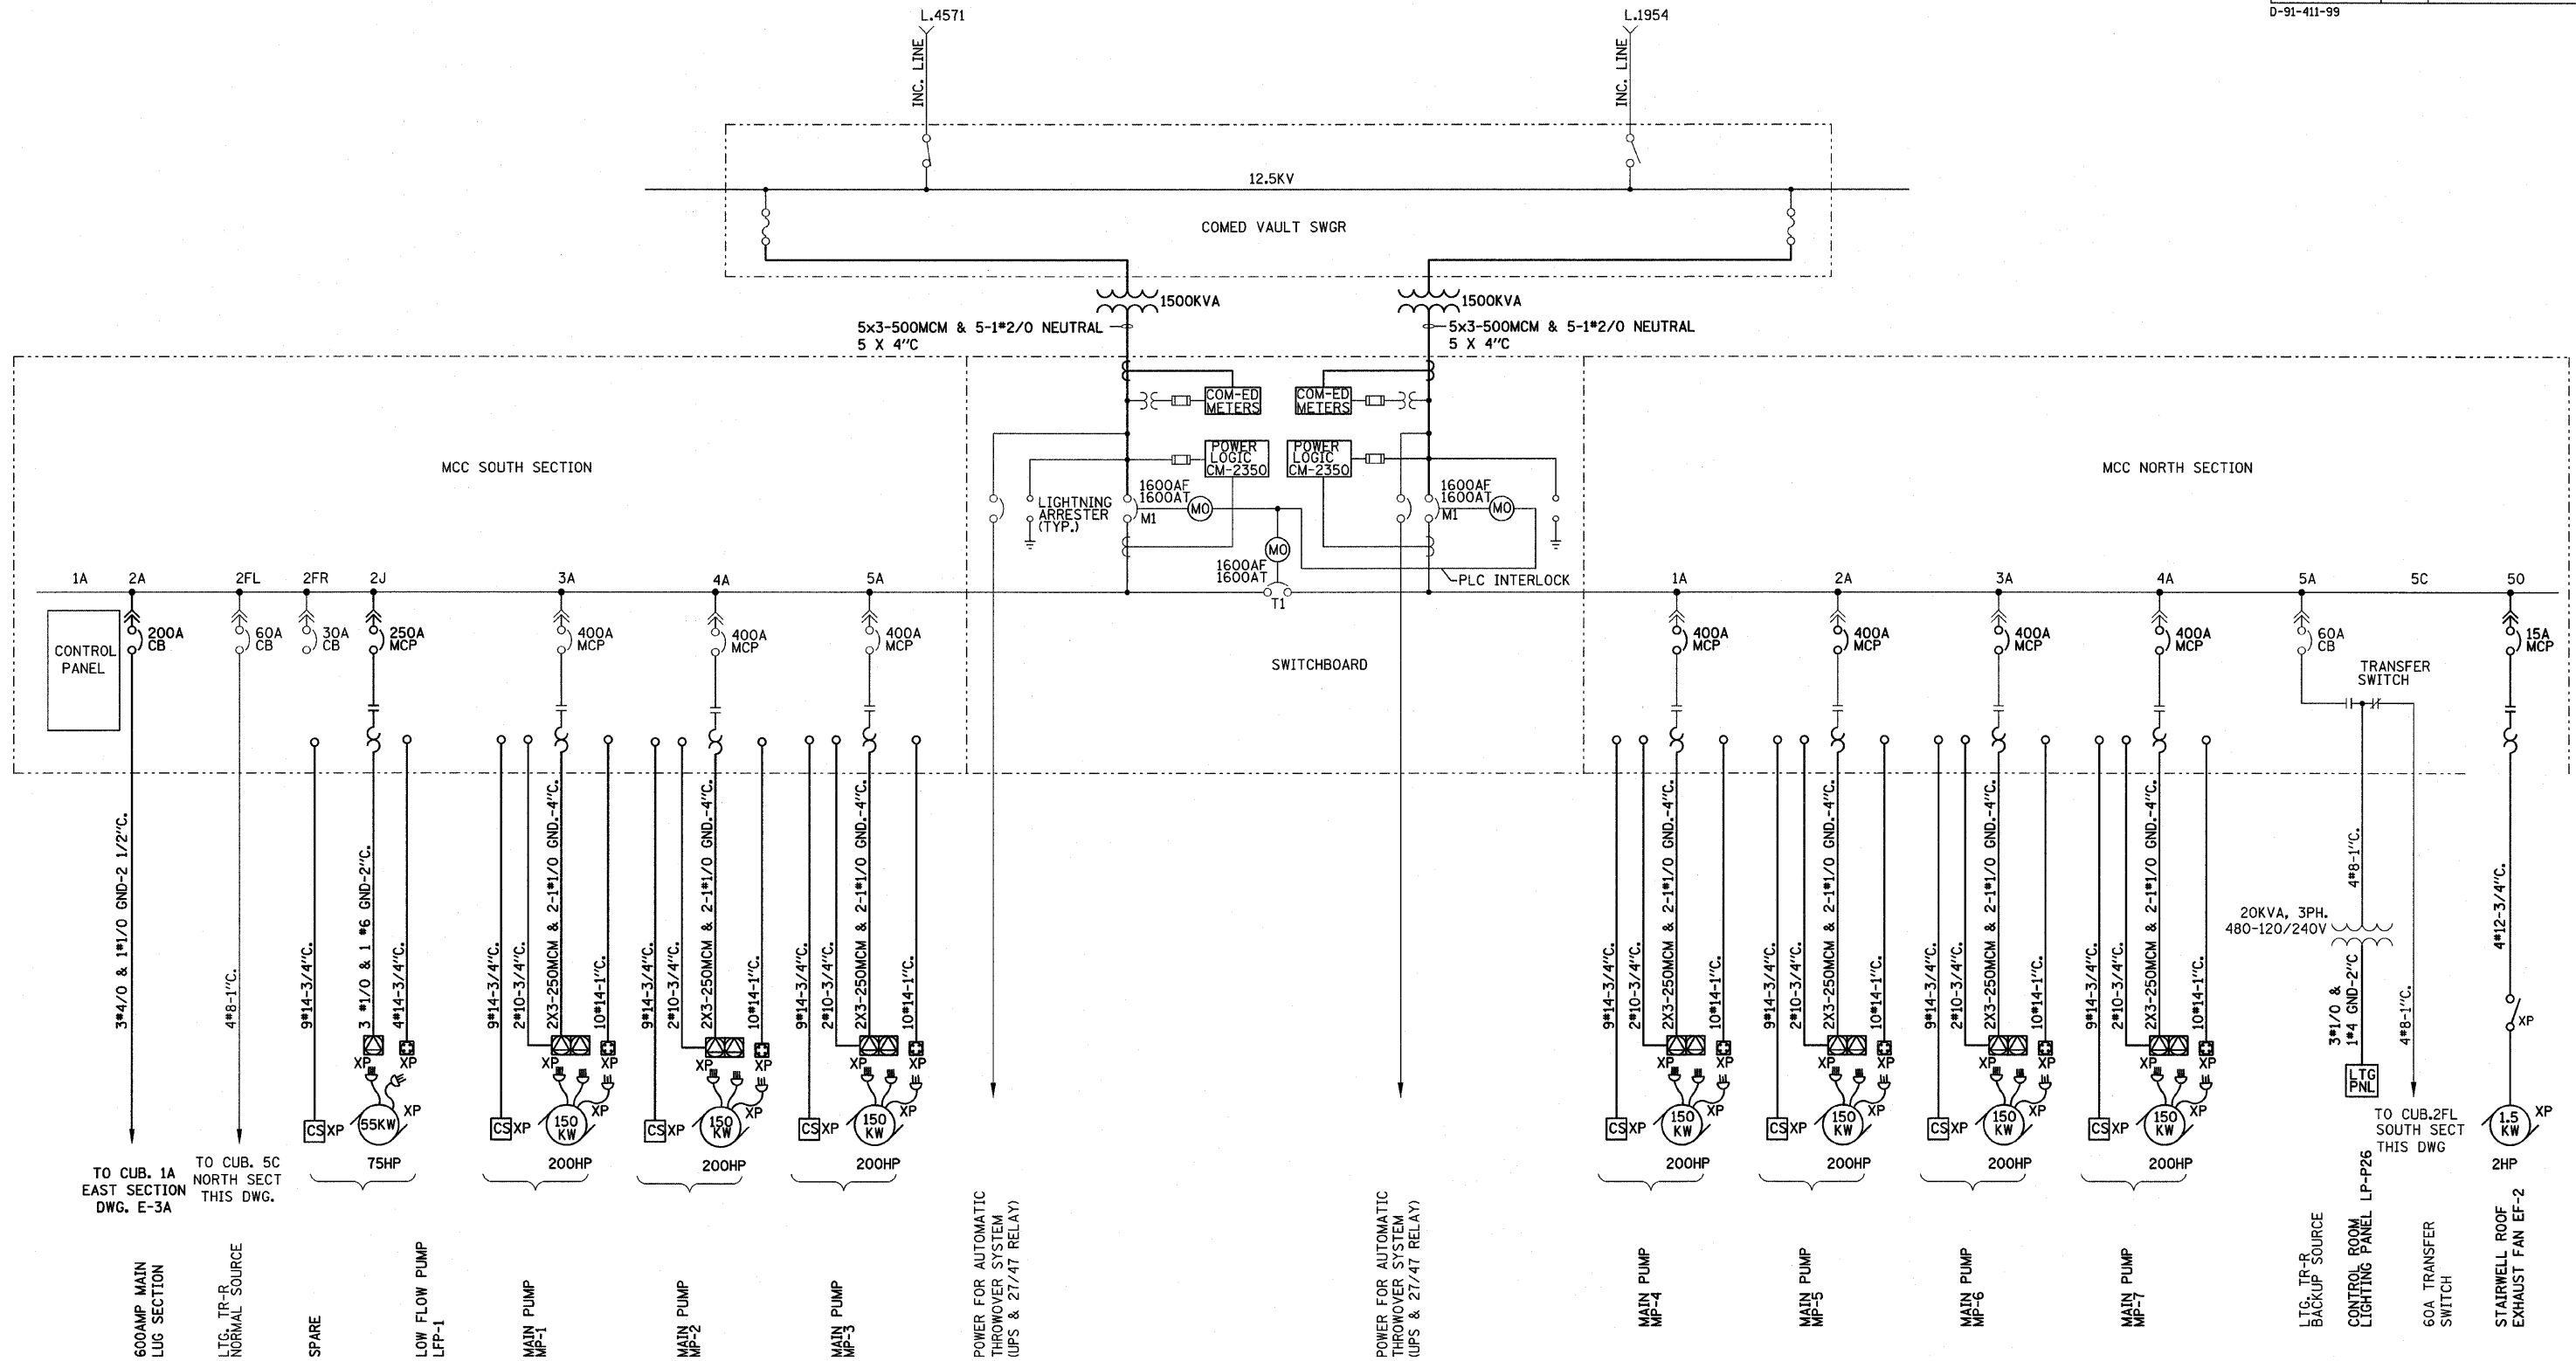

NOTES:

1. ALL NEW EQUIPMENT SHOWN AS BOLD LINES.



REVISIONS	
NAME	DATE

ILLINOIS DEPARTMENT OF TRANSPORTATION
MCC-PS26 ONE LINE DIAGRAM - SHEET 1
 SCALE: VERT. NO SCALE
 HORIZ. DATE: 3/23/2010
 DRAWN BY: B.K.
 CHECKED BY: M.Z.

PLOT DATE = 3/22/2010
 FILE NAME = D:\88828-sh1-E-03.dgn
 PLOT SCALE = 1:1
 USER NAME = MUSENY