


F.A.P. R/E.	SECTION	COUNTY	TOTAL SHEETS	SHEET NO.
90/94	1999-161-1	COOK	75	62
STA.		TO STA.		
FED. ROAD DIST. NO.		ILLINOIS	FED. AID PROJECT	
D-91-411-99				

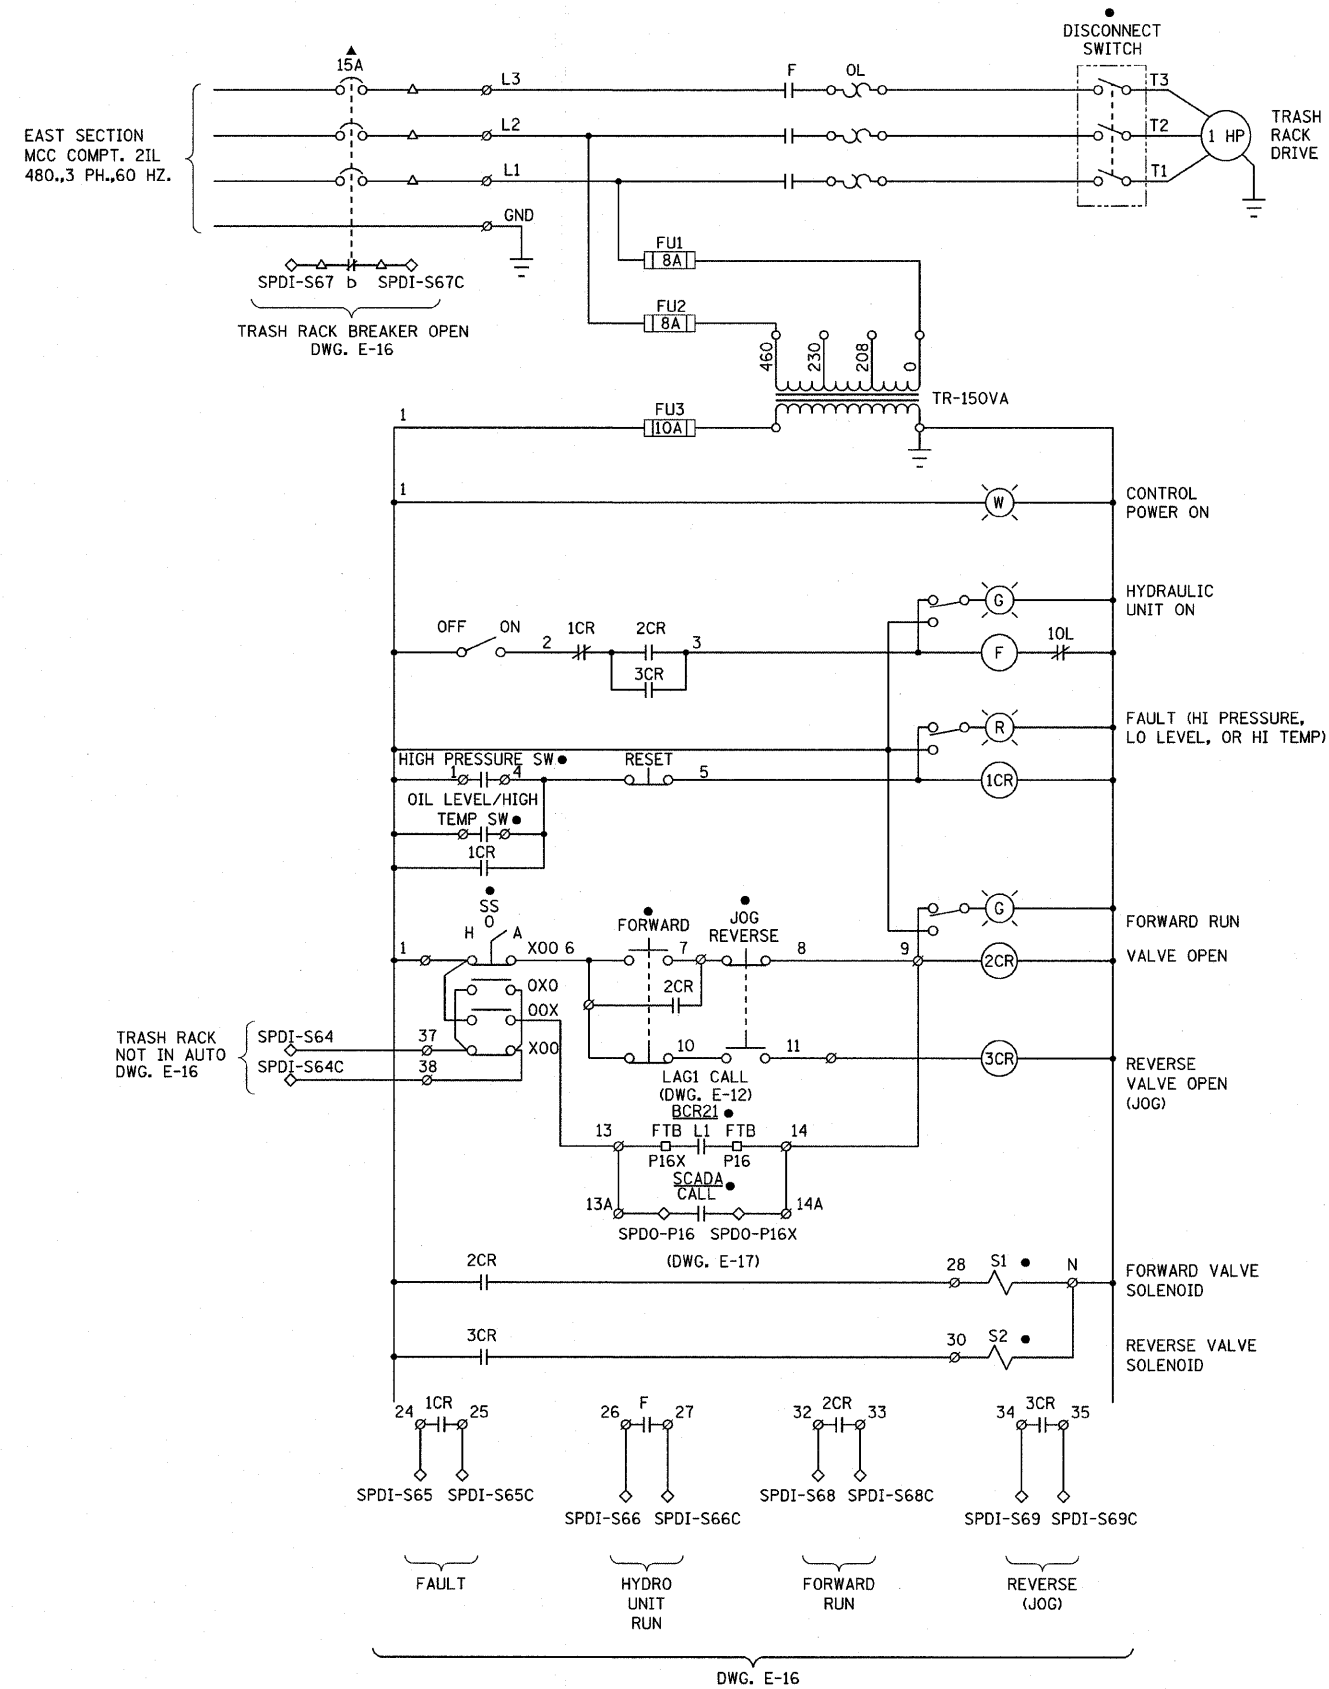

NOTES:

1. ALL DEVICES ARE LOCATED IN TRASH RACK CONTROL PANEL UNLESS NOTED OTHERWISE.
2. VERIFY WIRING WITH VENDOR AFTER EQUIPMENT HAS BEEN PURCHASED.

LEGEND:

- △ TERMINAL IN MCC
- TERMINAL IN CONTROL PANEL
- ◇ TERMINAL IN SCADA PANEL
- ∅ TERMINAL IN TRASH RACK CONTROL PANEL
- ▲ DEVICE LOCATED IN MCC
- DEVICE MOUNTED LOCALLY IN WATERPROOF AND EXPLOSION PROOF STATION

PLOT DATE = 3/22/2010
 FILE NAME = D:\8828\sh-h-E-28.dgn
 PLOT SCALE = 1:1
 USER NAME = WJSEB

REVISIONS	
NAME	DATE

ILLINOIS DEPARTMENT OF TRANSPORTATION
TRASH RACK DRIVE CONTROL SCHEMATICS

SCALE: VERT. NO SCALE
 HORIZ.
 DATE: 3/23/2010

DRAWN BY: B.K.
 CHECKED BY: M.Z.

