
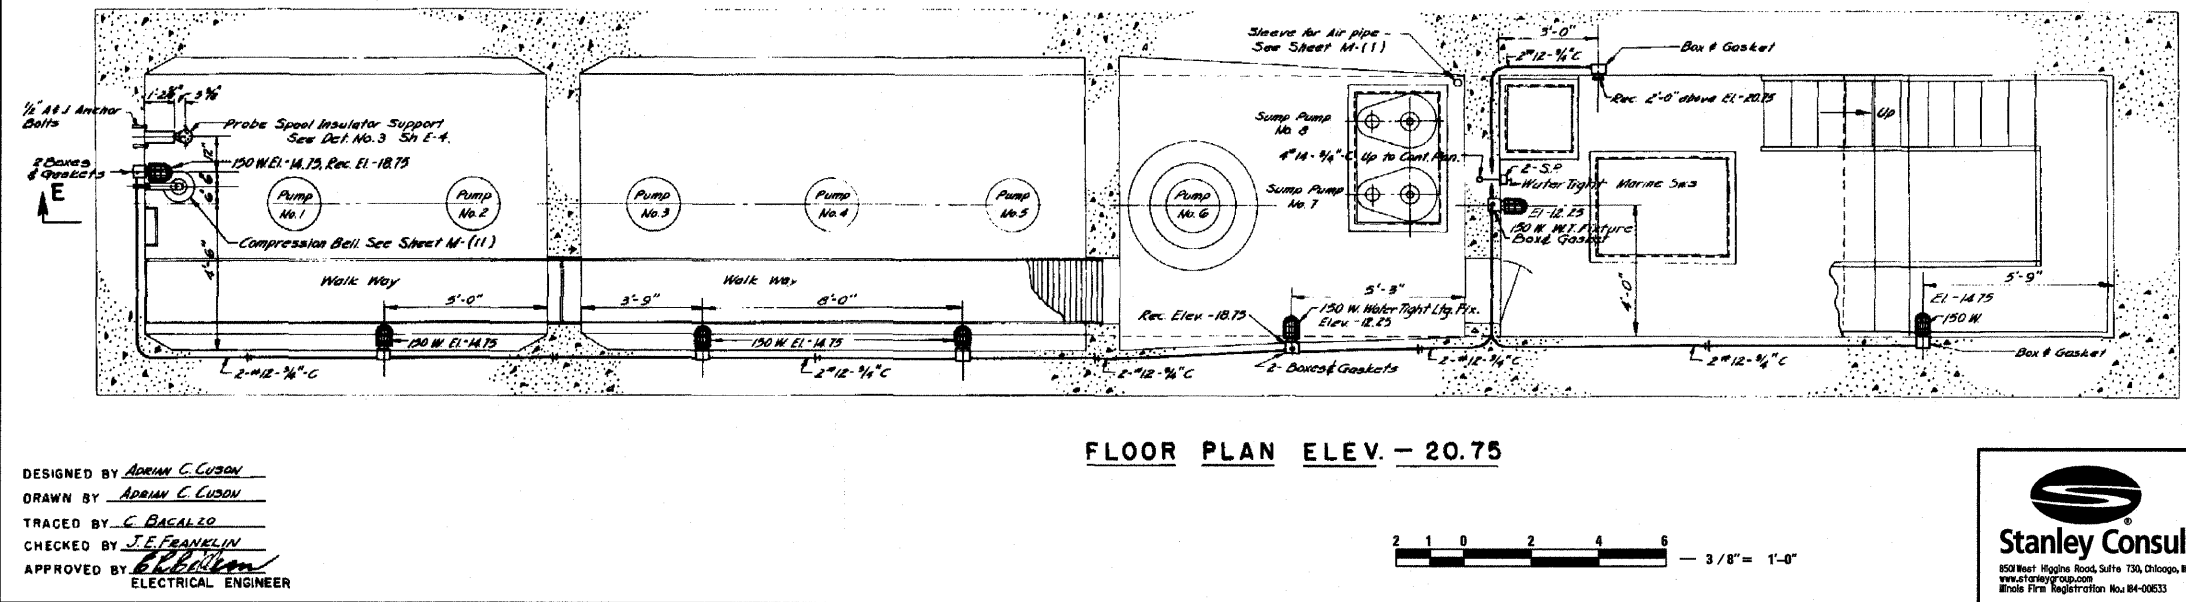


F.A.P. RTE.	SECTION	COUNTY	TOTAL SHEETS	SHEET NO.
90/94	1999-161-1	COOK	75	68
STA.		TO STA.		
FED. ROAD DIST. NO.		ILLINOIS FED. AID PROJECT		
D-91-411-99				

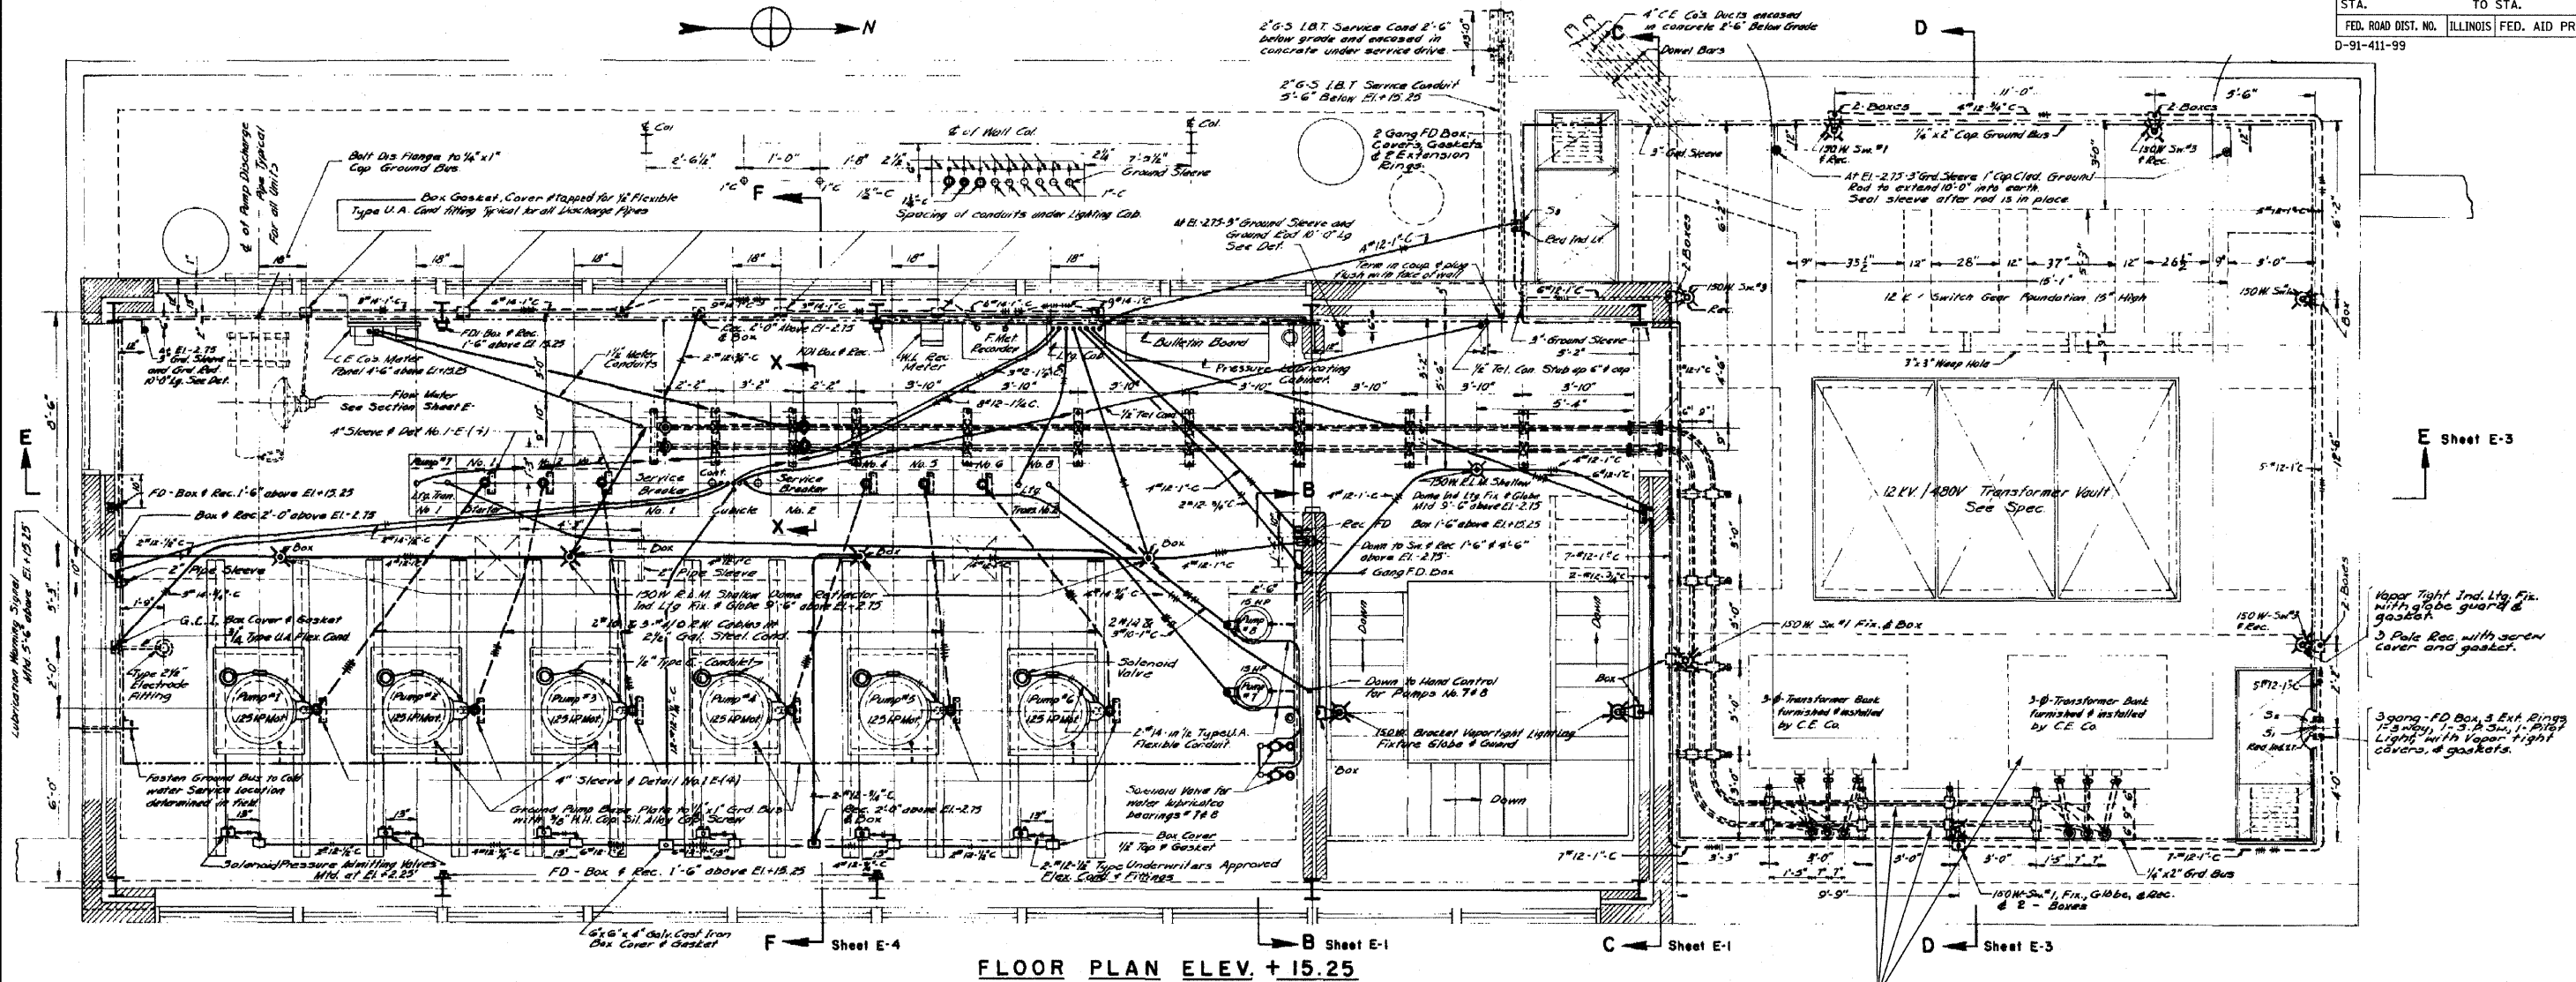

**DEMOLITION NOTES:**  
SEE DRAWING DE-1 FOR DEMOLITION NOTES

REVISIONS	
NAME	DATE

ILLINOIS DEPARTMENT OF TRANSPORTATION  
**DEMOLITION ELECTRICAL PLANS**  
SCALE: VERT. 3/8"=1'-0"  
HORIZ. 1"=1'-0"  
DATE: 3/23/2010  
DRAWN BY: B.K.  
CHECKED BY: M.Z.



DESIGNED BY ADRIAN C. CUSON  
DRAWN BY ADRIAN C. CUSON  
TRACED BY C. BACALZO  
CHECKED BY J.E. FRANKLIN  
APPROVED BY [Signature]  
ELECTRICAL ENGINEER

