

 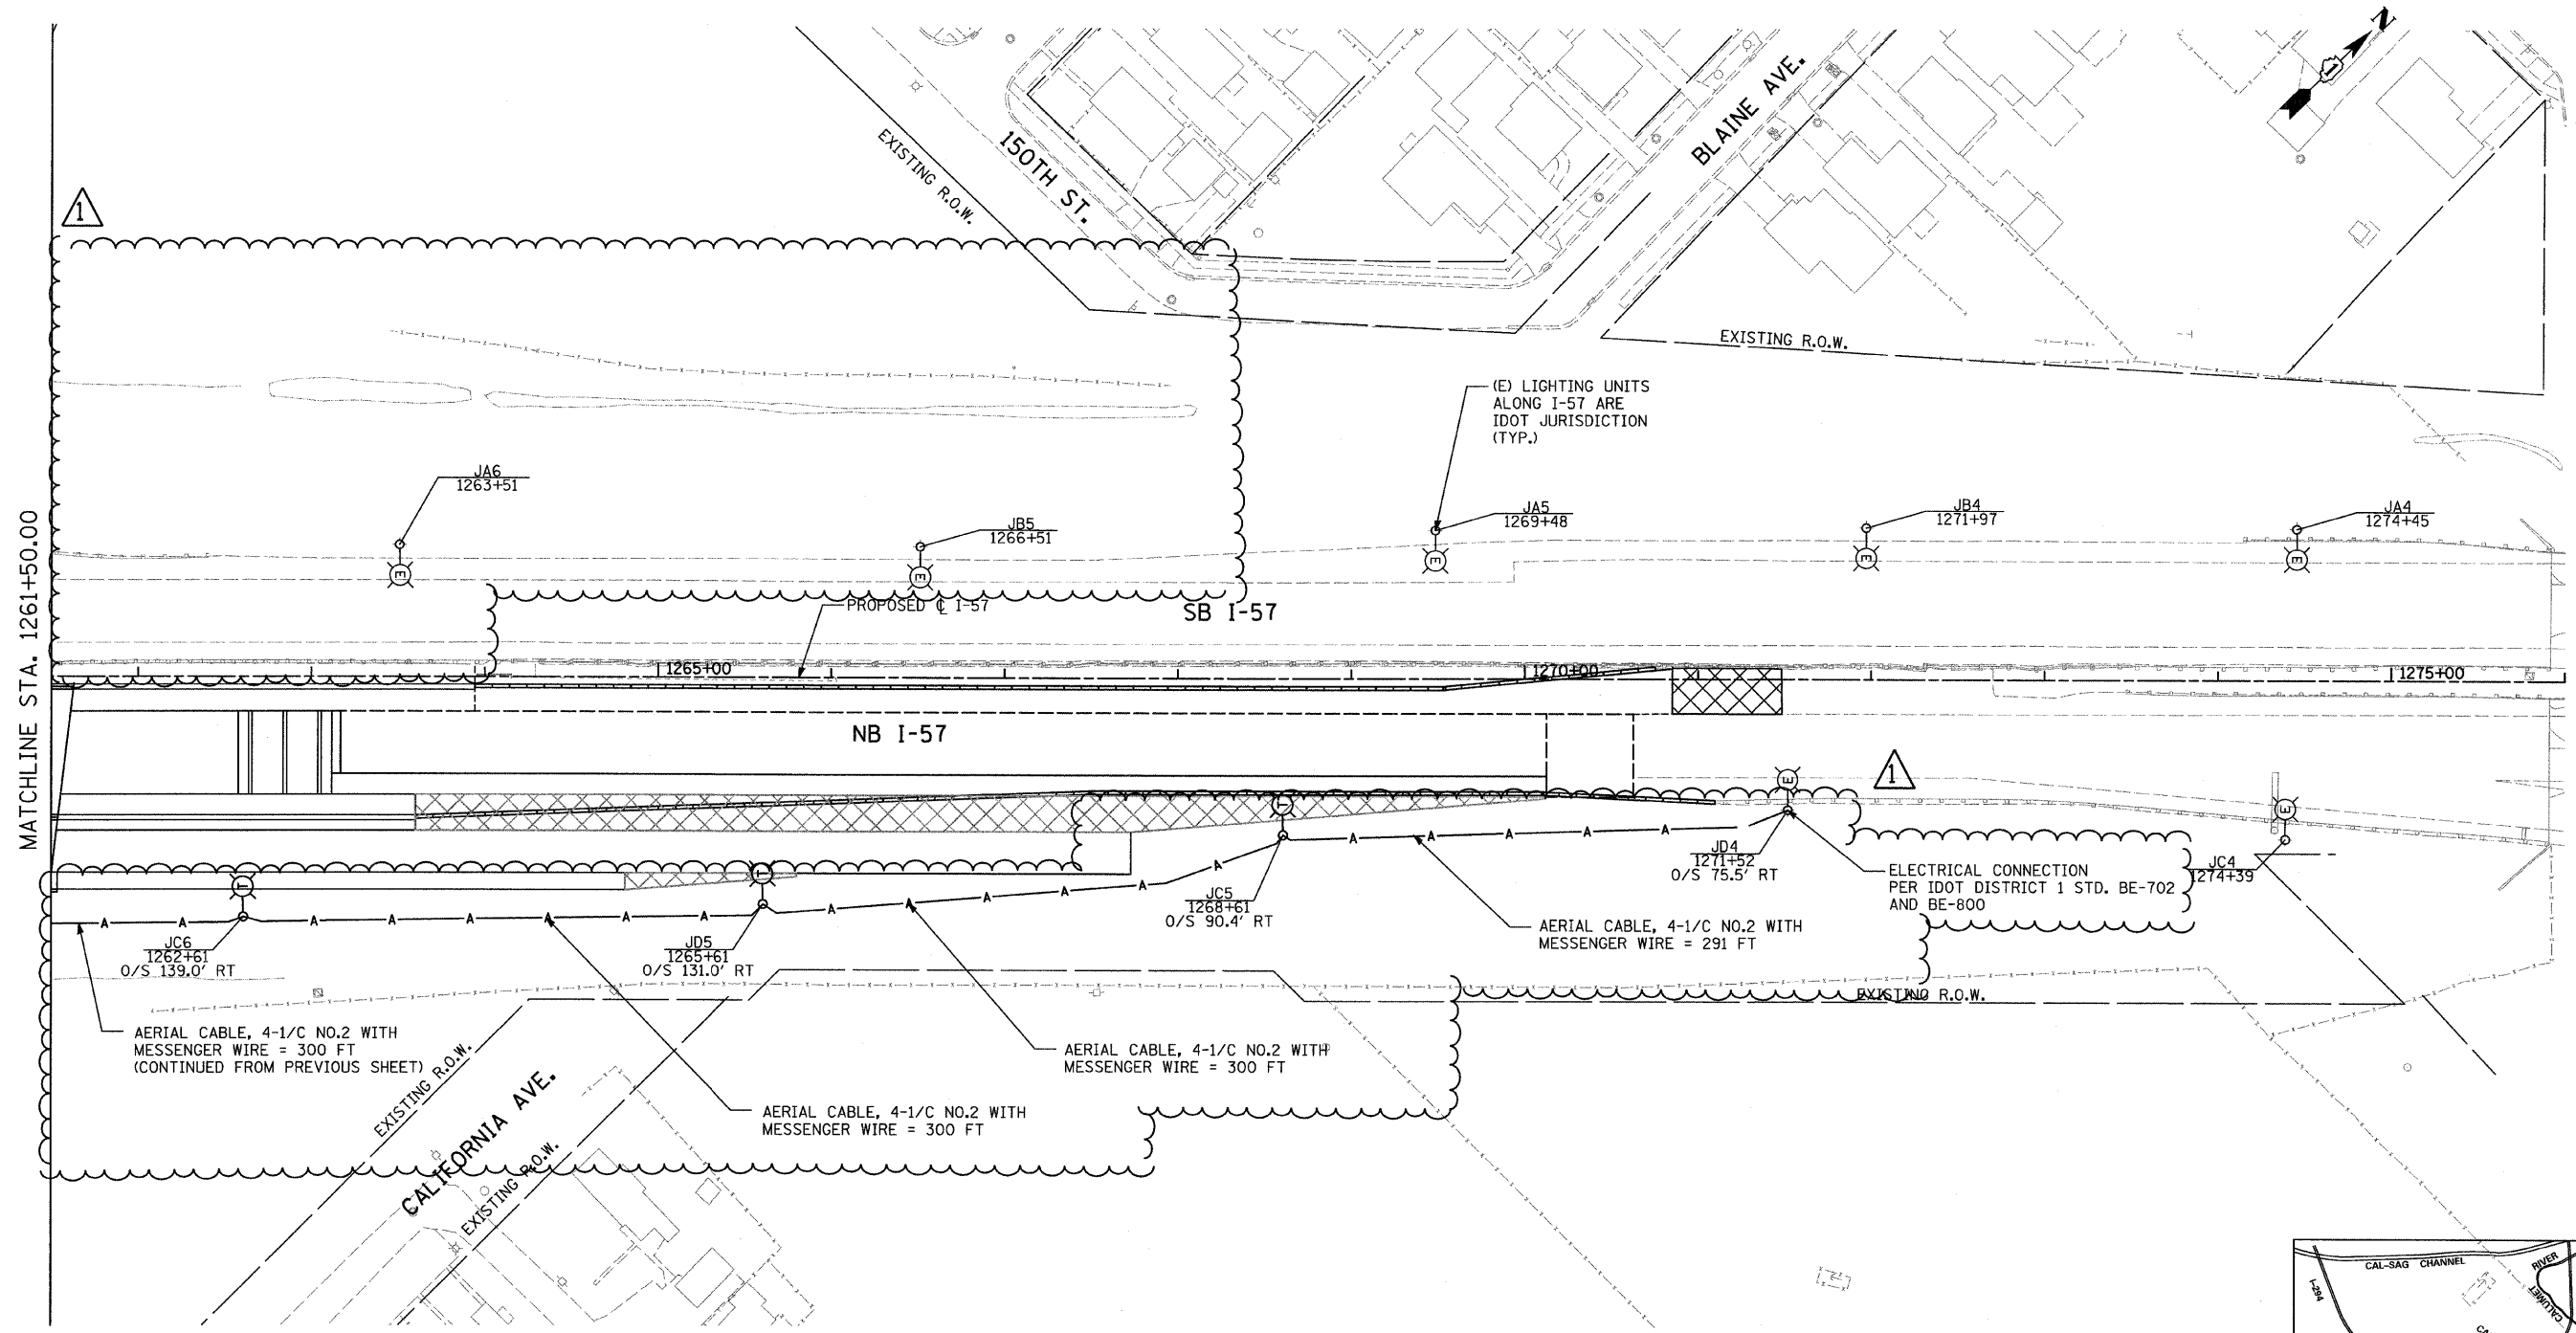
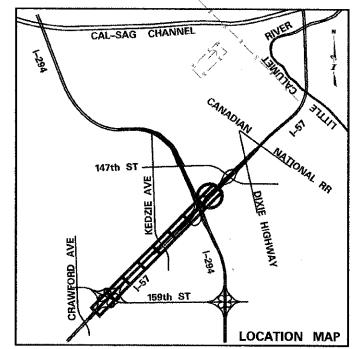


D:\602540(57-294)\road\elec\PI\_PR\_LGT\_SHT08.dwg



- NOTES:**
1. IDOT LIGHTING CONTROLLER "K" IS LOCATED AT I-57 STA. 1238+45 ALONG SB I-57.
  2. IDOT LIGHTING CONTROLLER "J" IS LOCATED AT I-57 STA. 1286+79 ALONG NB I-57 ON 147TH STREET.

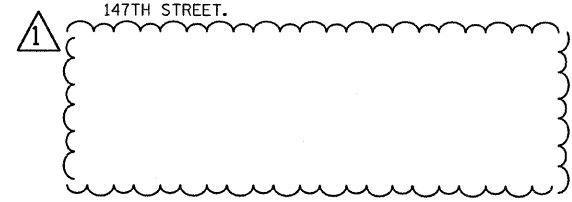

**SHEET E8**

<b>TYLIN INTERNATIONAL</b>	USER NAME =	DESIGNED - JDF	REVISED $\Delta$ - ADDENDUM 1 05/24/10
	PLOT SCALE =	DRAWN - JDF	REVISED -
	PLOT DATE =	CHECKED - DAJ	REVISED -
		DATE - 3/18/2010	REVISED -

**STATE OF ILLINOIS  
DEPARTMENT OF TRANSPORTATION**

**I-57 AT I-294 INTERCHANGE PROJECT**  
**PROPOSED STAGE 2 TEMPORARY LIGHTING PLANS - I-57**

SCALE: SHEET NO. 3 OF 4 SHEETS STA. 1261+50 TO STA. 1276+00

F.A.I. RTE. 57	SECTION 1414.2B	COUNTY COOK	TOTAL SHEETS 516	SHEET NO. 208
FED. ROAD DIST. NO. ILLINOIS			CONTRACT NO. 60J27	

D:\602540(57-294)\road\elec\PI\_PR\_LGT\_SHT08.dwg

5/24/2010 9:44:38 AM