
 
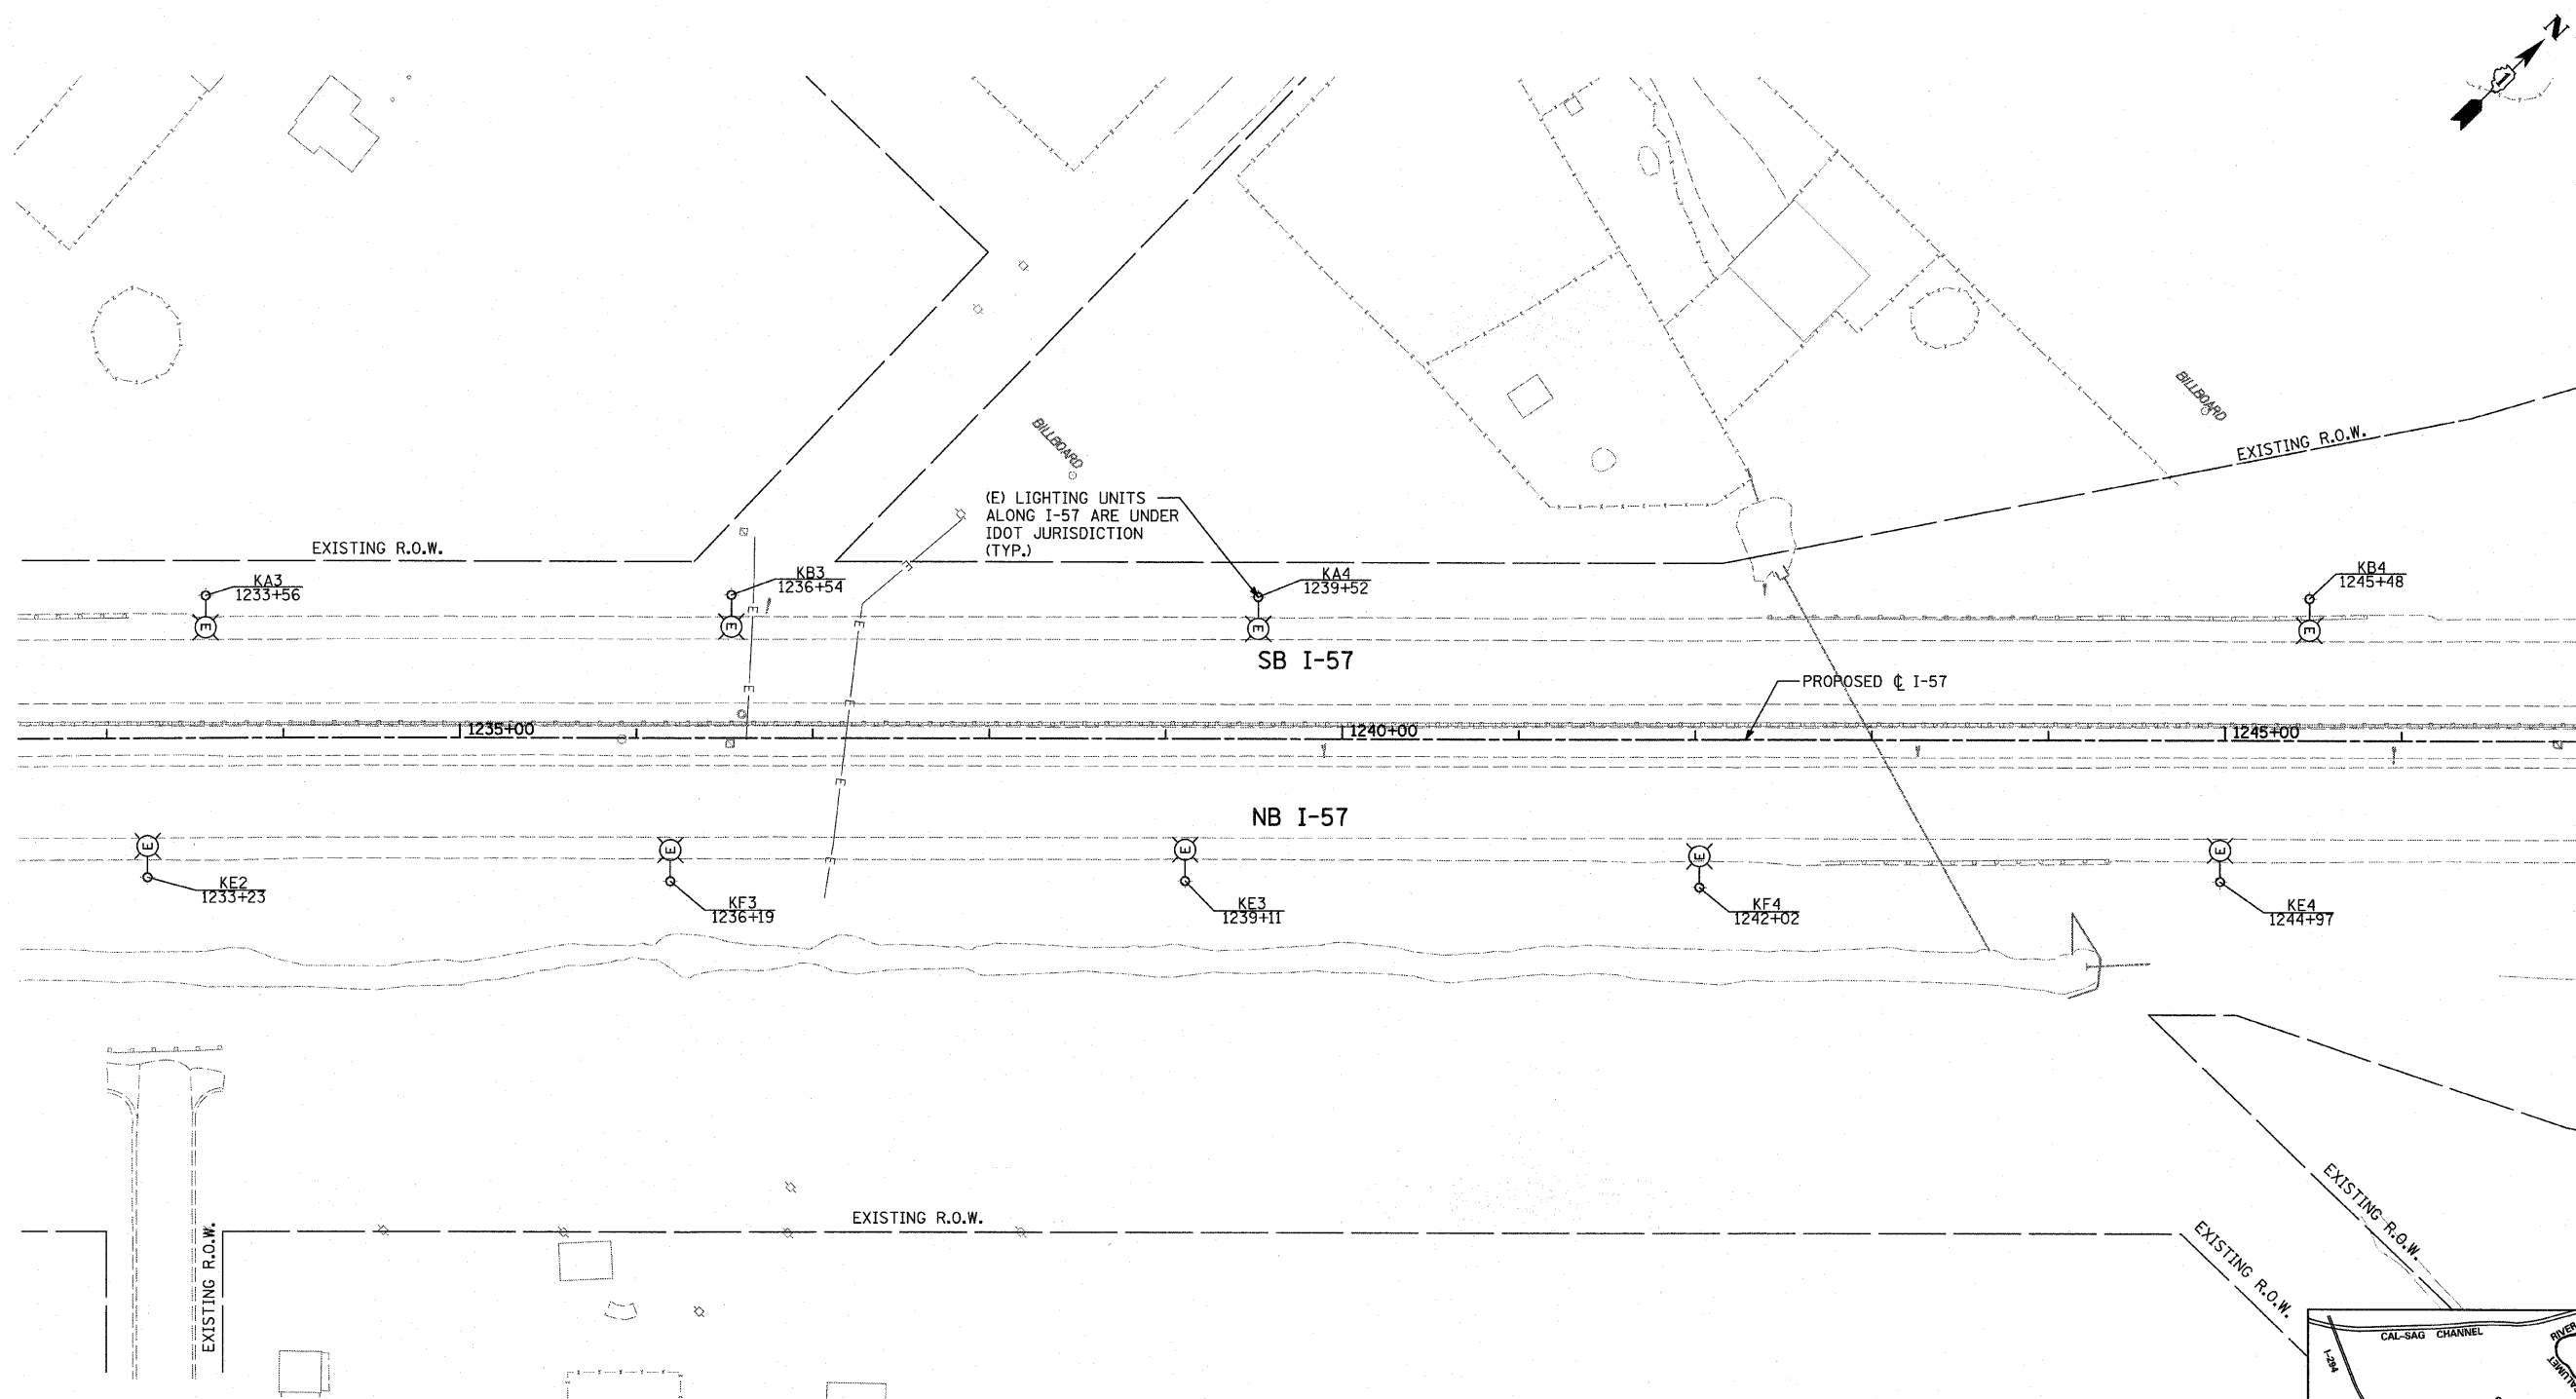


P:\602540(57-294)\road\elec\PI_EX.LGT_SHT06.dgn 3/23/2010 7:01:5 AM



- NOTES:**
1. IDOT LIGHTING CONTROLLER "K" IS LOCATED AT I-57 STA. 1238+45 ALONG SB I-57.
 2. IDOT LIGHTING CONTROLLER "J" IS LOCATED AT I-57 STA. 1286+79 ALONG NB I-57 ON 147TH STREET.

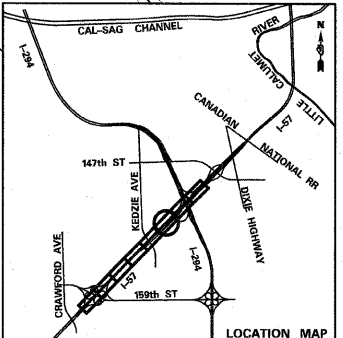

MATCHLINE STA. 1247+00.00

TYLIN INTERNATIONAL

USER NAME =	DESIGNED - JDF	REVISED -
PLOT SCALE =	DRAWN - JDF	REVISED -
PLOT DATE =	CHECKED - DAJ	REVISED -
	DATE - 3/18/2010	REVISED -

**STATE OF ILLINOIS
DEPARTMENT OF TRANSPORTATION**

I-57 AT I-294 INTERCHANGE PROJECT EXISTING LIGHTING PLANS - I-57		
SCALE: 1" = 50'	SHEET NO. 1 OF 4 SHEETS	STA. 1232+50 TO STA. 1247+00

F.A.I. RTE. 57	SECTION 1414.2B	COUNTY COOK	TOTAL SHEETS 516	SHEET NO. 202
CONTRACT NO. 60J27			ILLINOIS FED. AID PROJECT	