



F.A.I. RTE.	SECTION	COUNTY	TOTAL SHEETS	SHEET NO.
57	068-2222-3B	COOK	77	24
STA.		TO STA.		
FED. ROAD DIST. NO.		ILLINOIS FED. AID PROJECT		

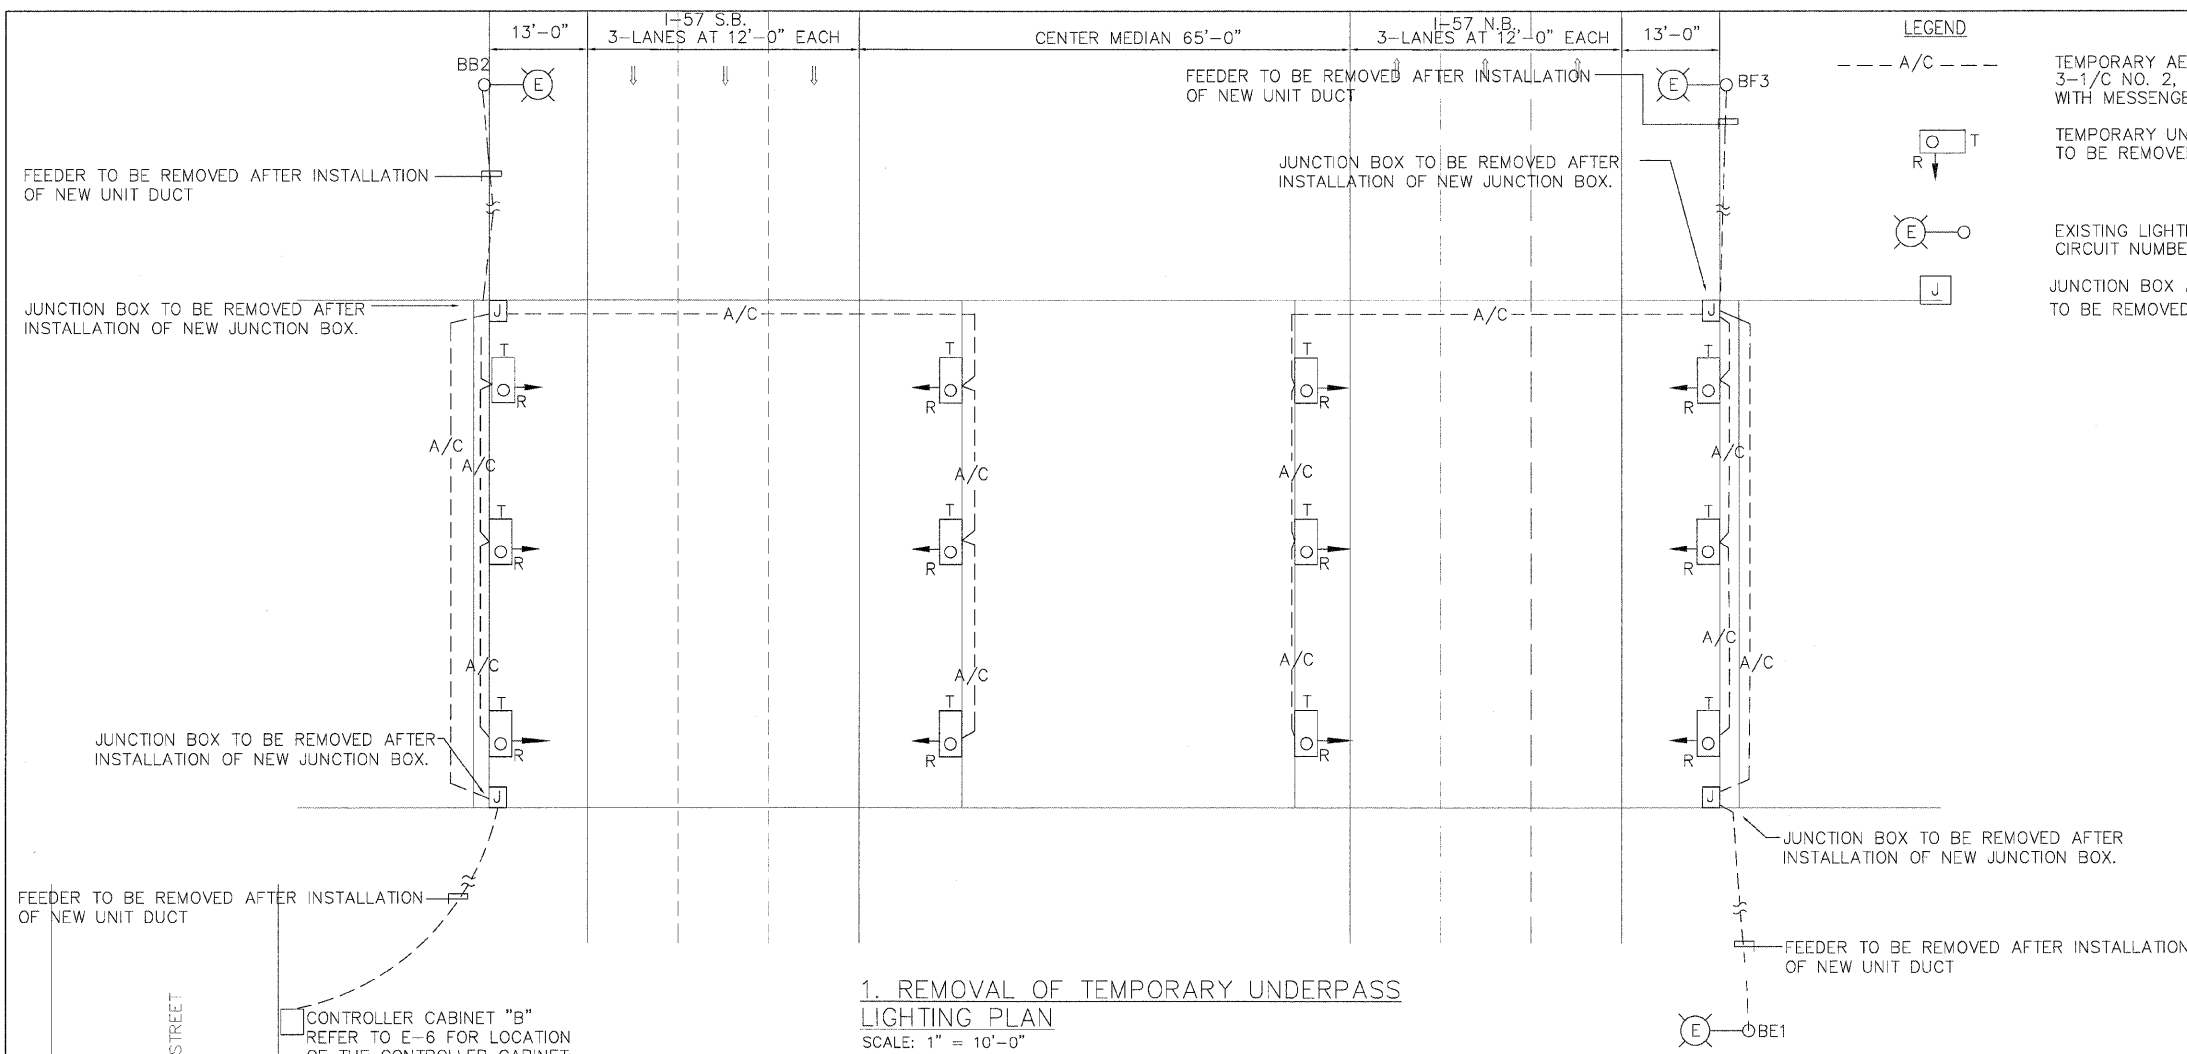

LEGEND

- A/C --- TEMPORARY AERIAL CABLE 3-1/C NO. 2, ALUMINUM, WITH MESSENGER WIRE TO BE REMOVED
- [Symbol] T TEMPORARY UNDERPASS LUMINAIRE TO BE REMOVED
- [Symbol] E EXISTING LIGHTING UNIT AND POLE TO REMAIN, CIRCUIT NUMBER AS NOTED.
- [Symbol] J JUNCTION BOX ATTACHED TO STRUCTURE TO BE REMOVED

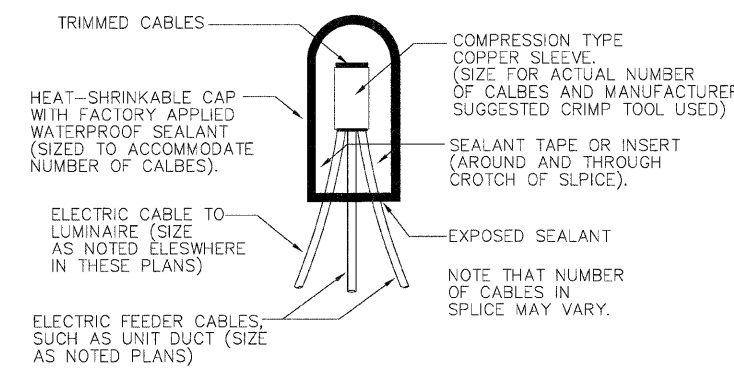


**3. SPLICING ELECTRIC CABLES
BASIC MATERIALS AND METHODS**
N.T.S.


1. REMOVAL OF TEMPORARY UNDERPASS LIGHTING PLAN
SCALE: 1" = 10'-0"

CONTROLLER CABINET "B"
REFER TO E-6 FOR LOCATION
OF THE CONTROLLER CABINET

S. ELIZABETH STREET

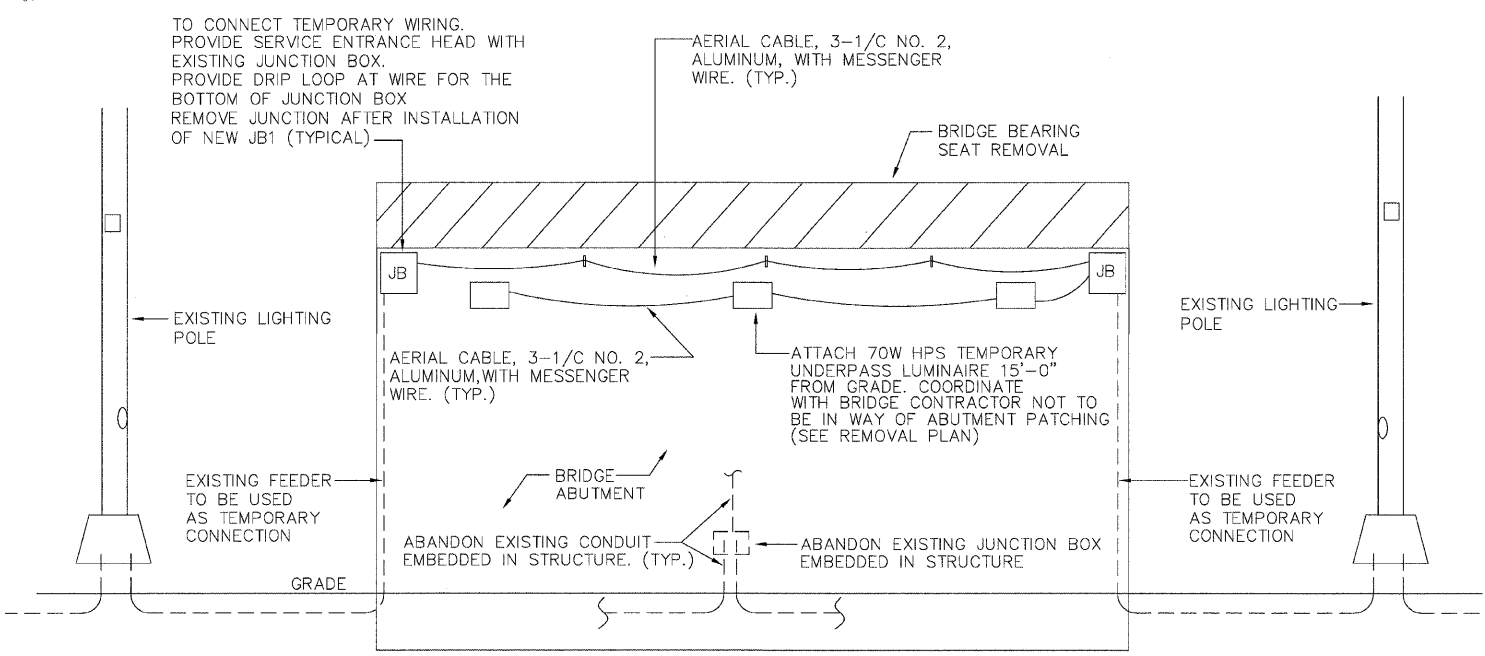

2. TEMPORARY LIGHTING SECTION FOR UNDERPASS LIGHTING
N.T.S.

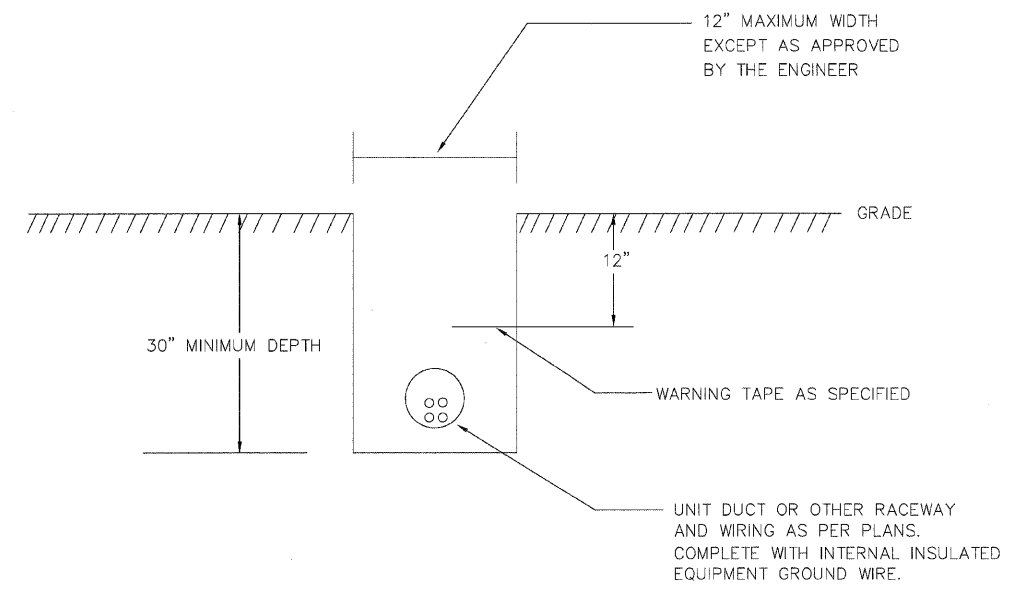

4. TYPICAL WIRING IN TRENCH DETAILS
N.T.S.

Advance
Consulting Group International
300 W. ADAMS ST.
SUITE 122
CHICAGO, IL 60606
TEL: 312-357-1940
FAX: 312-357-1945
EMAIL: advance@acgintl.com

REVISIONS	
NAME	DATE

ILLINOIS DEPARTMENT OF TRANSPORTATION

GENOA AVE
ELECTRICAL DETAILS

DRAWN BY EHE
CHECKED BY EE
DATE 8-4-09