 



SECTION 2, TOWNSHIP 35, RANGE 12  
 SECTION 11, TOWNSHIP 35, RANGE 12  
 SECTION 1, TOWNSHIP 35, RANGE 12  
 SECTION 12, TOWNSHIP 35, RANGE 12



DATE	
BY	
REVISIONS	
PLANNED	
ALIGNED	
CHECKED	
NOTED	
FILE NAME	
PLAN	
NOTE BOOK	
NO.	

DATE	
BY	
REVISIONS	
PLANNED	
GRADES	
CHECKED	
NOTED	
PROFILE	
NOTE BOOK	
NO.	

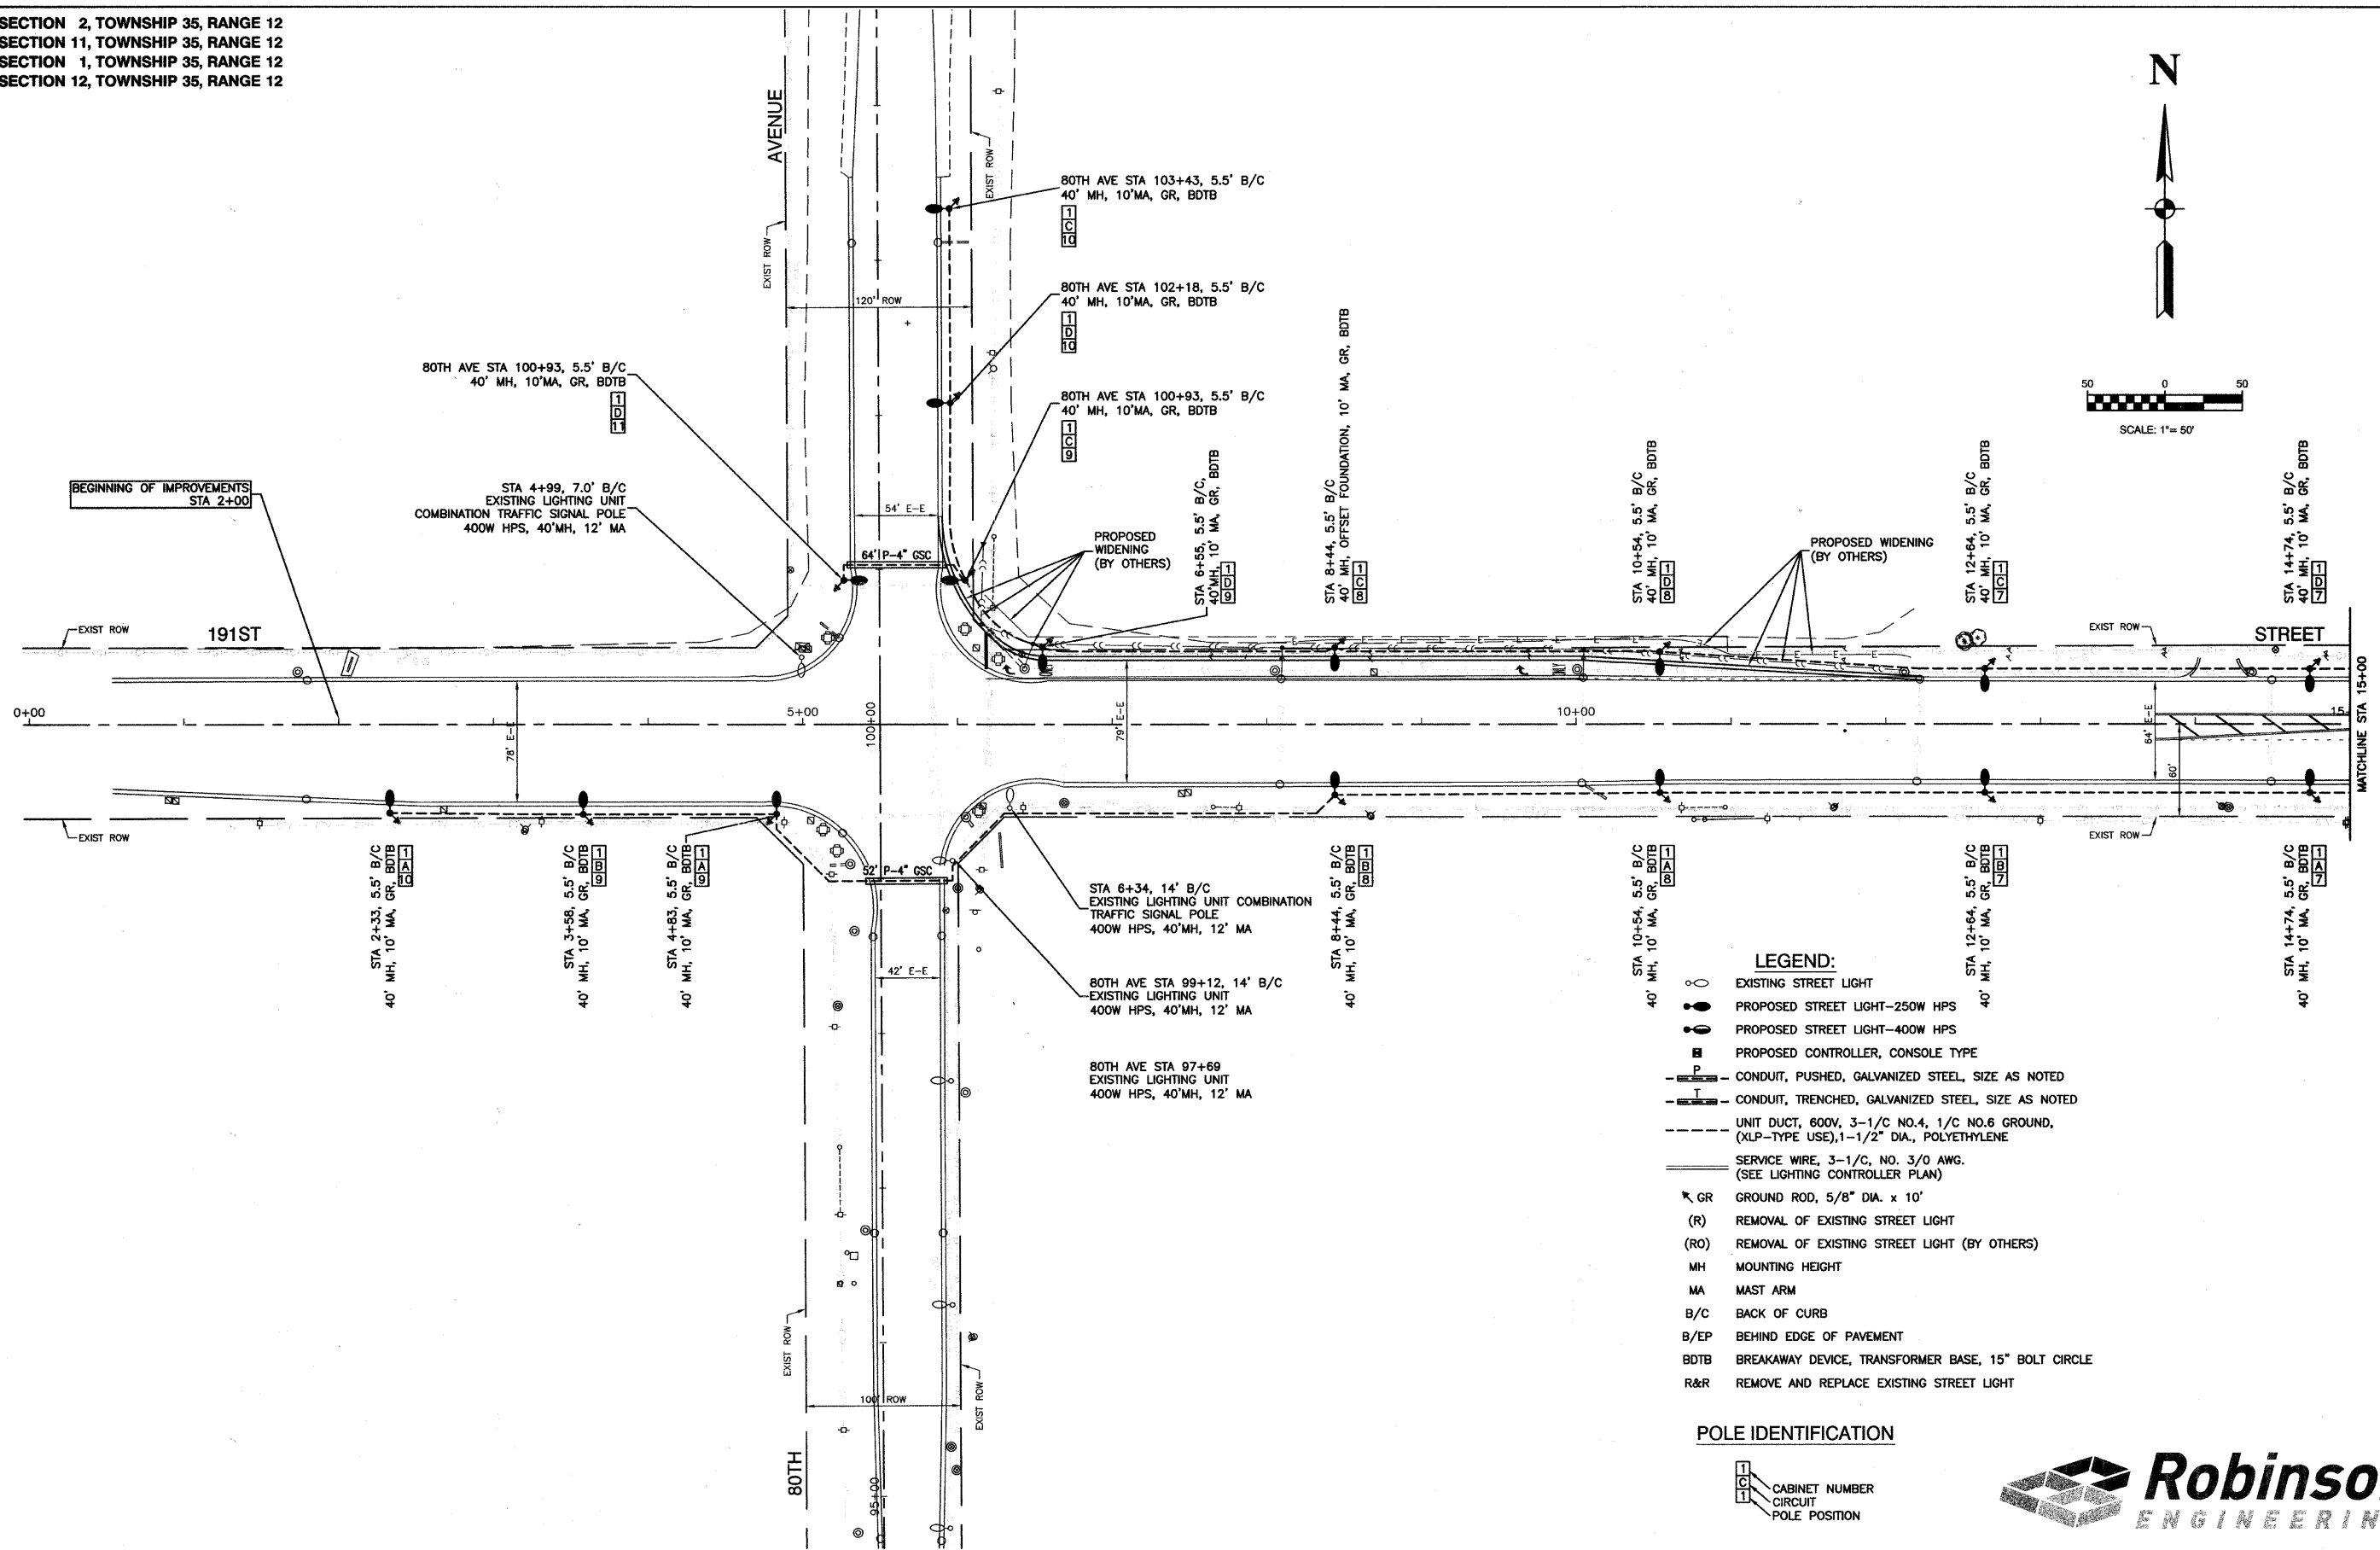

FILE NAME = 09302-PLAN-01 - IDOT P01

USER NAME =	DESIGNED -- DWS	REVISIONS
	CHECKED -- EJT	REVISIONS
PLOT SCALE = 1"=50'	DRAWN -- MJD	REVISIONS
PLOT DATE = 10-20-09	CHECKED -- PAP	REVISIONS

STATE OF ILLINOIS  
 DEPARTMENT OF TRANSPORTATION

191ST STREET  
 80TH AVENUE (FAU 2755) TO HARLEM AVENUE (FAP 0348)  
 STREET LIGHTING PLANS

SCALE: 1"=50' SHEET NO. 3 OF 12 SHEETS STA. 2+00 TO STA. 15+00

F.A.U. RTE.	SECTION	COUNTY	TOTAL SHEETS	SHEET NO.
3754	09-00107-00-LT	WILL	12	3
CONTRACT NO. 63288				
FED. ROAD DIST. NO. 1 ILLINOIS FED. AID PROJECT M-9003 (331)				

