



DATE	
BY	
REVISIONS	
NO.	
PLAN	
NO.	
NOTE BOOK	
NO.	
ADD. FILE NAME	

DATE	
BY	
REVISIONS	
NO.	
PLAN	
NO.	
NOTE BOOK	
NO.	
ADD. FILE NAME	

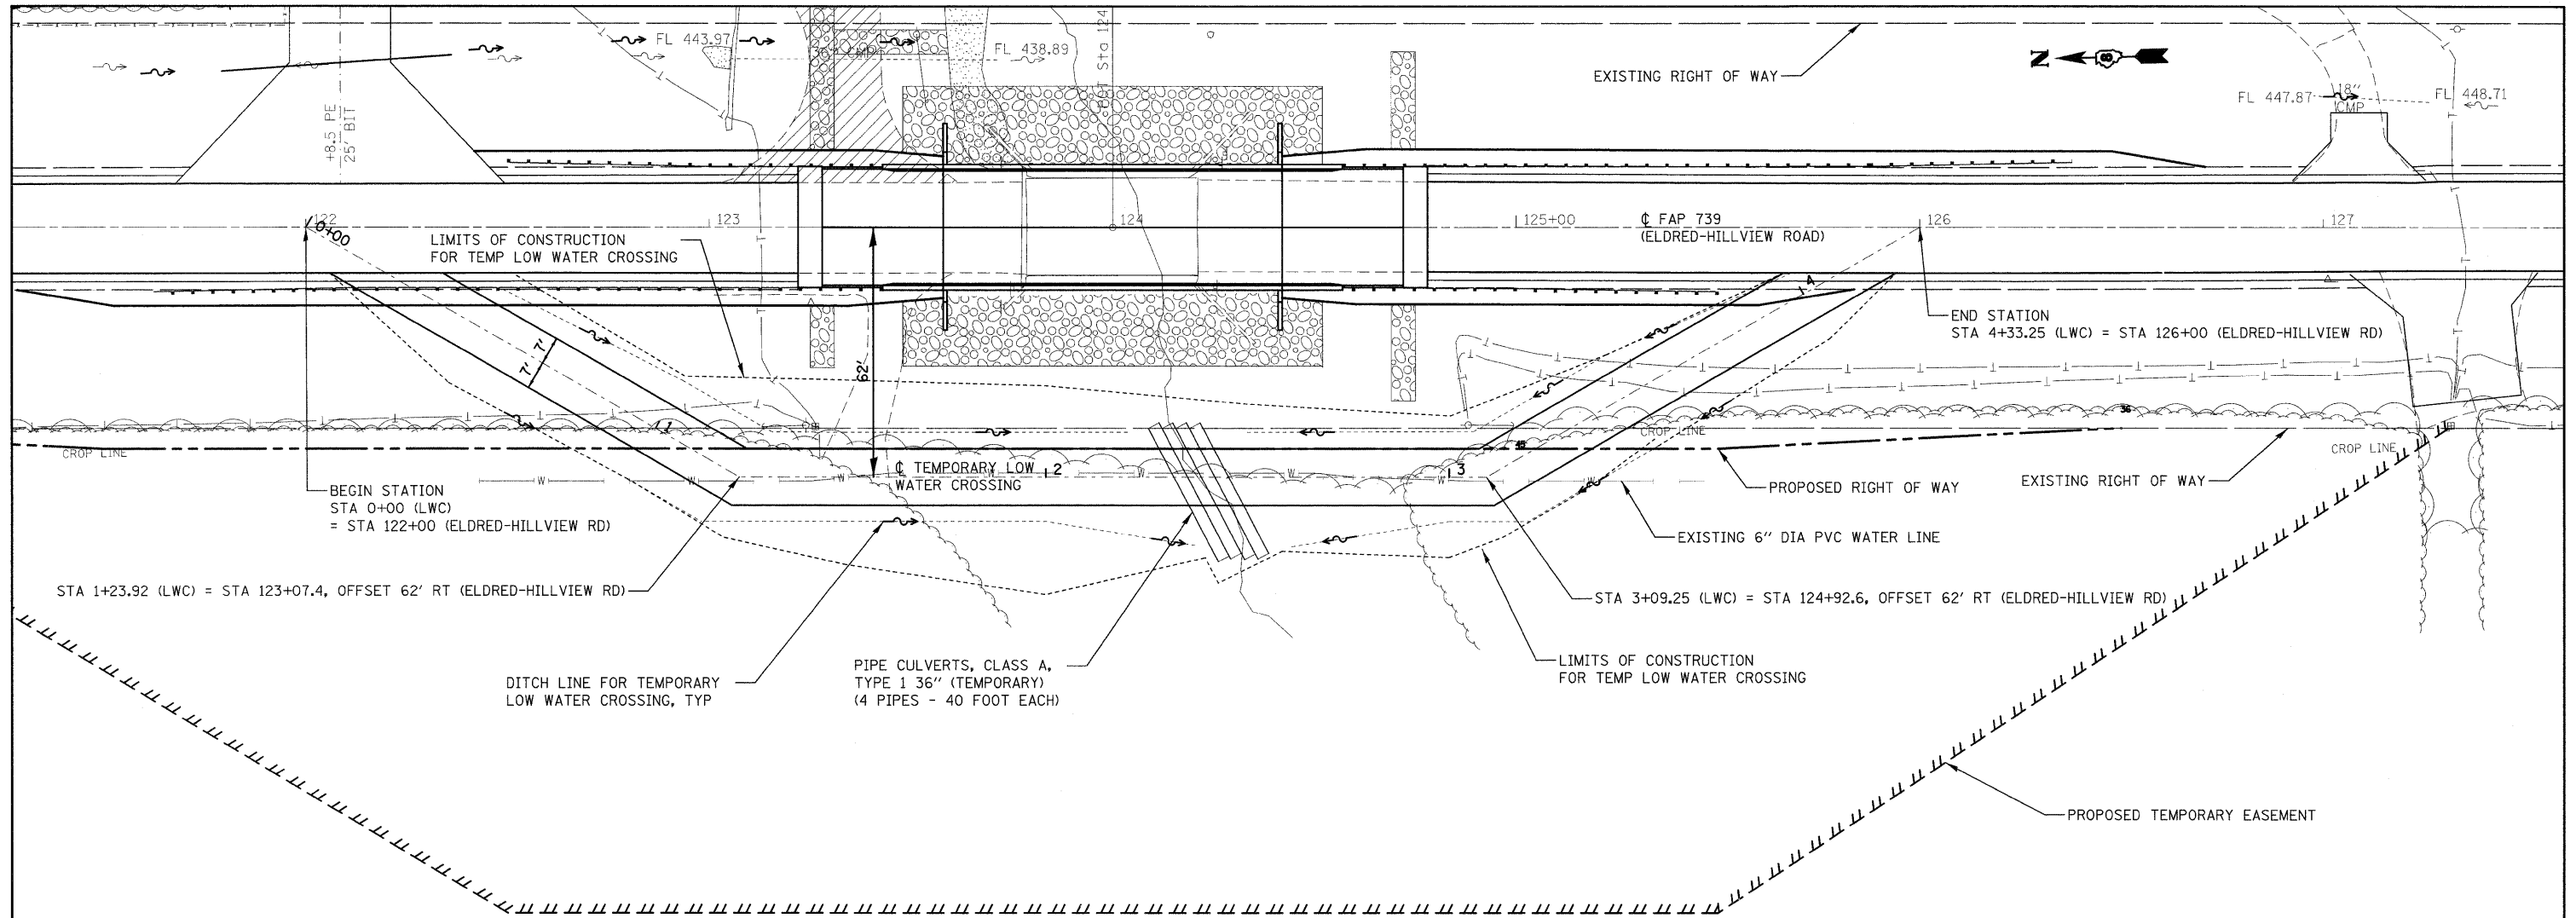

NOTE: EXISTING GROUND LINE HAS BEEN MODIFIED FROM WHAT IS SHOWN DUE TO PLACEMENT OF EXISTING 6" DIA PVC WATER LINE AFTER SURVEY.

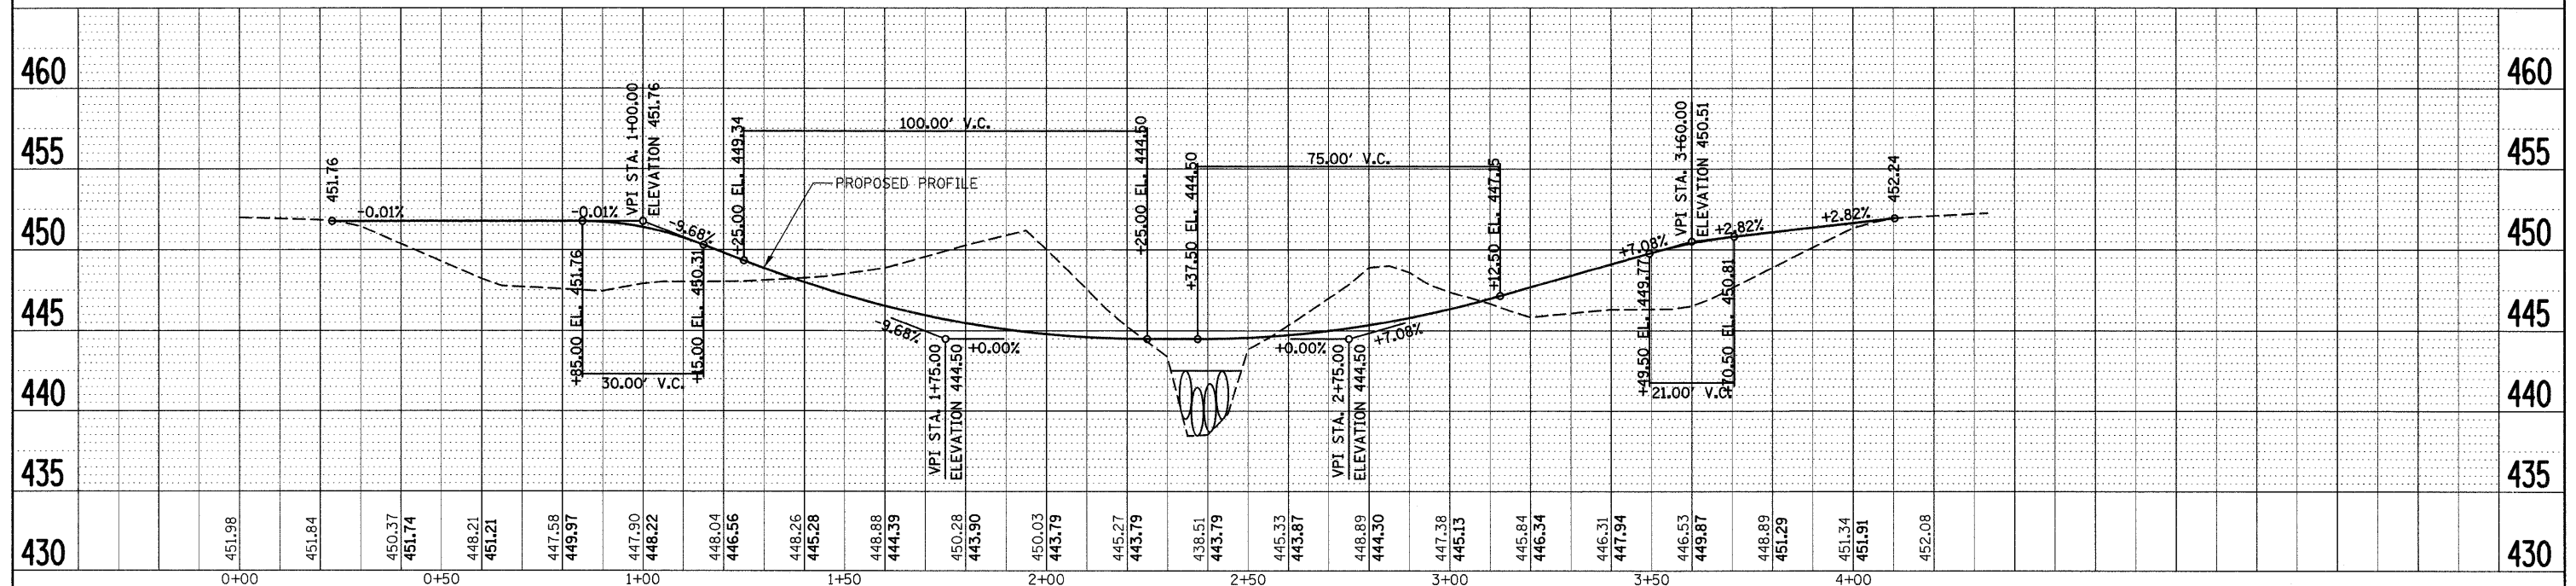

FILE NAME =	USER NAME = tharpr1	DESIGNED -	REVISED -	STATE OF ILLINOIS DEPARTMENT OF TRANSPORTATION	PLAN AND PROFILE TEMPORARY LOW WATER CROSSING SN 031-0013(E) SN 0041(P), SECTION 401-2BR	F.A.S. RTE.	SECTION	COUNTY	TOTAL SHEETS	SHEET NO.
ca:\pwork\PWID01\THARPR1\dms52692\shp\prf_LWC-1.dgn	PLOT SCALE = 20,0000' / IN.	DRAWN -	REVISED -			739	1BR, 1-2BR, 401-2BR	GREENE	150	26
PLOT DATE = 4/26/2010	DATE -	CHECKED -	REVISED -			CONTRACT NO. 76410				
		DATE -	REVISED -			ILLINOIS FED. AID PROJECT				